

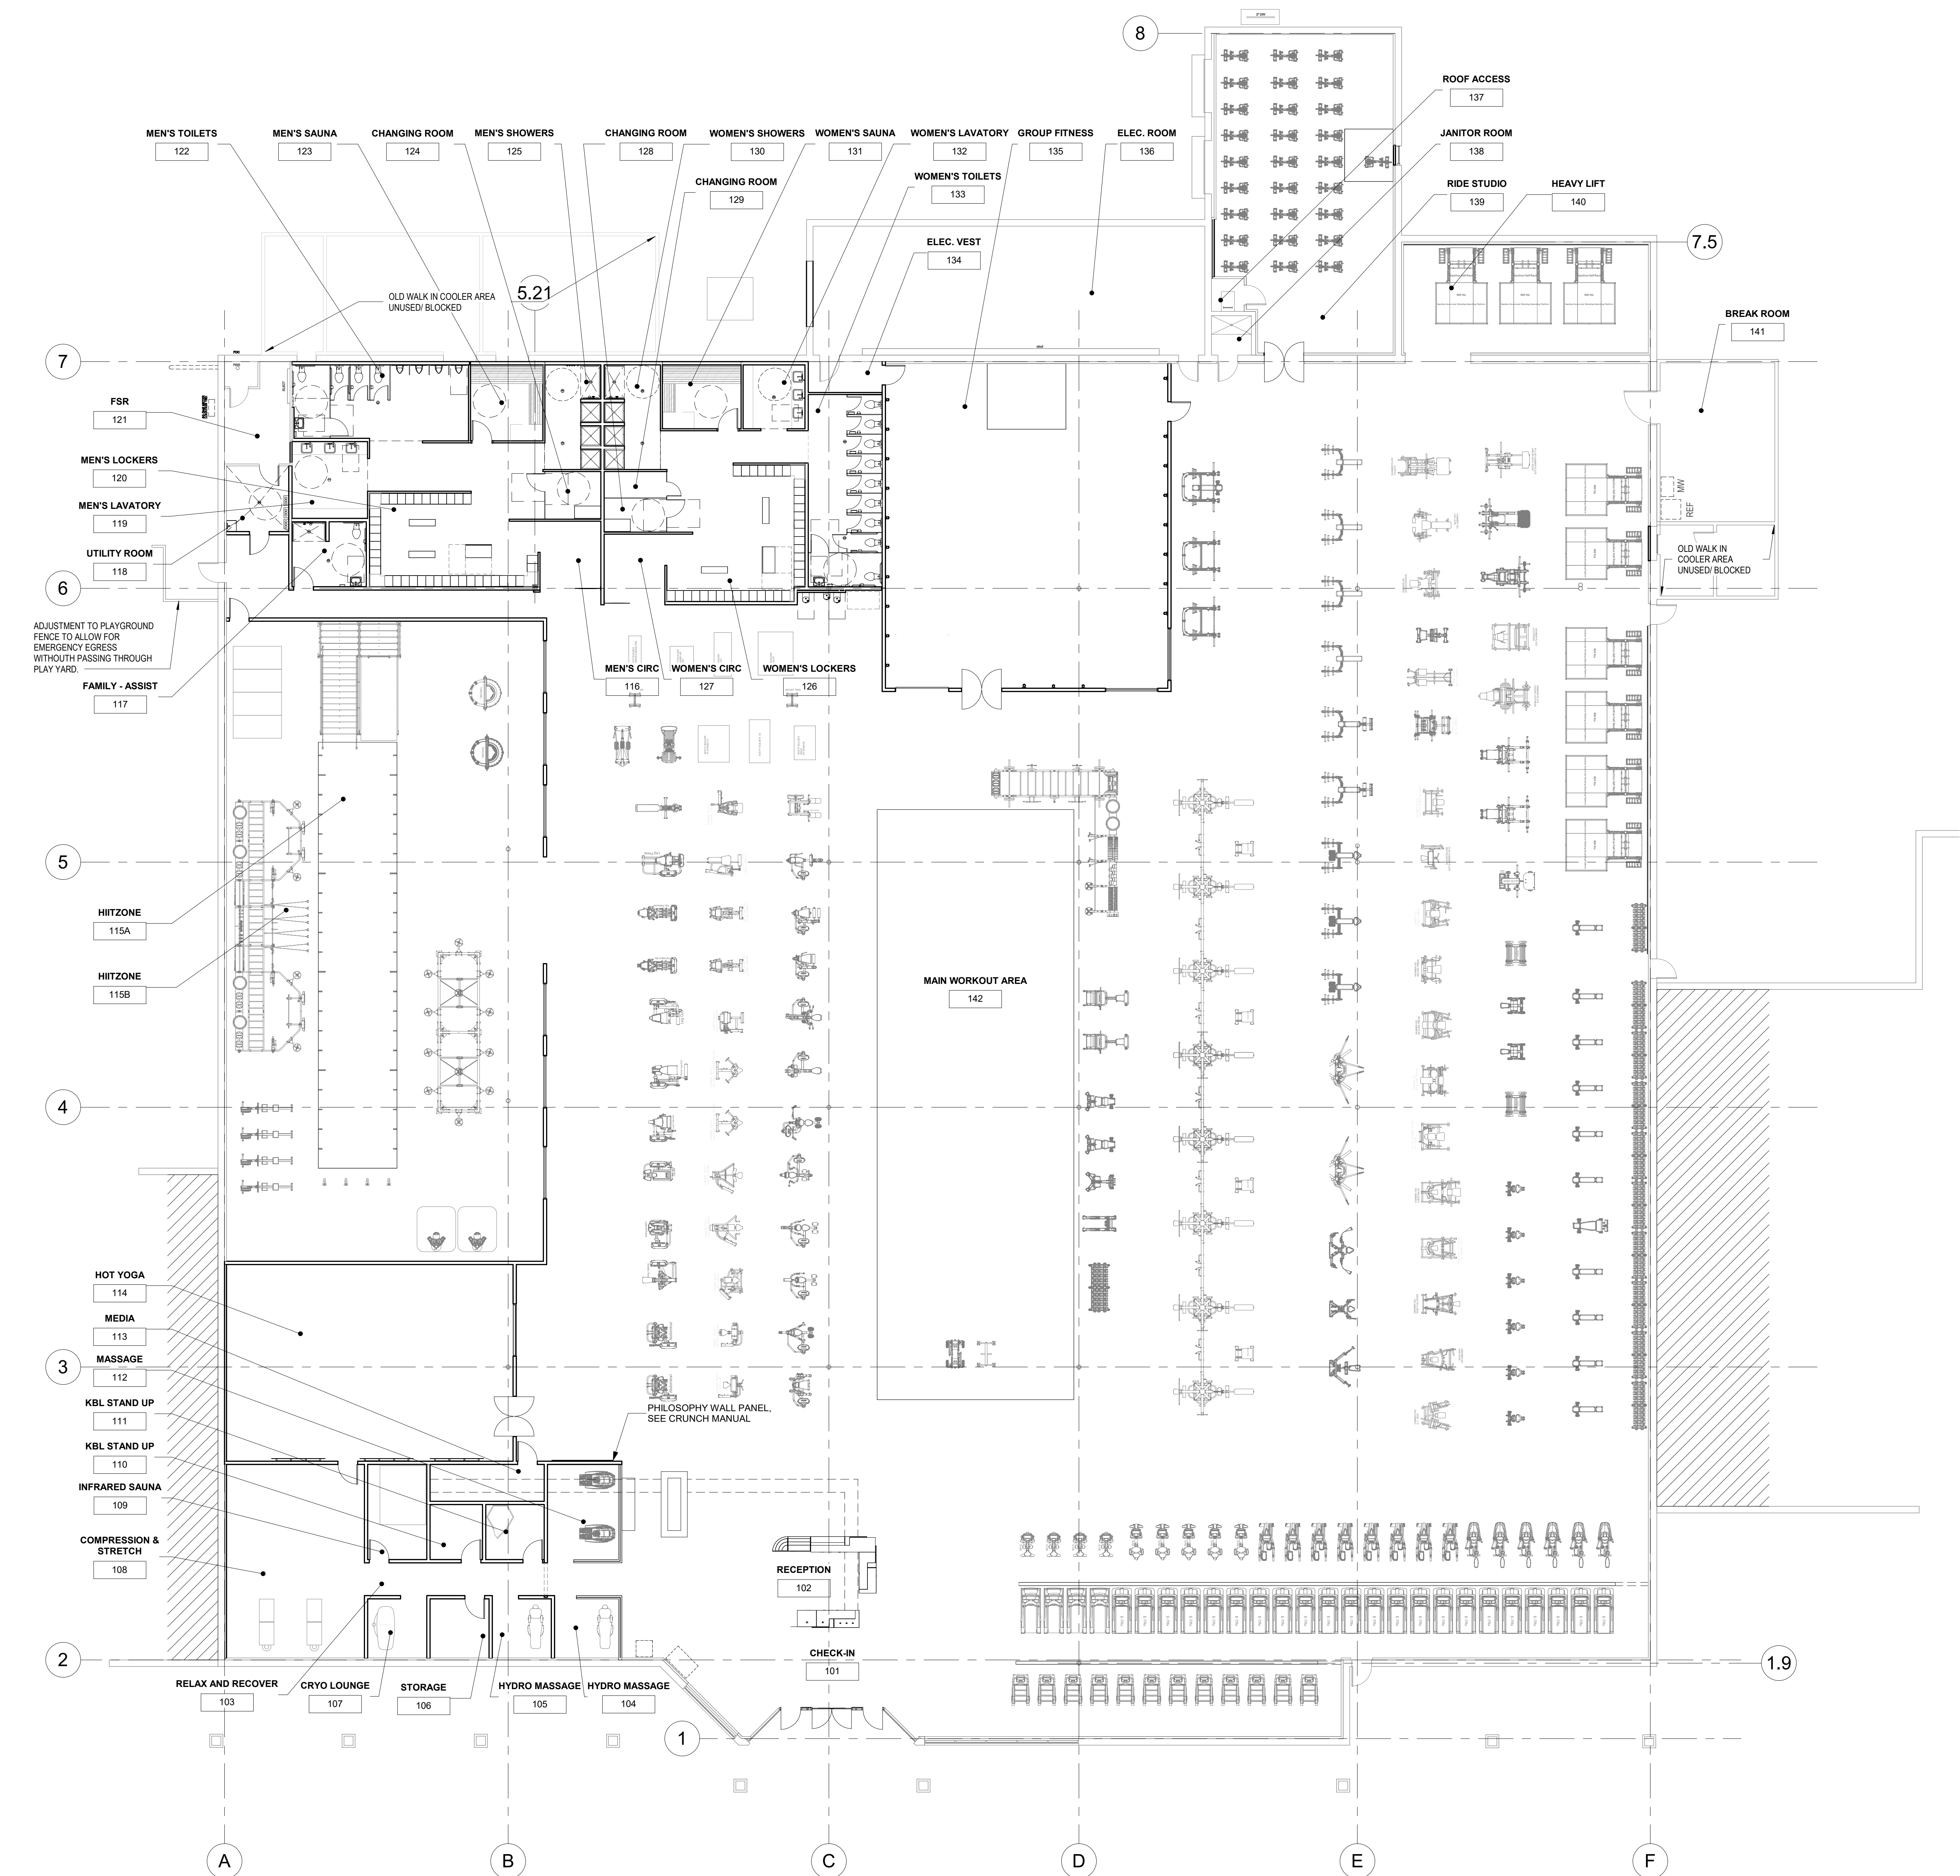


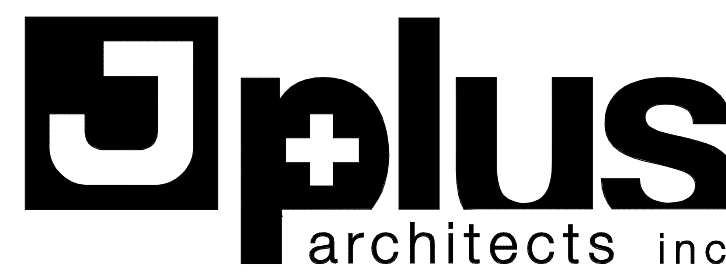

1 CONCEPTUAL FLOOR PLAN
3/32" = 1'-0"

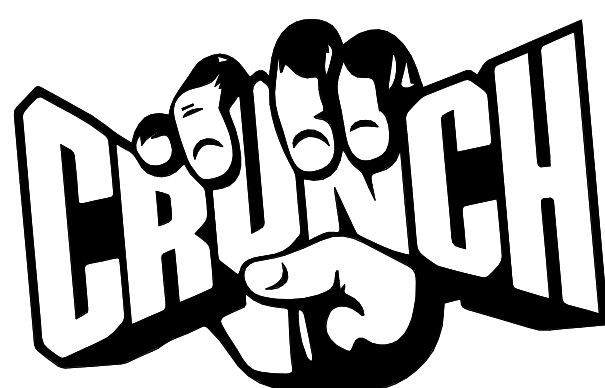

JPLUS ARCHITECTS INC.
A FULL SERVICE ARCHITECTURAL COMPANY

211 BULEN STREET
ROSEVILLE, CA 95678
TEL: (916) 568 - 9169
FAX: (916) 488 - 5982

THESE DRAWINGS ARE INSTRUMENTS OF SERVICE AND ARE THE PROPERTY OF JPLUS ARCHITECTS, INC. ALL DESIGN AND OTHER INFORMATION ON THE DRAWINGS ARE FOR THE USE ON THE SPECIFIED PROJECT AND SHALL NOT BE USED OTHERWISE WITHOUT THE EXPRESSED WRITTEN PERMISSION OF JPLUS ARCHITECTS, INC.

WRITTEN DIMENSIONS ON THESE DRAWINGS SHALL HAVE PRECEDENCE OVER SCALED DIMENSIONS. CONTRACTOR SHALL VERIFY AND BE RESPONSIBLE FOR ALL DIMENSION AND CONDITIONS ON THE JOB SITE, AND THIS OFFICE SHALL BE NOTIFIED OF ANY VARIATIONS FROM THE DIMENSIONS AND CONDITIONS AS SHOWN ON THESE DRAWINGS.

THIS DRAWING IS NOT FINAL.
OR TO BE USED FOR
CONSTRUCTION UNTIL THE
ARCHITECT'S SEAL AND
SIGNATURE APPEAR TO THE
RIGHT.

PROJECT TEAM

BUILDING OWNER

TBD

FRANCHISE

Crunch Fitness

22 W. 19th St.

New York, NY 10011

(212) 262-2344

Brent Saul,

Vice President of Construction

brent@crunchfitness.com

FRANCHISEE

CR Fitness Holdings LLC

3915 Riga Boulevard

Tampa, FL 33619

(813) 737-3819

Mark Gimys

mark.gimys@cr.fitness

TENANT

Crunch Fitness

10330 S US HWY 1

PORT ST LUCIE FL 34952

(813) 737-3819

Mark Gimys

mark.gimys@cr.fitness

MECHANICAL

PLUMBING

ELECTRICAL

Dave M. Saarem, P.E.

2188 Alfred Way

Carson City, NV 89703

(755) 772-8846

Dave Saarem

dave@saarengineering.com

STRUCTURAL

H. Eugene Hunter, P.E.

1056 Heather Glen Dr.

Matthews, NC 28104

(704) 574-8083

Gene Hunter

ghunter@carolina.ri.com

FIRE ALARM / FIRE

SPRINKLER

Nearby Engineers

382 NE 191st St, Suite 48674

Miami, FL 33179

(212) 575-5300

Ankit Javeri

anj@ny-engineers.com

CRUNCH FITNESS

10330 S US HIGHWAY 1

PORT ST. LUCIE, FL 34952

CONSTRUCTION DRAWINGS

APN: 4412-504-0005-000-9 /

PID 139851

SHEET TITLE

CONCEPTUAL FLOOR PLAN

NO.	DESCRIPTION	DATE
PROJECT MANAGER	JARED CALLIS	
PROJECT ARCHITECT	JEFF JENNINGS	
SCALE:	AS NOTED	
DATE:	03/22/2024	
PROJECT NO:	23-91	

EX-1