


FILE LOCATION: Z:\EDC\2024\4-18- FOUR PORT ST. LUCIE, LLC - SOUTHERN GROVE\ENGINEERING\AUTOCAD\DWG\024-186 SITE PLAN.DWG, 2025-05-20, 10:41 AM

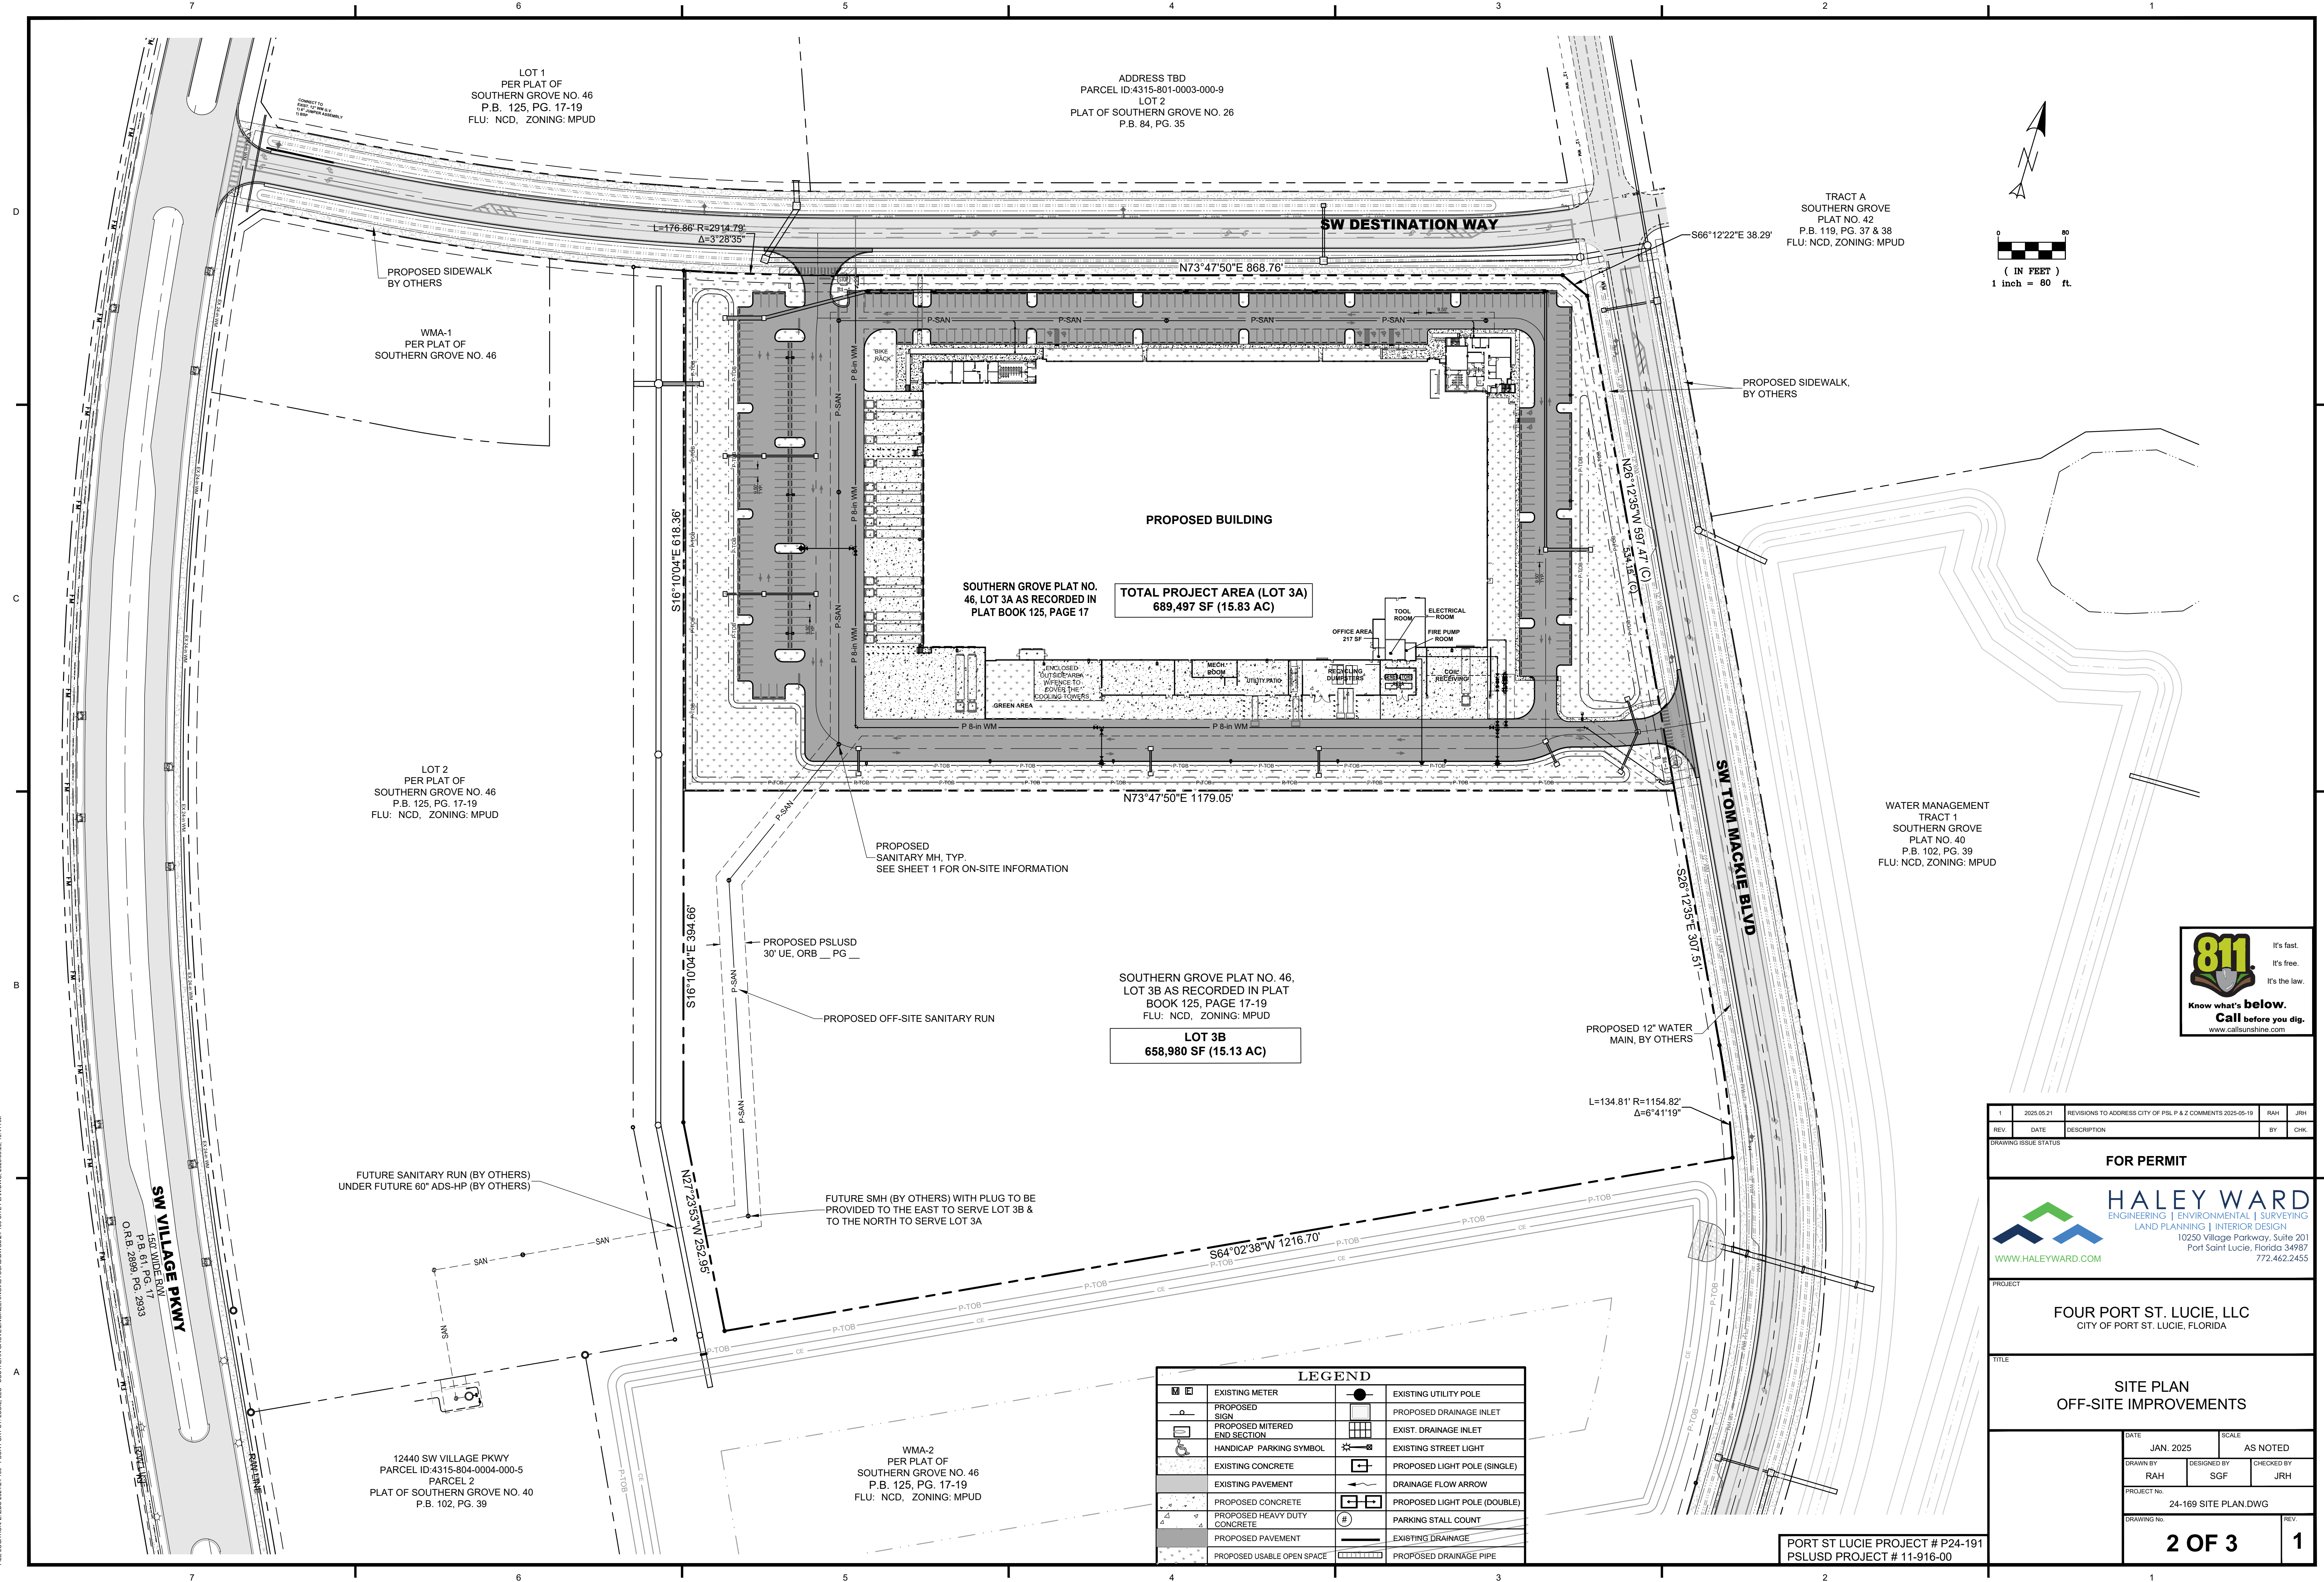

811
Know what's below.
Call before you dig.
www.callsunshine.com

It's fast.
It's free.
It's the law.

1	2025.05.21	REVISIONS TO ADDRESS CITY OF PSL P & Z COMMENTS 2025-05-19	RAH	JRH
REV.	DATE	DESCRIPTION	BY	CHK.

DRAWING ISSUE STATUS

FOR PERMIT

 


HALEY WARD
ENGINEERING | ENVIRONMENTAL | SURVEYING
LAND PLANNING | INTERIOR DESIGN
10250 Village Parkway, Suite 201
Port Saint Lucie, Florida 34987
772.462.2455
WWW.HALEYWARD.COM





PROJECT
FOUR PORT ST. LUCIE, LLC
CITY OF PORT ST. LUCIE, FLORIDA




TITLE
**SITE PLAN
OFF-SITE IMPROVEMENTS**

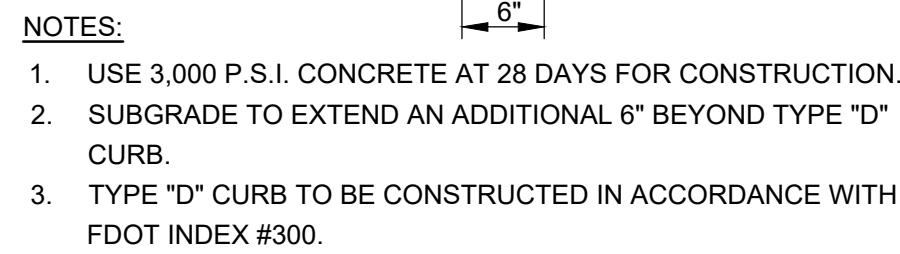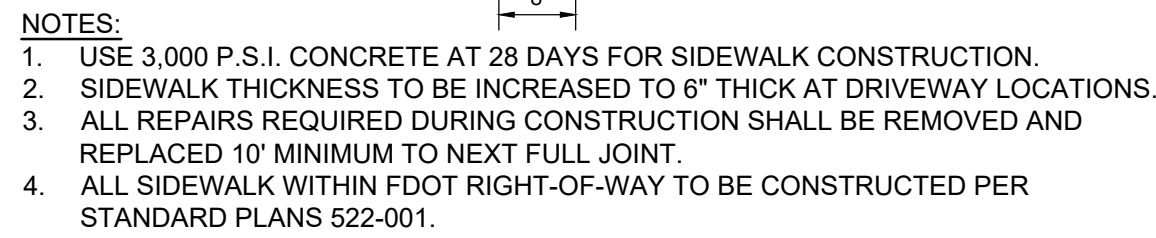
DATE	JAN. 2025	SCALE	AS NOTED
DRAWN BY	RAH	DESIGNED BY	SGF
PROJECT No.	24-169 SITE PLAN.DWG		
DRAWING No.	2 OF 3		
REV.	1		

PORT ST LUCIE PROJECT # P24-191
PSLUSD PROJECT # 11-916-00



Luminaire Schedule								
Symbol	Qty	Label	[MANUFACT]	Description	Arr. Lum. Lumens	LF	Lum. Watts	Total Watts
	6	SA	SIGNIFY GARCOO	ECF-S-6L-1A-NW-Q2-4-HIS POLE MOUNT 25' AFG	21659	0.900	205.9	1235.4
	4	SF	SIGNIFY GARCOO	(2) ECF-S-6L-1A-NW-Q2-6W POLE MOUNT 25' AFG	54650	0.900	205.9	1647.2
	10	SG	SIGNIFY GARCOO	ECF-S-4L-1A-NW-Q2-4-HIS POLE MOUNT 25' AFG	16372	0.900	158.7	1587
	7	WA	SIGNIFY GARCOO	ECF-S-6L-1A-NW-Q2-4 WALL MOUNT 25' AFG	20680	0.900	158.7	1110.9

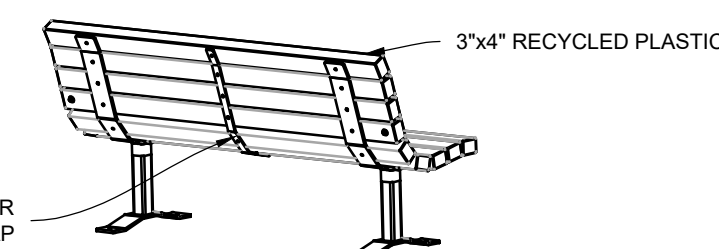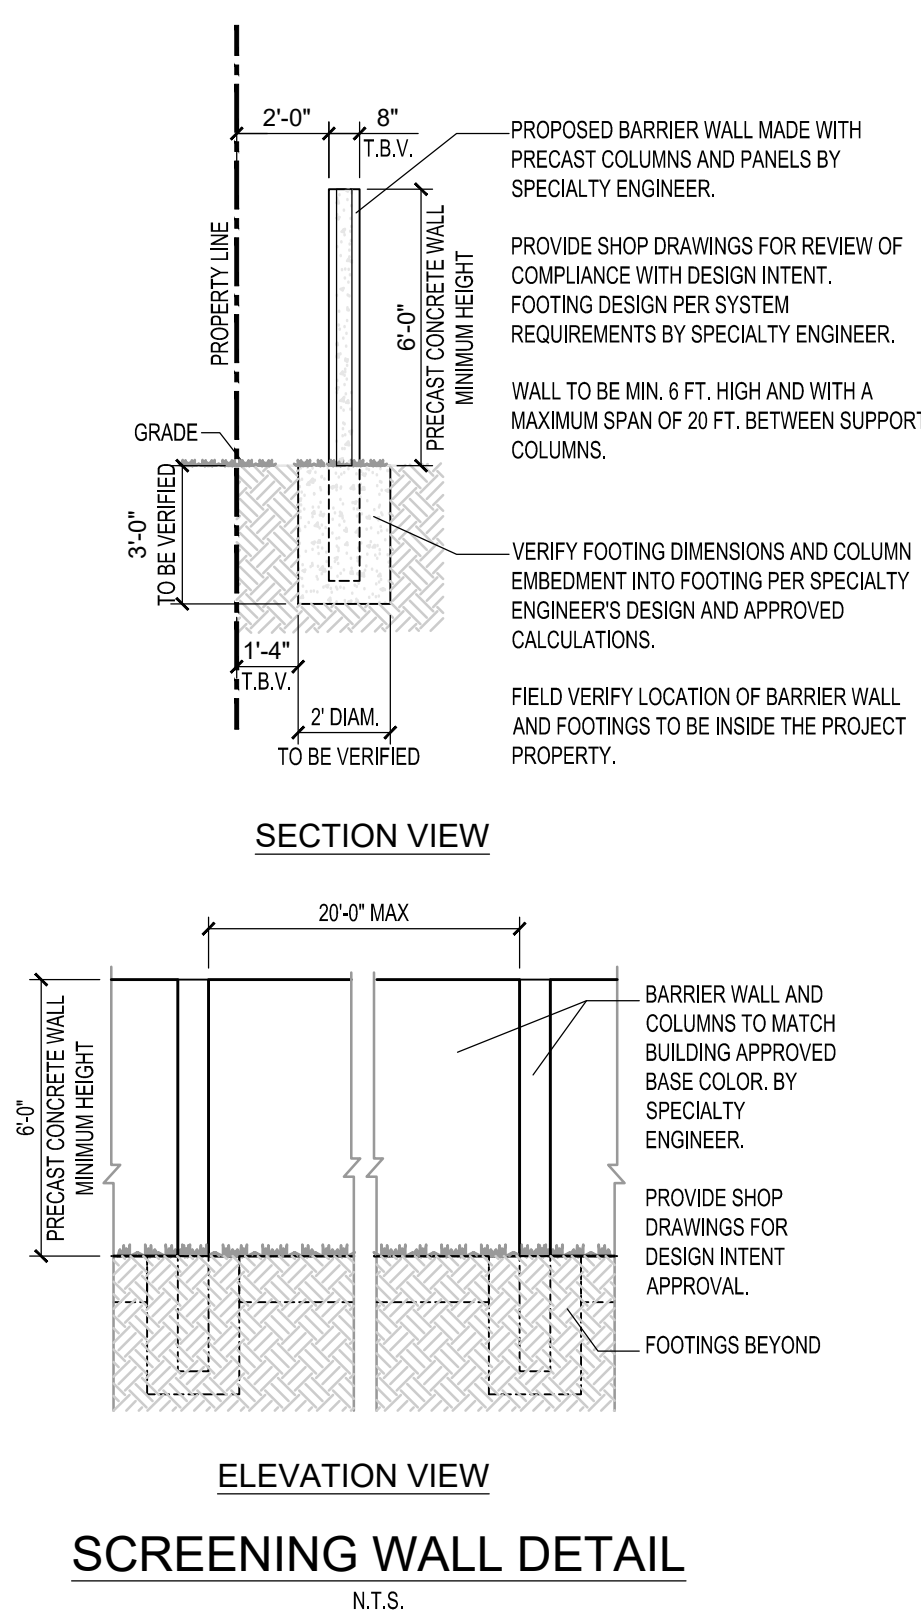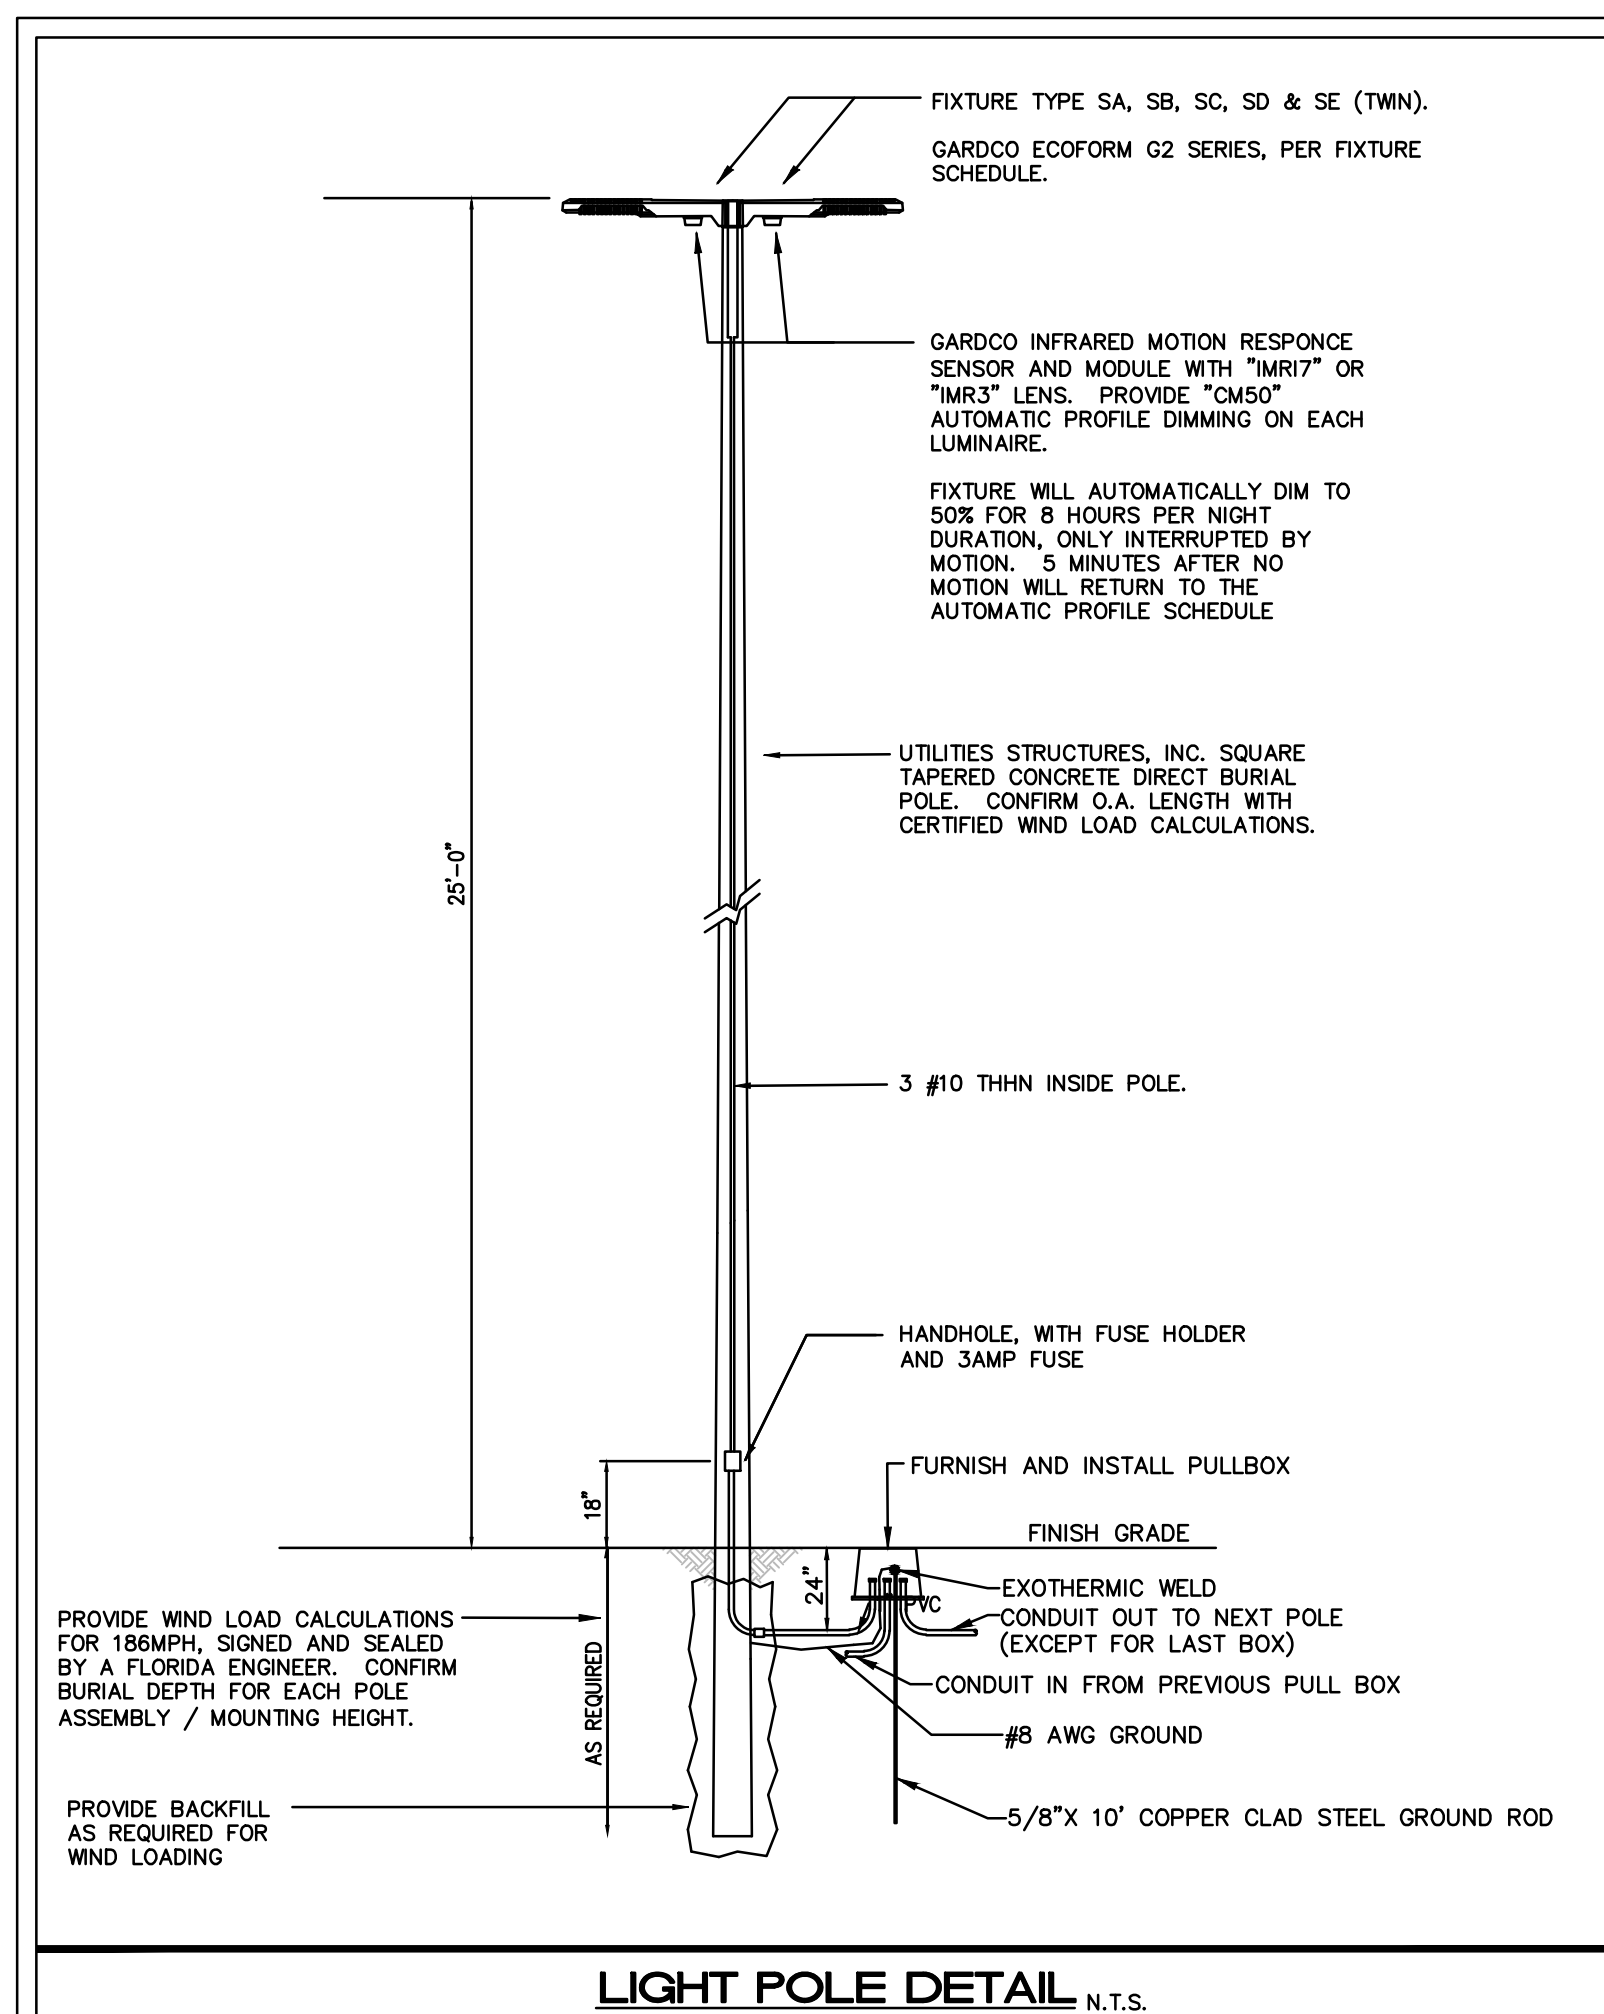

1	2025.05.21	REVISIONS TO ADDRESS CITY OF LUCIE, P & Z COMMENTS 2025-05-19	RAH	JRH
REV.	DATE	DESCRIPTION	BY	CHK.
DRAWING ISSUE STATUS				
<div><div><div></div><div></div><div></div></div><div>FOR PERMIT</div></div>				
<div><div><div>HALEY WARD ENGINEERING ENVIRONMENTAL SURVEYING LAND PLANNING INTERIOR DESIGN 10250 Village Parkway, Suite 201 Port Saint Lucie, Florida 34987 772.462.2455</div></div><div>WWW.HALEYWARD.COM</div></div>				
PROJECT				
<div><div>FOUR PORT ST. LUCIE, LLC</div><div>CITY OF PORT ST. LUCIE, FLORIDA</div></div>				
TITLE				
<div><div>SITE PLAN DETAILS</div></div>				
	DATE		SCALE	
	JAN. 2025		AS NOTED	
	DRAWN BY	DESIGNED BY	CHECKED BY	
	RAH	SGF	JRH	
	PROJECT No.			
	24-169 SITE PLAN.DWG			
DRAWING No.			REV.	
3 OF 3			1	