

SHEET LIST

COVER

SURVEY

CIVIL

LANDSCAPE

ARCHITECTURAL

STRUCTURAL

COVER

GENERAL NOTES

GENERAL NOTES

SITE DEMOLITION & EROSION CONTROL PLAN SWPPP

STORMWATER POLLUTION PREVENTION PLAN

SIGNING, STRIPING & GEOMETRIC PLAN

PAVING, GRADING & DRAINAGE PLAN

PAVING, GRADING & DRAINAGE DETAILS

PAVING, GRADING & DRAINAGE DETAILS

POTABLE WATER AND SANITARY SEWER PLAN

POTABLE WATER AND SANITARY SEWER DETAILS

POTABLE WATER AND SANITARY SEWER DETAILS

SEWER PROFILE

LANDSCAPE PLAN

LANDSCAPE DETAILS

SITE PLAN AND SITE DATA

LIFE SAFETY PLAN

FLOOR PLAN

REFLECTED CEILING PLAN

ROOF PLAN

EXTERIOR ELEVATIONS

EXTERIOR ELEVATIONS

SECTIONS

WALL SECTIONS

WALL SECTIONS

DETAILS

WALL TYPES

ROOF DETAILS

INTERIOR ELEVATIONS

SCHEDULES , DOOR TYPES, WINDOW TYPES

DOOR AND WINDOW DETAILS

GROUND FLOOR PLAN

ROOF FRAMING PLAN

NOTES

WINDOW LOADS

DETAILS

DETAILS

DETAILS

ELECTRICAL

PLUMBING

FIRE PROTECTION

MECHANICAL

LEGEND, FIXTURE SCHEDULE AND GENERAL NOTES

ELECTRICAL SITE PLAN

LIGHTING FLOOR PLAN

LIGHTING FLOOR PLAN - PHOTOMETRIC

POWER FLOOR PLAN

SYSTEMS FLOOR PLAN

ENLARGED KITCHEN AND ELECTRICAL ROOM PLAN

LIGHTNING PROTECTION PLAN

ONE-LINE AND SYSTEM RISERS

LIGHTING CONTROLS

PANEL SCHEDULES

ELECTRICAL DETAILS

ELECTRICAL DETAILS

GENERAL NOTES AND SCHEDULES

PLUMBING SITE PLAN

SANITARY, VENT, & STORM DRAIN FLOOR PLAN

DOMESTIC WATER & FUEL GAS FLOOR PLAN

PLUMBING ROOF PLAN

SANITARY WASTE RISER DIAGRAM

DOMESTIC WATER RISER DIAGRAM

FUEL GAS RISER DIAGRAM

PLUMBING DETAILS

PLUMBING DETAILS

LEGEND AND GENERAL NOTES

FIRE PROTECTION SITE PLAN

FIRE PROTECTION FLOOR PLAN

FIRE PROTECTION DETAILS

FIRE PROTECTION DETAILS

LEGEND AND GENERAL NOTES

MECHANICAL SCHEDULES

MECHANICAL SCHEDULES

MECHANICAL VENTILATION CALCULATIONS

HVAC FLOOR PLANS

PIPING FLOOR PLANS

ENLARGED MECHANICAL ROOM PLAN

ENLARGED CHILLER YARD PLAN

CHW PIPING SCHEMATIC

MECHANICAL DETAILS

MECHANICAL DETAILS

MECHANICAL DETAILS

MECHANICAL DETAILS

MECHANICAL CONTROLS

MECHANICAL CONTROLS

MECHANICAL CONTROLS

MECHANICAL CONTROLS

MECHANICAL CONTROLS

MECHANICAL CONTROLS

MECHANICAL CONTROLS

ST ELIZABETH ANN SETON
CATHOLIC CHURCH

NEW PARISH HALL BUILDING

DIOCESE OF PALM BEACH

Bishop Gerald M. Barbarito, D.D., J.C.L.
Bishop of Palm Beach



100% CONSTRUCTION DOCUMENTS

ARCHITECT

COLOMÉ & ASSOCIATES, INC.

CIVIL ENGINEER

CIVIL DESIGN, INC.

LANDSCAPE ARCHITECT

2GHO LANDSCAPE ARCHITECTS, PLANNERS, ENVIRONMENTAL
CONSULTANTS

STRUCTURAL ENGINEER

O'DONNELL, NACCARATO, MIGNOGNA & JACKSON, INC.


MEP+FP ENGINEER

JOHNSON, LEVINSON, RAGAN & DAVILA

SURVEYOR

BROWN & PHILLIPS, INC.


11-144-00A / P22-120

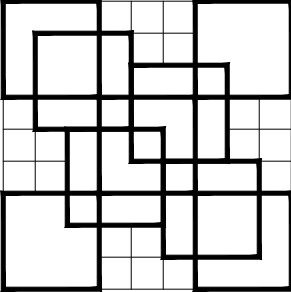

COLOME'
& Associates, Inc.
AA 0003439
530 24TH STREET
WEST PALM BEACH
FLORIDA 33407
(561) 833-9147
Architect: ELIZABETH A. G. COLOME'
REG. NUMBER: AR_0014839



Printed copies of this
document are not
considered signed and
sealed and the signature
must be verified on any
electronic copies

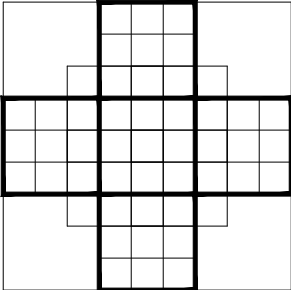


St. Elizabeth
Ann Seton


New Parish Hall
Building

930 SW Tunis Ave

PORT ST. LUCIE
FLORIDA

 PROJECT NO.
202053



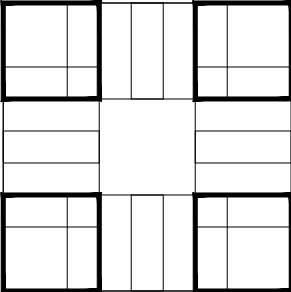

SHEET TITLE:

COVER

REVISIONS:

DATE
2-15-24
DRAWN BY:
EAC
CHECKED BY:
EAC

SHEET
NUMBER:


COVER

COLOME' & ASSOCIATES, INC. RESERVES COPYRIGHT & OTHER RIGHTS RESTRICTING THESE DOCUMENTS TO THE ORIGINAL PURPOSE FOR WHICH THEY WERE PREPARED. REPRODUCTIONS, CHANGES OR ASSIGNMENTS ARE PROHIBITED. COPYRIGHT © COLOME' & ASSOCIATES, INC.


SITE DATA	ACRES	SF	PERCENTAGE %
BUILDING COVERAGE	0.65	26,206 SF	5%
PAVEMENT & SIDEWALKS	2.3	102,282 SF	18%
TOTAL IMPERVIOUS AREA	2.95	128,488 SF	23%
OPEN SPACE	6.73	423,679 SF	76%
DRY DETENTION AREA	0.13	5,680 SF	1%
TOTAL PERVIOUS AREA	6.86	429,359 SF	77%
GROSS SITE AREA	12.76	555,651 SF	100%

SITE DATA:	REQUIRED	EXISTING	PROPOSED
ZONING	I - INSTITUTIONAL	I - INSTITUTIONAL	I - INSTITUTIONAL
LAND USE	I - INSTITUTIONAL	I - INSTITUTIONAL	I - INSTITUTIONAL
SITE EX. PLAN SF			
SITE ACRES			
MINIMUM WIDTH	100 FT	734.43 FT	NO CHANGE
FRONT SETBACK	25 FT	105 FT	204.17 FT (PARISH CENTER)
REAR SETBACK	25 FT	251.60 FT	115.7 FT (PARISH CENTER)
SIDE SETBACKS	WEST 10 FT	440.75 FT	636.25 FT (PARISH CENTER)
	EAST 25 FT ADJACENT TO PUBLIC ROW OR RESIDENTIAL	278 FT	369 FT (PARISH CENTER)
MAX BUILDING COVERAGE	30% OR 140,542 SF		26,206 SF
MAX IMPERVIOUS AREAS	30% OR 374,778 SF		
MAX BUILDING HEIGHT	35 FT		21'7" MEAN HT OF HIGHEST ROOF
PARKING - EXISTING TOTAL	144 SPACES PROVIDED		
PARKING STANDARD	144 SPACES		
PARKING ACCESSIBLE	9 SPACES		
PARKING GRASS	40 SPACES		
TOTAL PARKING	193 SPACES		
THIS PROJECT IS A NEW PARISH CENTER ON THE SITE OF THE EXISTING ST. ELIZABETH ANN SETON CATHOLIC CHURCH		26,206 / 200 = 131.03 SPACES REQUIRED	
BUILDING DATA - PROPOSED PARISH CENTER UNDER AIR	13,226 SF		
BUILDING DATA - EXISTING CHURCH TOTAL GSF	12,980 SF		
TOTAL GSF	26,206 SF		
PROJECT SCHEDULE: PARISH CENTER CONSTRUCTION WILL BEGIN SPRING 2023 AND TAKE APPROXIMATELY 9 MONTHS.			
THE DEMOLITION OF THE EXISTING MODULAR UNITS WILL BE A PART OF THE PARISH CENTER PROJECT			
THE FUTURE ADDITION TO THE CHURCH WILL BEGIN 2 YEARS AFTER THE COMPLETION OF THE PARISH CENTER PROJECT.			



DESCRIPTION	FOUND	AGENCY CONTRACT INFO	MANAGEMENT PLAN	RELOCATION PLAN
WETLANDS	YES	-	OUTSIDE OF WORK AREA	NO
RARE HABITAT	NO	-	-	-
THREATENED SPECIES	YES	-	OUTSIDE OF WORK AREA	NO
ENDANGERED SPECIES	NO	-	-	-
SPECIES OF SPECIAL CONCERN	NO	-	-	-
INVASIVE/EXOTIC VEGETATION	YES	-	TO BE REMOVED	-

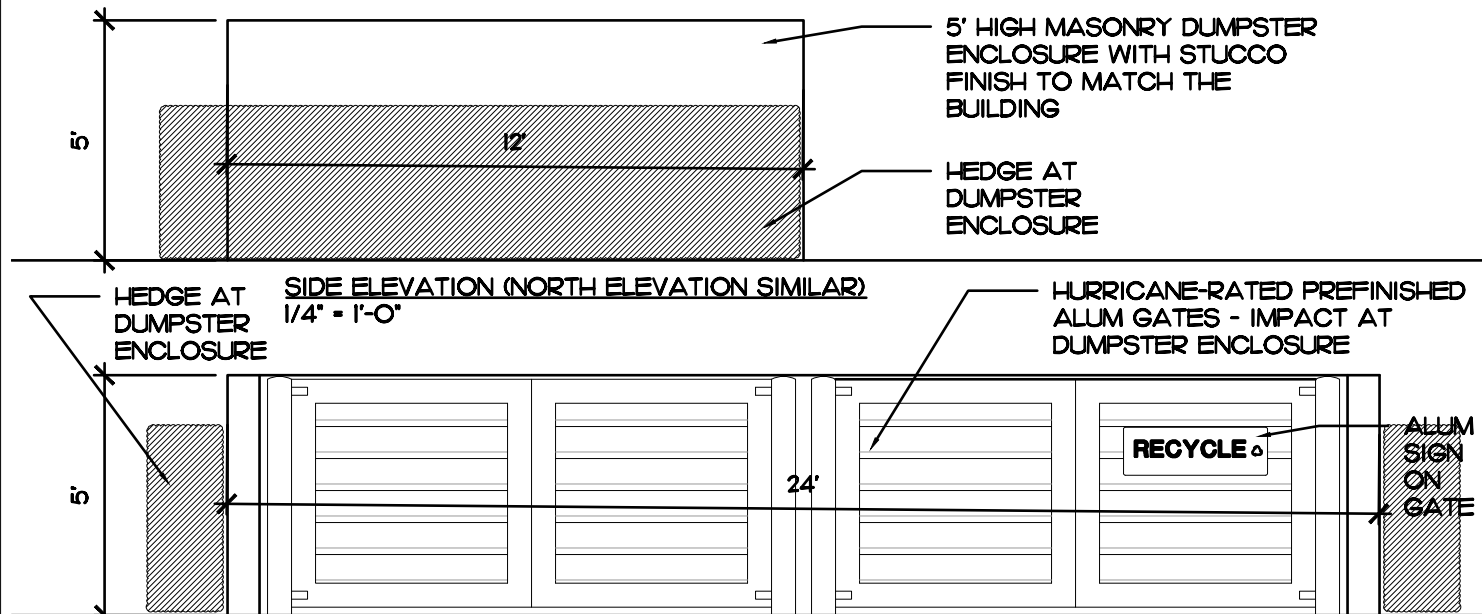

DUMPSTER DETAILS

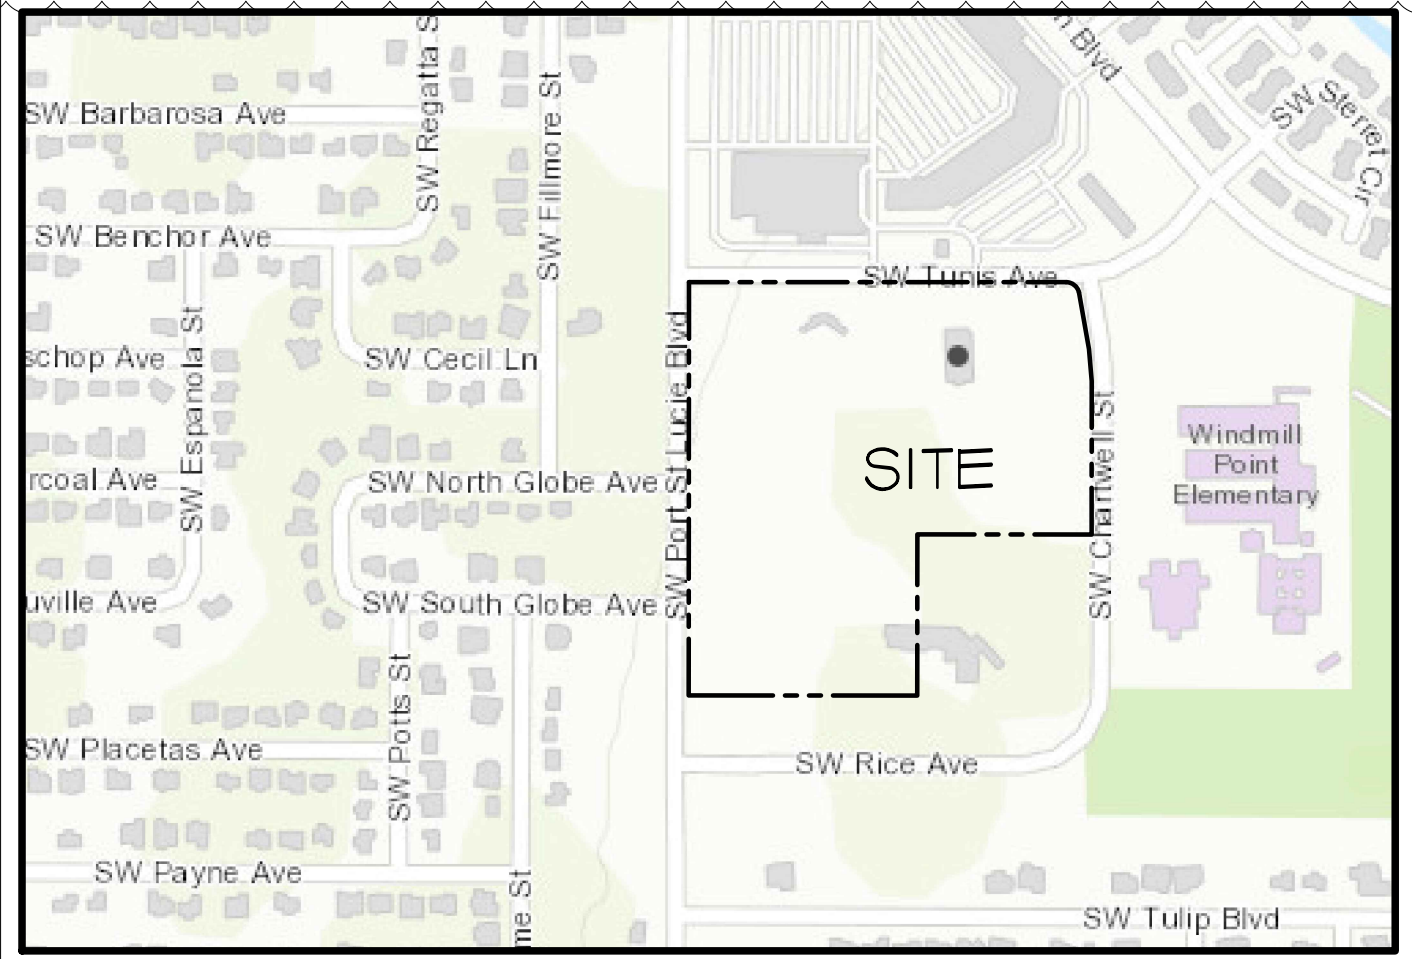

LOCATION MAP

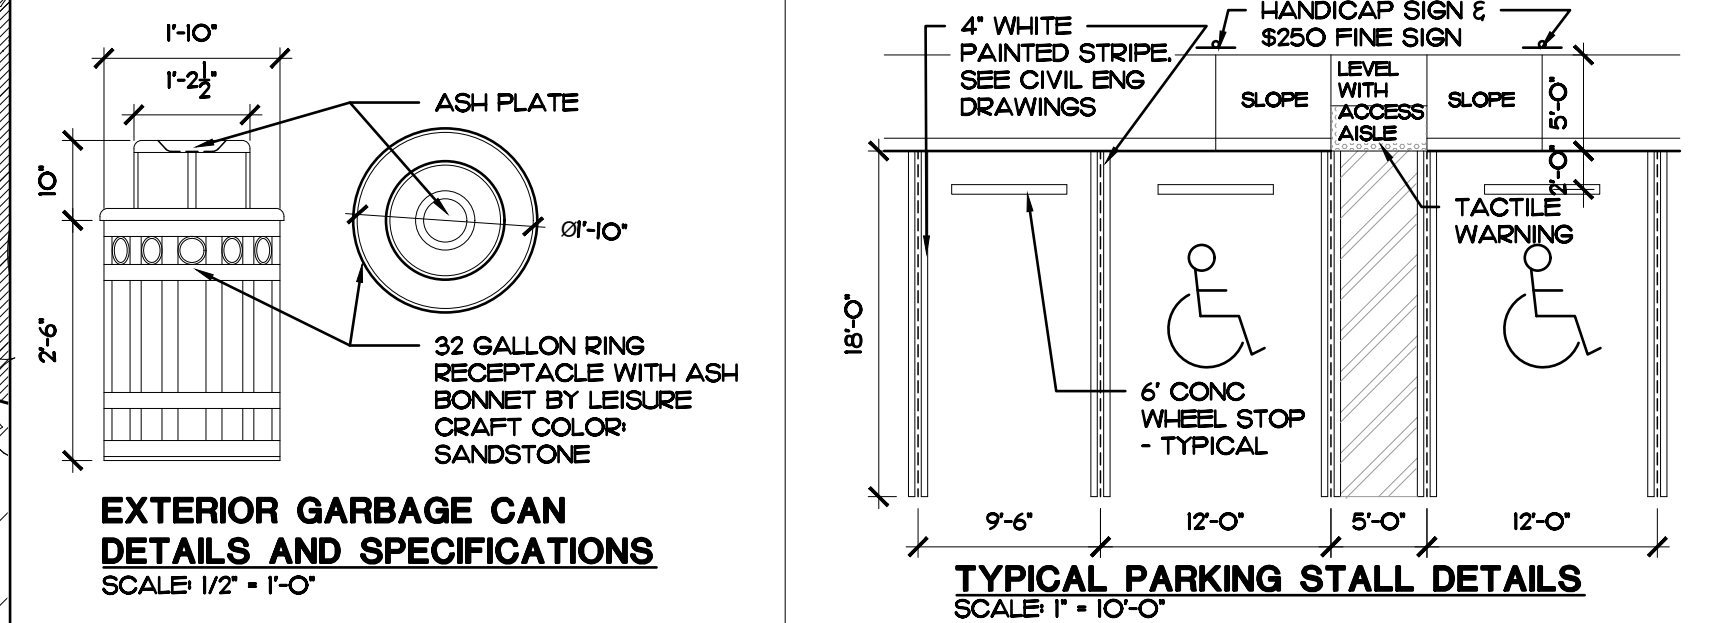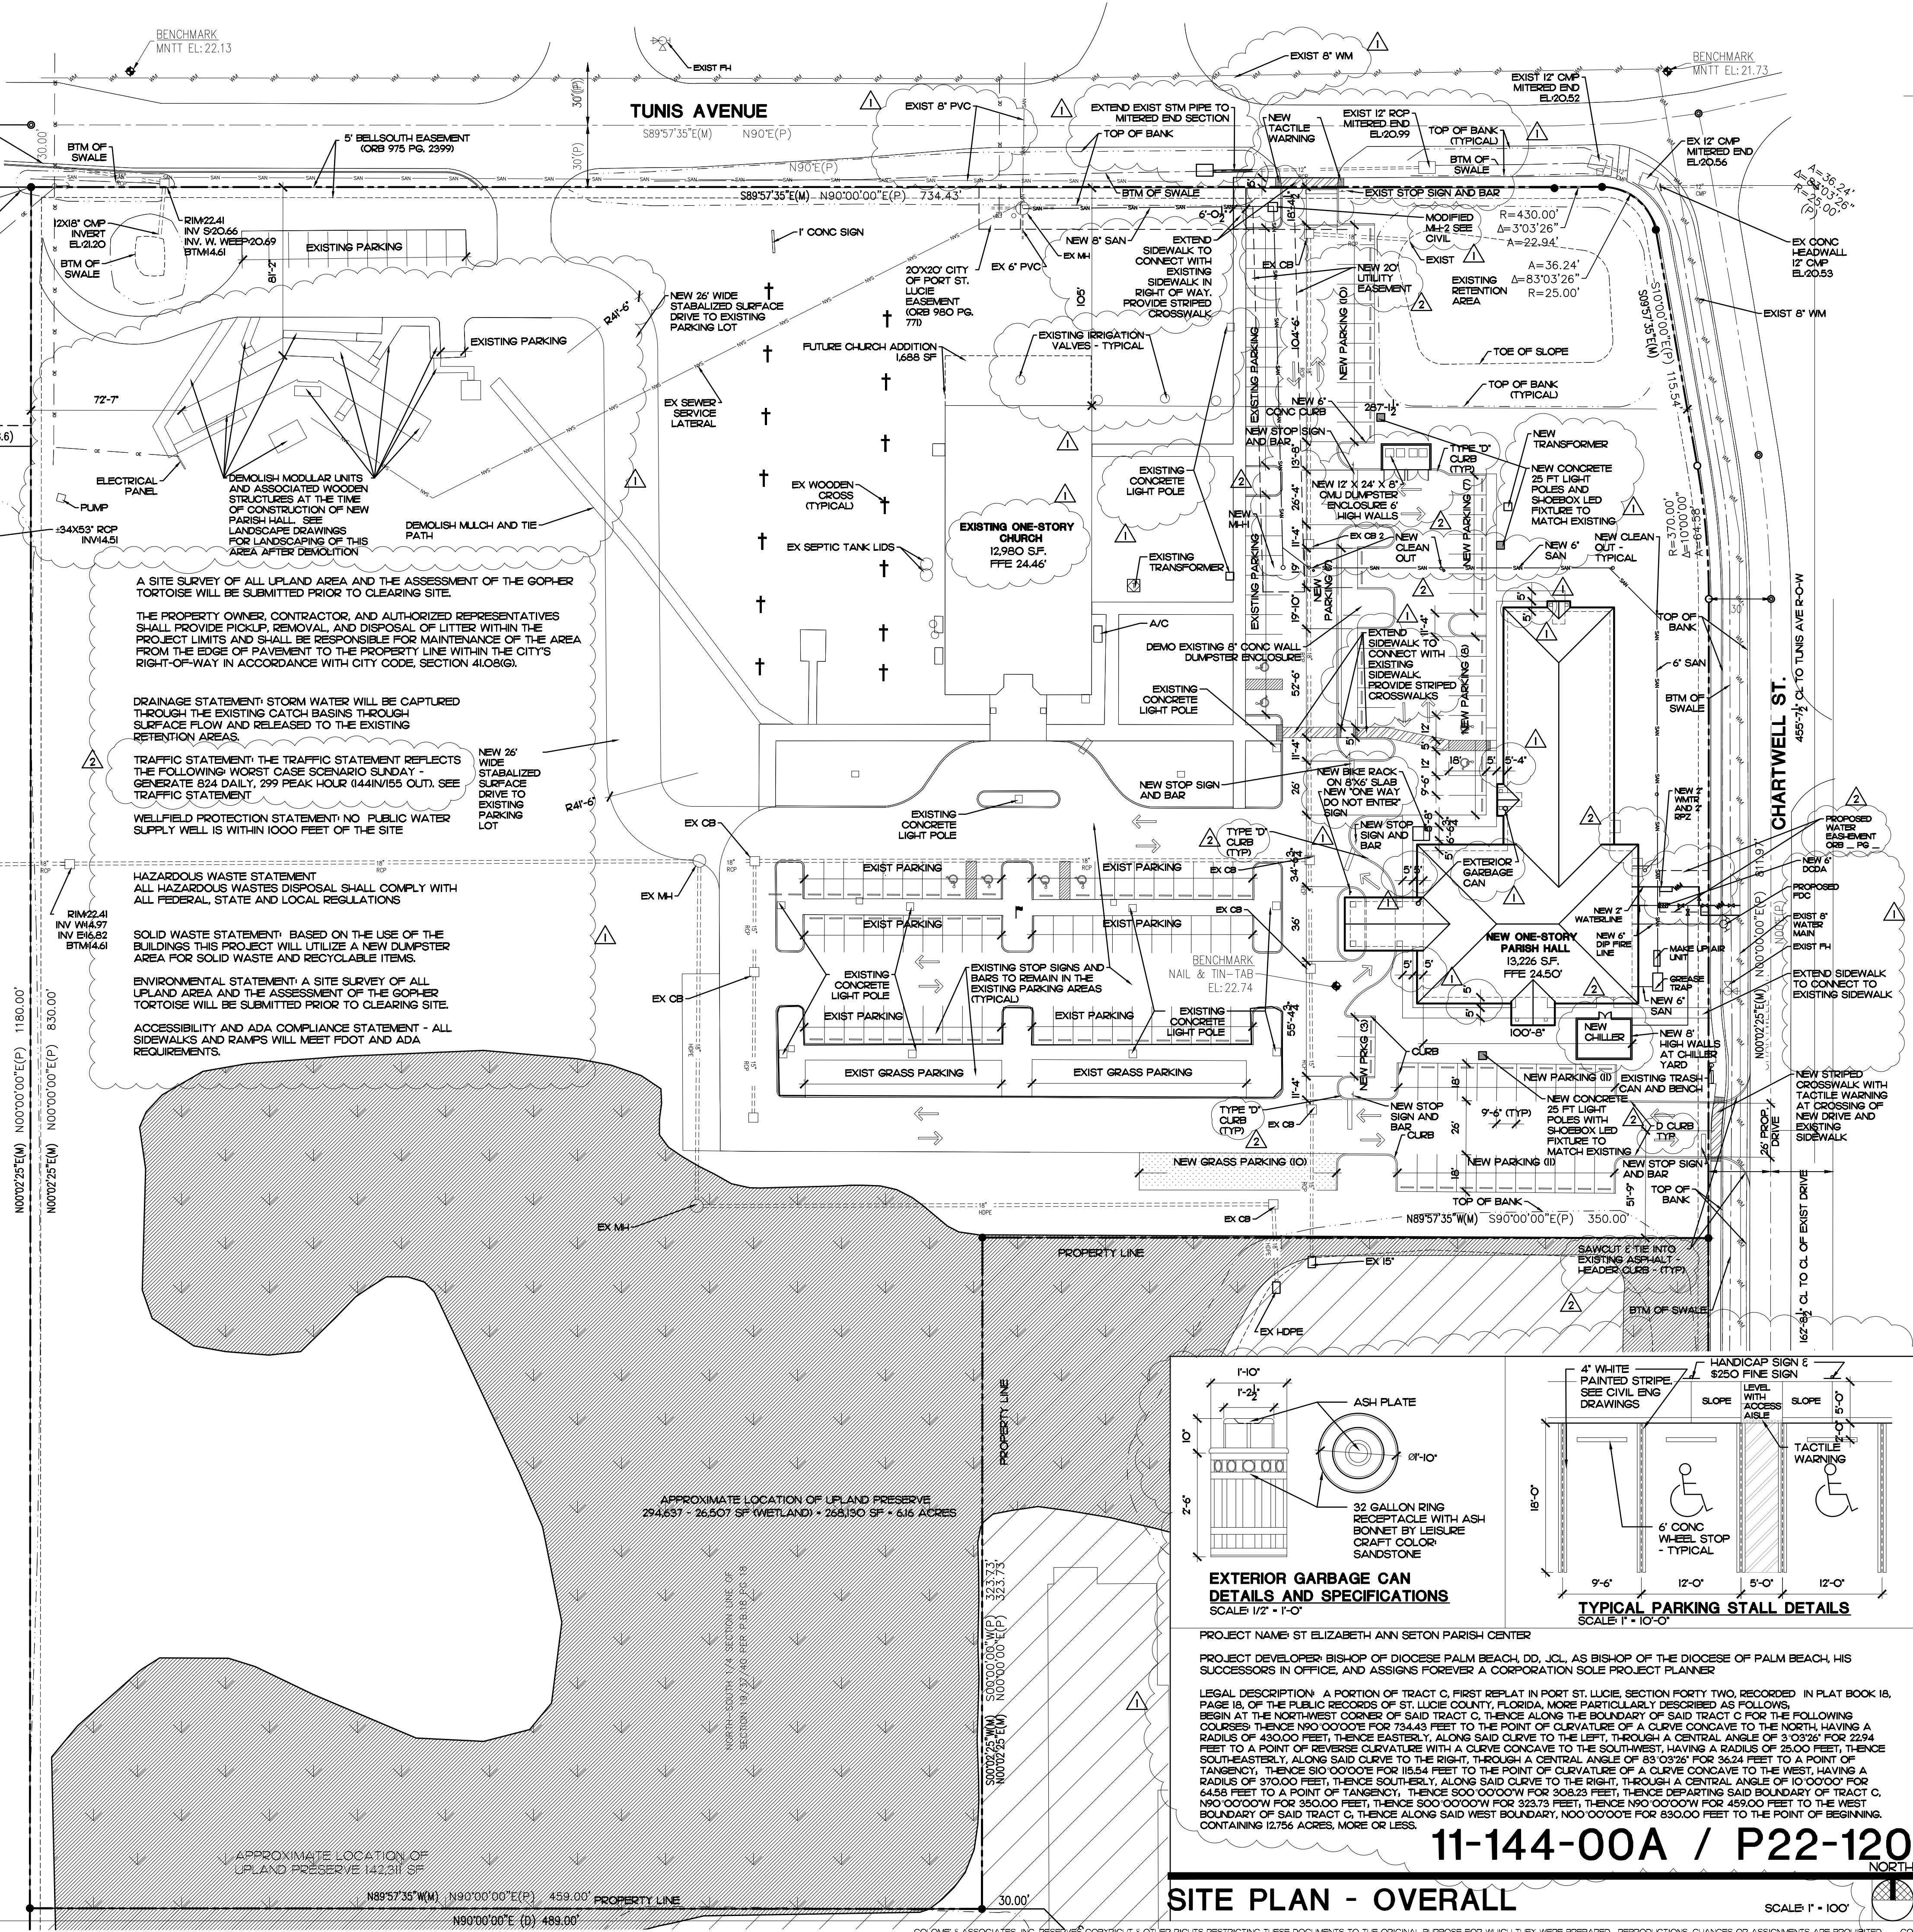

EXTERIOR GARBAGE CAN DETAILS AND SPECIFICATIONS
SCALE 1/2" = 1'-0"

TYPICAL PARKING STALL DETAILS
SCALE 1" = 10'-0"


PROJECT NAME: ST. ELIZABETH ANN SETON PARISH CENTER

PROJECT DEVELOPER: BISHOP OF DIOCESE PALM BEACH, DO, JCL, AS BISHOP OF THE DIOCESE OF PALM BEACH, HIS SUCCESSORS IN OFFICE, AND ASSIGNS FOREVER A CORPORATION SOLE PROJECT PLANNER

LEGAL DESCRIPTION: A PORTION OF TRACT C, FIRST REPLAT IN PORT ST. LUCIE, SECTION FORTY TWO, RECORDED IN PLAT BOOK 18, PAGE 18, OF THE PUBLIC RECORDS OF ST. LUCIE COUNTY, FLORIDA, MORE PARTICULARLY DESCRIBED AS FOLLOWS: BEGIN AT THE NORTHWEST CORNER OF SAID TRACT C, THENCE ALONG THE BOUNDARY OF SAID TRACT C FOR THE FOLLOWING COURSES: THENCE N90°00'00"E FOR 734.43 FEET TO THE POINT OF CURVATURE OF A CURVE CONCAVE TO THE NORTH, HAVING A RADIUS OF 430.00 FEET, THENCE EASTERLY, ALONG SAID CURVE TO THE LEFT, THROUGH A CENTRAL ANGLE OF 3°03'26" FOR 22.94 FEET TO A POINT OF CURVATURE TO THE SOUTHWEST, HAVING A RADIUS OF 25.00 FEET, THENCE SOUTHWESTERLY, ALONG SAID CURVE TO THE RIGHT, THROUGH A CENTRAL ANGLE OF 83°03'26" FOR 36.24 FEET TO A POINT OF TANGENCY, THENCE S10°00'00"E FOR 115.54 FEET TO THE POINT OF CURVATURE OF A CURVE CONCAVE TO THE WEST, HAVING A RADIUS OF 370.00 FEET, THENCE SOUTHWESTERLY, ALONG SAID CURVE TO THE RIGHT, THROUGH A CENTRAL ANGLE OF 10°00'00" FOR 64.53 FEET TO A POINT OF CURVATURE TO THE SOUTHWEST, THENCE S80°00'00"W FOR 323.73 FEET, THENCE DEPARTING SAID BOUNDARY OF TRACT C, N90°00'00"W FOR 350.00 FEET, THENCE S00°00'00"W FOR 323.73 FEET, THENCE N90°00'00"W FOR 459.00 FEET TO THE WEST BOUNDARY OF SAID TRACT C, THENCE ALONG SAID WEST BOUNDARY, N00°00'00"E FOR 830.00 FEET TO THE POINT OF BEGINNING, CONTAINING 12.756 ACRES, MORE OR LESS.

11-144-00A / P22-120


SITE PLAN - OVERALL
SCALE 1" = 100'

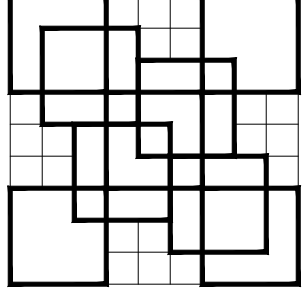

COLOME & Associates, Inc.
AA 0003439
530 24TH STREET
WEST PALM BEACH
FLORIDA 33407
(561) 833-9147
Architect: ELIZABETH A. G. COLOME
REG. NUMBER: AR 0014839



Printed copies of this document are not considered signed and sealed and the signature must be verified on any electronic copies

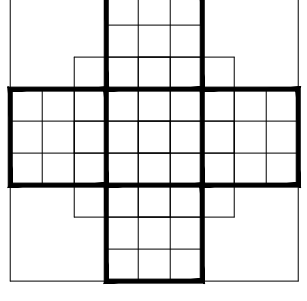



St. Elizabeth Ann Seton

New Parish Hall Building

930 SW Tunis Ave

PORT ST. LUCIE, FLORIDA

 PROJECT NO. 202053

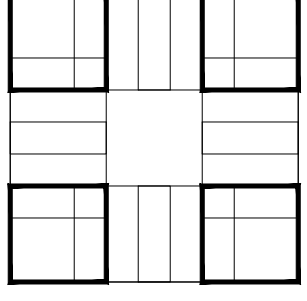

SHEET TITLE:
SITE PLAN AND SITE DATA


REVISIONS:
1 1/13/22 COMMENTS
2 4/15/24 COMMENTS

DATE
2-15-2024

DRAWN BY:
HDM

CHECKED BY:
EAC


SHEET NUMBER:
SP-1

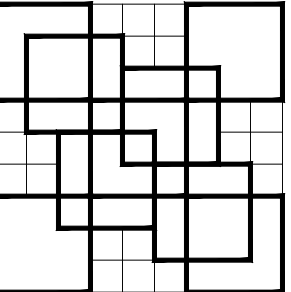

COLOME
& Associates, Inc.
AA 0003439
530 24TH STREET
WEST PALM BEACH
FLORIDA 33407
(561) 833-9147
Architect: ELIZABETH A. S. COLOME
REG. NUMBER: AR 0014839



Printed copies of this document are not considered signed and sealed and the signature must be verified on any electronic copies

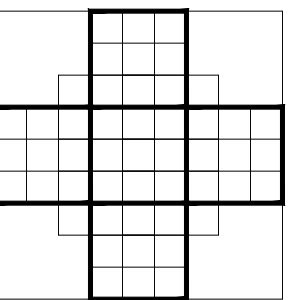



**St. Elizabeth
Ann Seton**

New Parish Hall Building

930 SW Tunis Ave

PORT ST. LUCIE
FLORIDA

 PROJECT NO.
202053

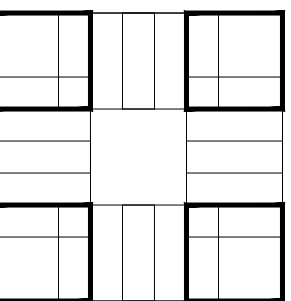

SHEET TITLE:
LIFE SAFETY PL
REV.1
7-13-22 COMMENTS SPRC

REVISIONS


DATE
2-15-24

DRAWN BY:
EAC

CHECKED BY:
EAC

SHEET
NUMBER:

LS-1

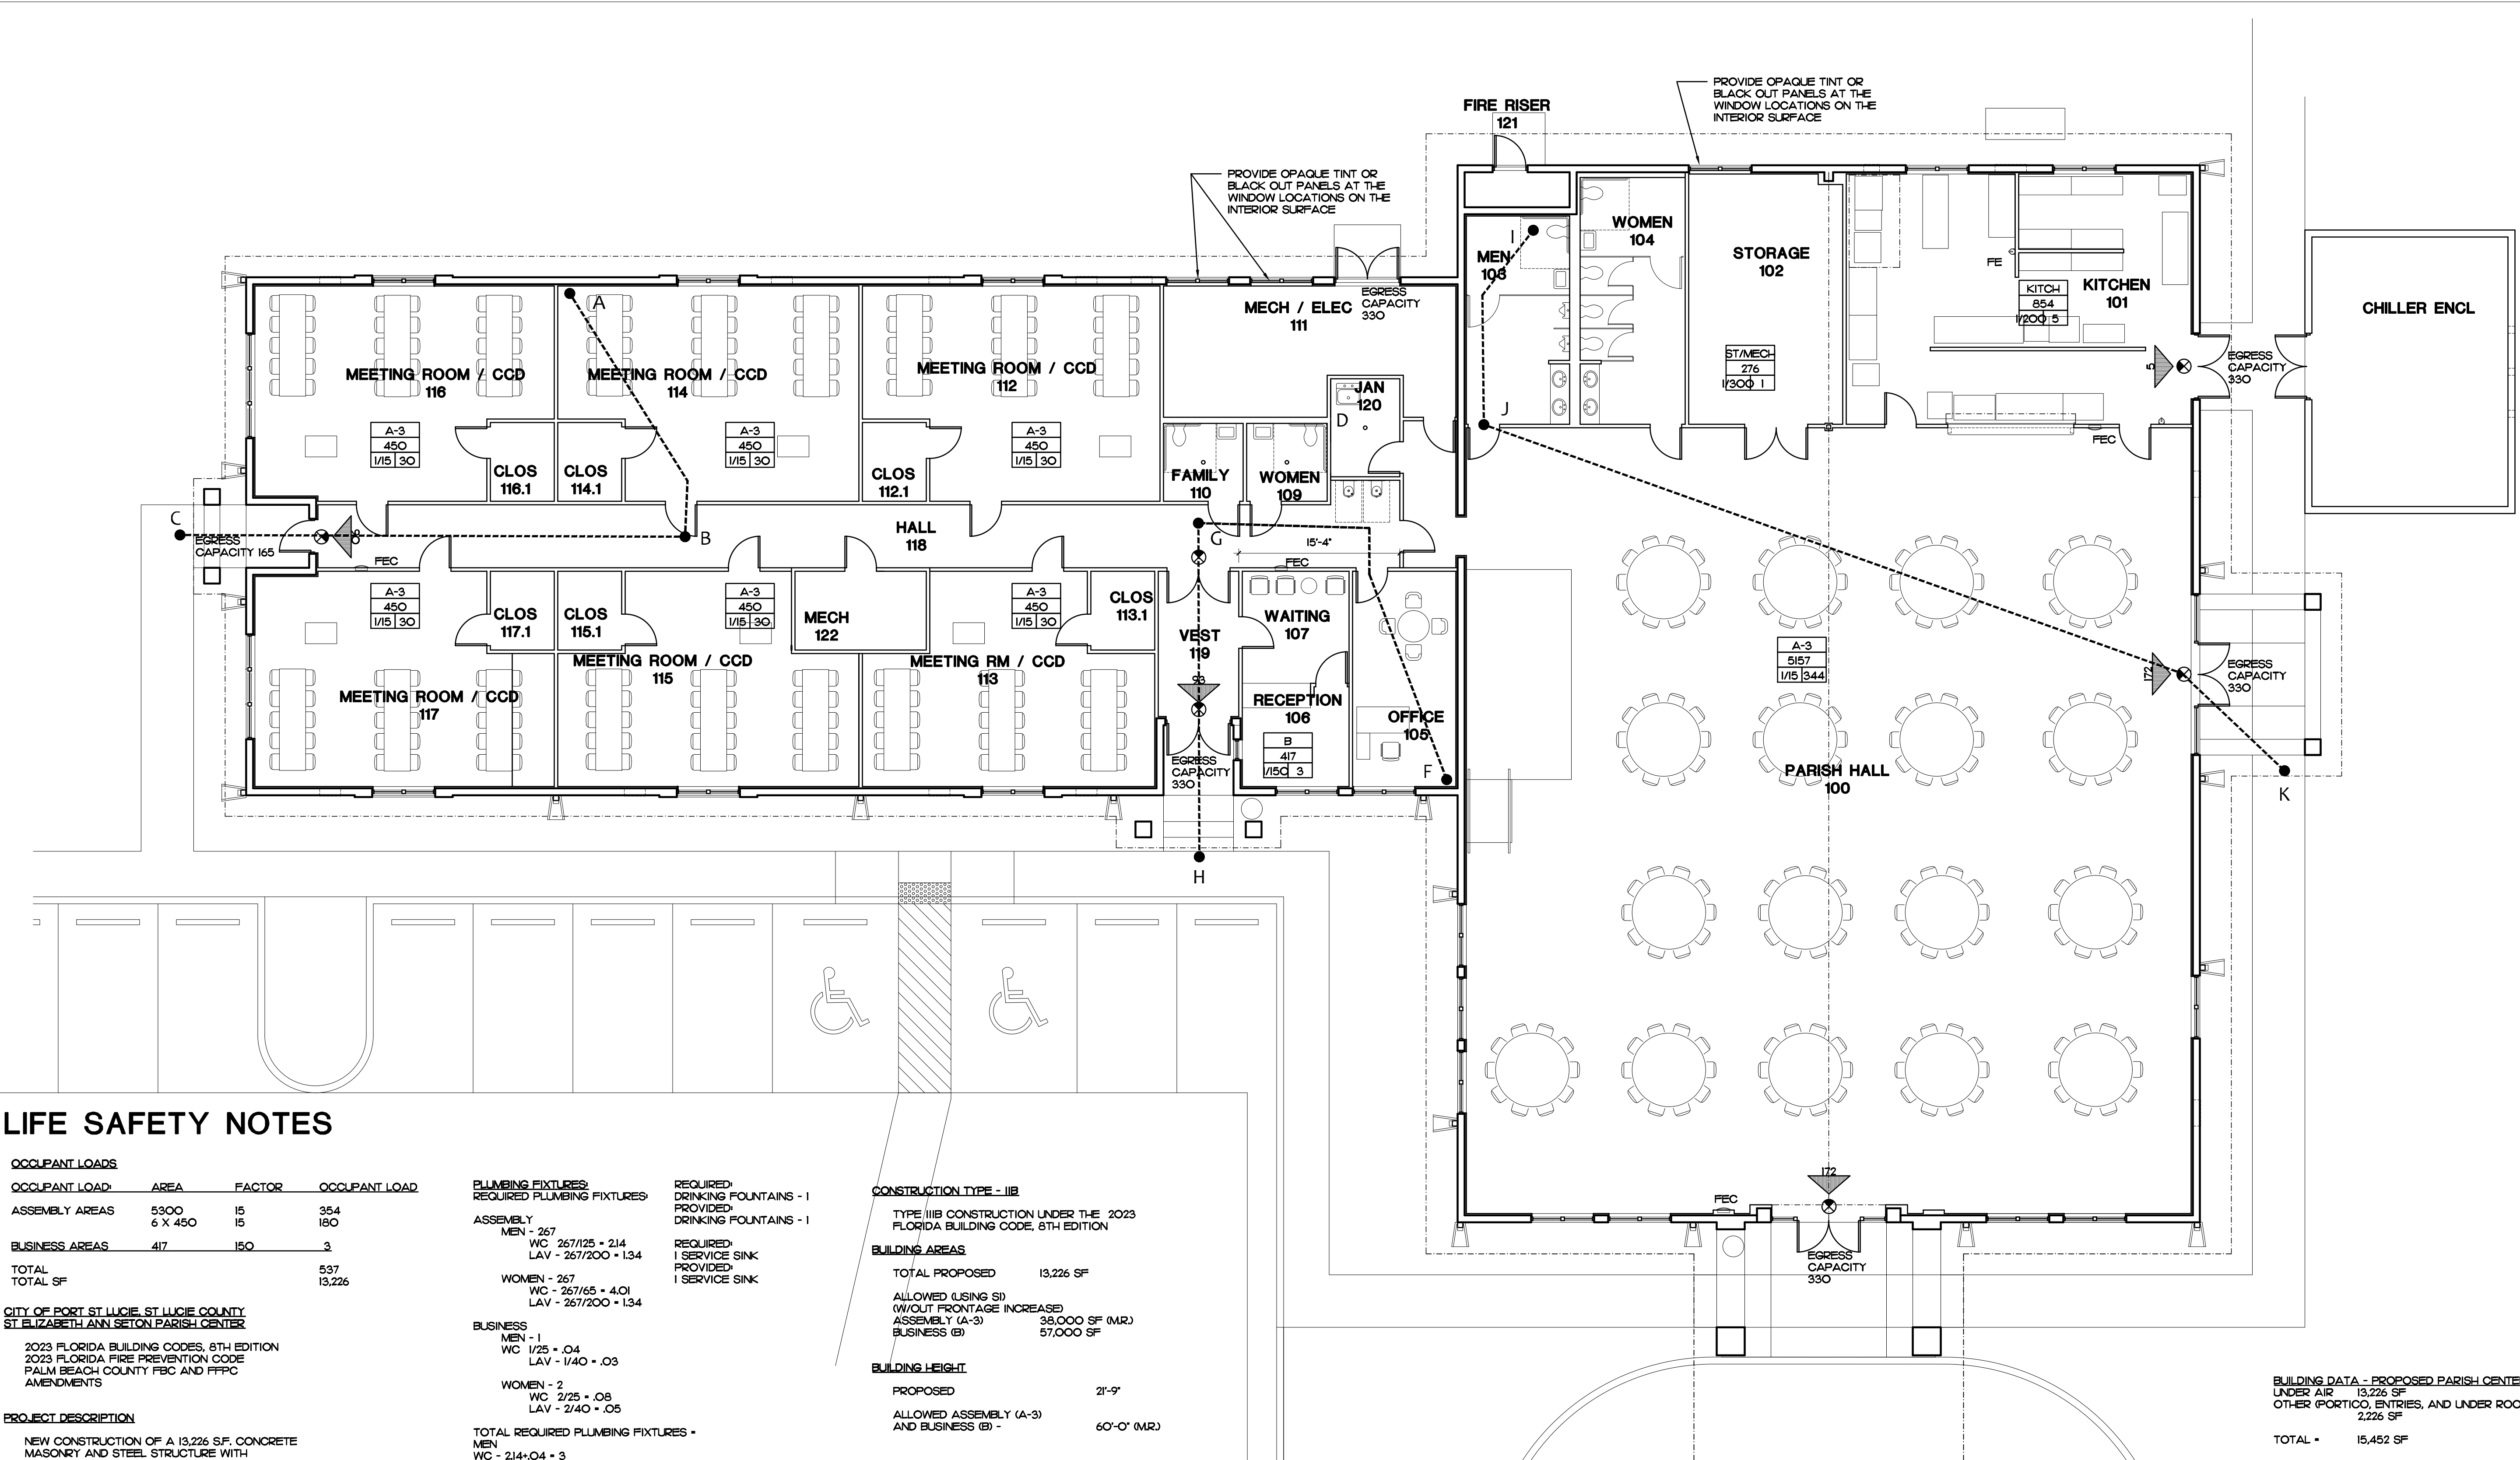

LIFE SAFETY NOTES

OCCUPANT LOADS

OCCUPANT LOAD	AREA	FACTOR	OCCUPANT LOAD
ASSEMBLY AREAS	5300 6 X 450	15	354 180
BUSINESS AREAS	417	150	3
TOTAL TOTAL SF			537 13,226

CITY OF PORT ST. LUCIE, ST. LUCIE COUNTY,
ST. ELIZABETH ANN SETON PARISH CENTER

2023 FLORIDA BUILDING CODES, 8TH EDITION
2023 FLORIDA FIRE PREVENTION CODE
PALM BEACH COUNTY FBC AND FFPC
AMENDMENTS

PROJECT DESCRIPTION

NEW CONSTRUCTION OF A 13,226 SF. CONCRETE
MASONRY AND STEEL STRUCTURE WITH
ASSEMBLY AND BUSINESS OCCUPANCIES.

FIRE SPRINKLERS

BUILDING IS WILL BE EQUIPPED WITH A FULLY
AUTOMATIC FIRE SPRINKLER SYSTEM IN
ACCORDANCE WITH NFPA 13 2022 ED

OCCUPANCY CLASSIFICATION

FBC/A-3 MIXED NON-SEPARATED - BUSINESS
GROUP B AND A-3 (HALL)
FFPC MULTIPLE MIXED - NEW ASSEMBLY AND
NEW BUSINESS OCCUPANCY

PLUMBING FIXTURES REQUIRED PLUMBING FIXTURES

ASSEMBLY
MEN - 267
WC - 267/125 = 2.14
LAV - 267/200 = 1.34

WOMEN - 267
WC - 267/65 = 4.01
LAV - 267/200 = 1.34

BUSINESS
MEN - 1
WC 1/25 = .04
LAV - 1/40 = .03

WOMEN - 2
WC 2/25 = .08
LAV - 2/40 = .05

TOTAL REQUIRED PLUMBING FIXTURES -
MEN
WC - 2.14+.04 = 3
LAV - 1.34+.03 = 2

WOMEN - 4.01+.08 = 4
LAV - 1.34+.05 = 2

PROVIDED PLUMBING FIXTURES
MEN
WC - 3
LAV - 3

WOMEN - 5
WC - 5
LAV - 4

FAMILY
WC - 1
LAV - 1

REQUIRED DRINKING FOUNTAINS - 1 PROVIDED DRINKING FOUNTAINS - 1

REQUIRED
1 SERVICE SINK
PROVIDED
1 SERVICE SINK

CONSTRUCTION TYPE - IIB

TYPE IIIB CONSTRUCTION UNDER THE 2023
FLORIDA BUILDING CODE, 8TH EDITION

BUILDING AREAS

TOTAL PROPOSED 13,226 SF

ALLOWED (USING S1)
(W/O OUT FRONTAGE INCREASE)
ASSEMBLY (A-3) 38,000 SF (MR)
BUSINESS (B) 57,000 SF

BUILDING HEIGHT

PROPOSED 21'-9"


ALLOWED ASSEMBLY (A-3)
AND BUSINESS (B) - 60'-0" (MR)

COMMON PATH OF TRAVEL

ALLOWED
ASSEMBLY (A-3) OR BUSINESS (B) 75'

PROPOSED A TO B

LEGEND

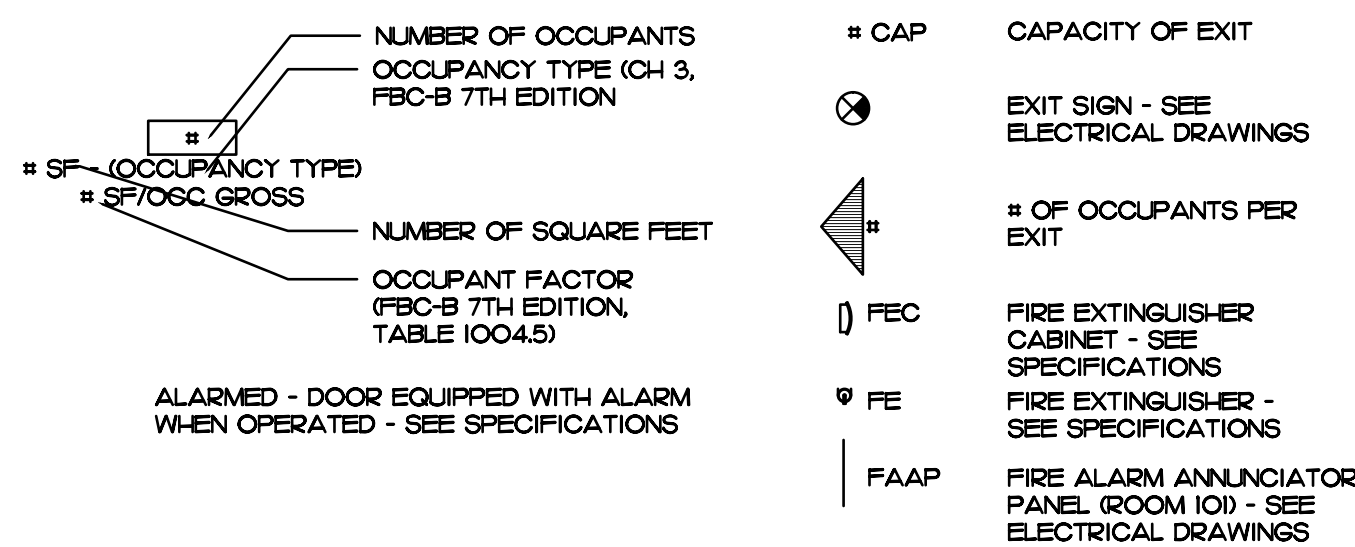

NOTES

KNOX BOX - CONTRACTOR IS RESPONSIBLE
FOR COORDINATING THE QUANTITY AND
LOCATION OF THE KNOX BOXES) WITH THE
CITY OF PORT ST. LUCIE FIRE RESCUE
DEPARTMENT

PER THE FPC 2020, CHAPTER 69A-60, THE
CONTRACTOR SHALL PROVIDE REQUIRED
SIGNAGE IDENTIFYING THE METAL TRUSS
SYSTEM



CONTRACTOR SHALL PROVIDE BUILDING
IDENTIFICATION ADDRESS SIMILAR TO
LETTERING AT THE BUILDING IDENTIFICATION
"SMALL SIGN" FOR THE ADDRESS NUMBER AND
TO VERIFY QUANTITY AND LOCATION PRIOR
TO INSTALLATION

REFER TO MEP DRAWINGS FOR ADDITIONAL
LIFE SAFETY REQUIREMENTS

LIFE SAFETY PLAN

SCALE: 1/8" = 1'-0"




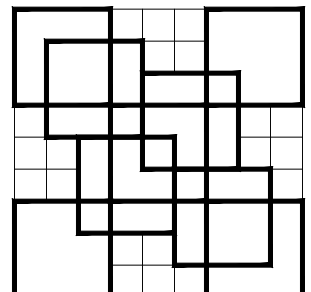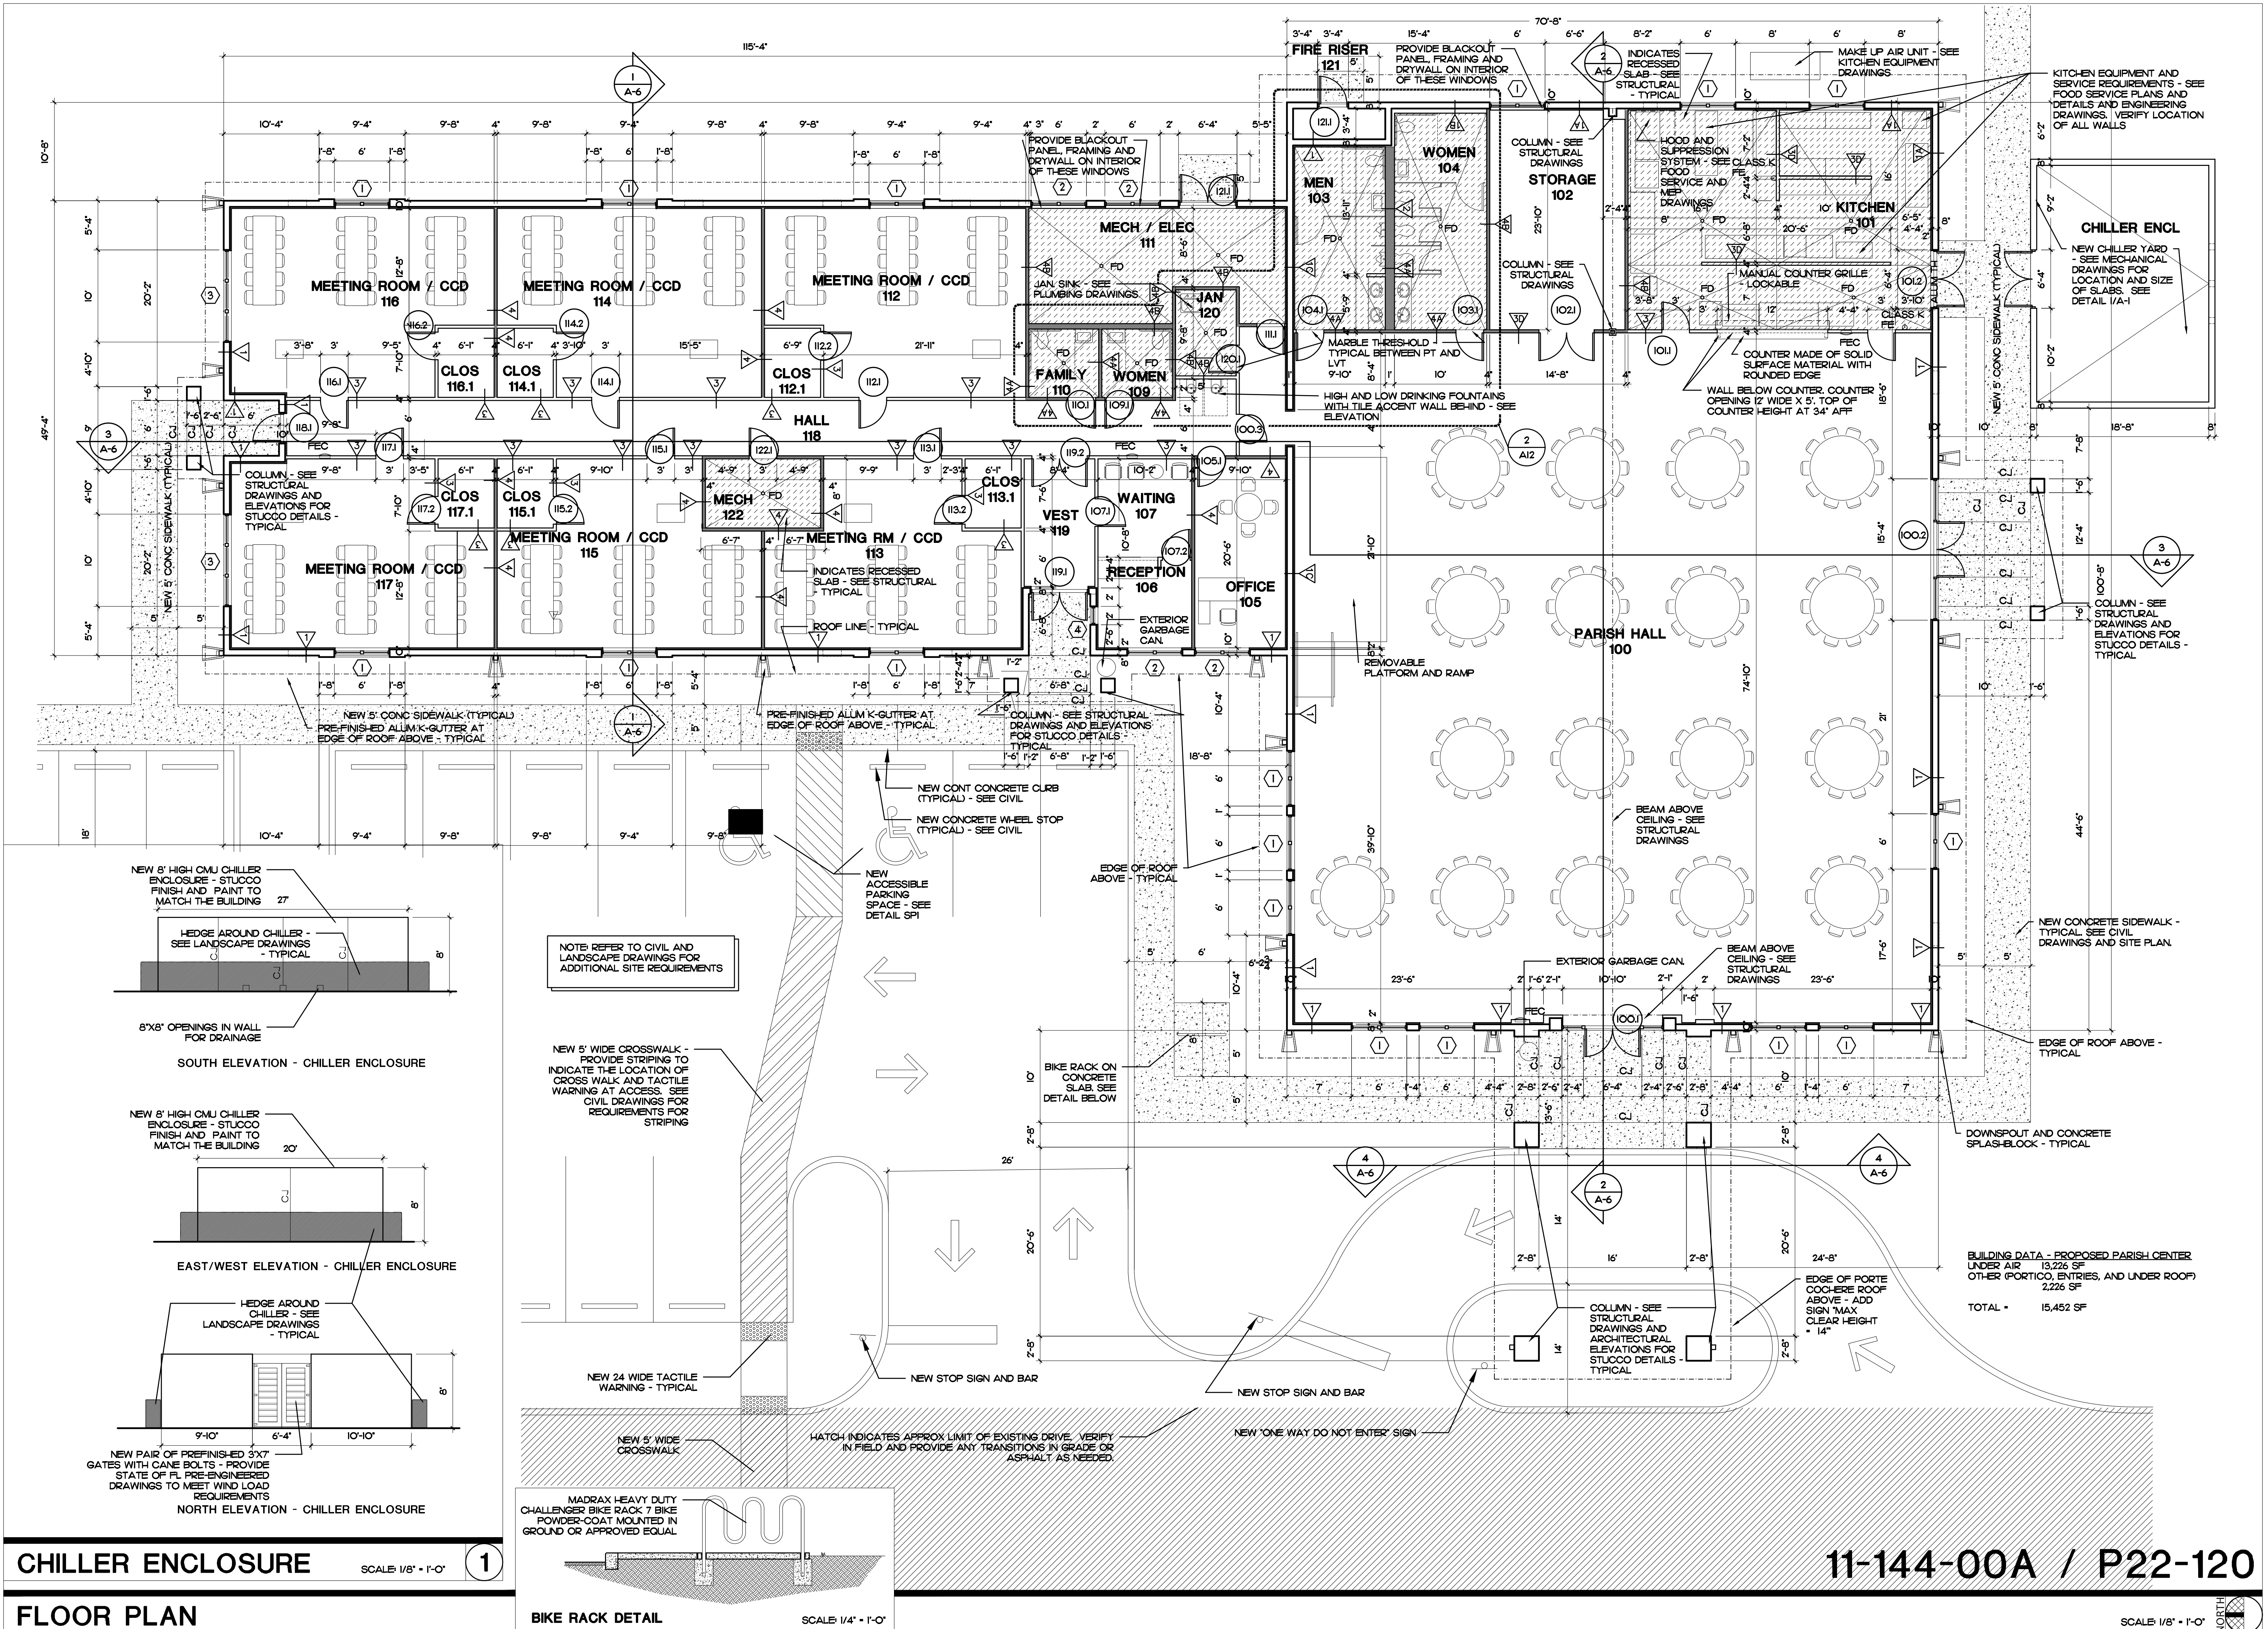

COLOME & Associates, Inc.
AA 0003439
530 24TH STREET
WEST PALM BEACH
FLORIDA 33407
(561) 833-9147
Architect: ELIZABETH A. G. COLOME
REG. NUMBER: AR 0014839



Printed copies of this document are not considered signed and sealed and the signature must be verified on any electronic copies.

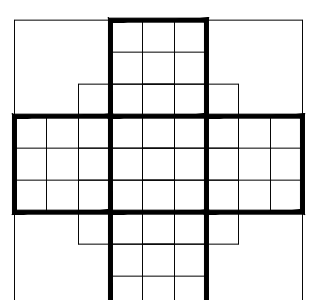



St. Elizabeth Ann Seton

New Parish Hall Building

930 SW Tunis Ave

PORT ST. LUCIE
FLORIDA

 PROJECT NO.
202053

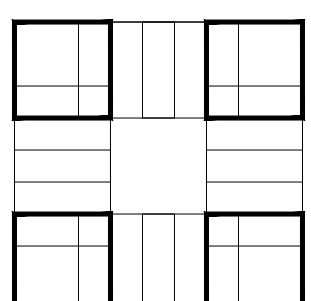


SHEET TITLE:
FLOOR PLAN

REVISIONS

DATE
2-15-24
DRAWN BY:
EAC
CHECKED BY:
EAC

SHEET
NUMBER:


A-1

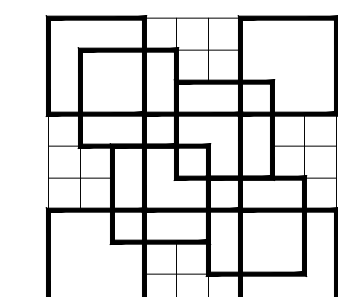

COLOME & Associates, Inc.
AA 0003439
530 24TH STREET
WEST PALM BEACH
FLORIDA 33407
(561) 833-9147
Architect: ELIZABETH A. G. COLOME
REG. NUMBER: AR 0014839



Printed copies of this document are not considered signed and sealed and the signature must be verified on any electronic copies.

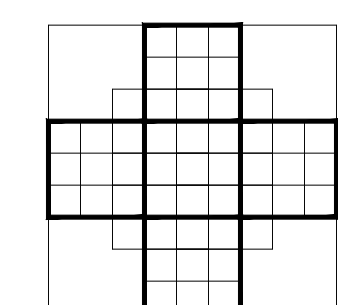



St. Elizabeth Ann Seton

New Parish Hall Building

930 SW Tunis Ave

PORT ST. LUCIE
FLORIDA

 PROJECT NO.
202053

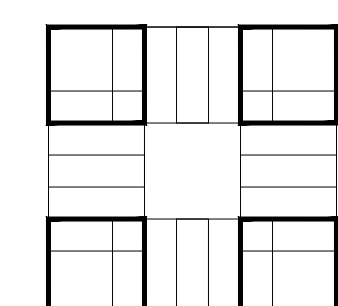


SHEET TITLE:
**REFLECTED
CEILING PLAN**

REVISIONS:


DATE
2-15-24
DRAWN BY:
EAC
CHECKED BY:
EAC

SHEET
NUMBER:

A-2

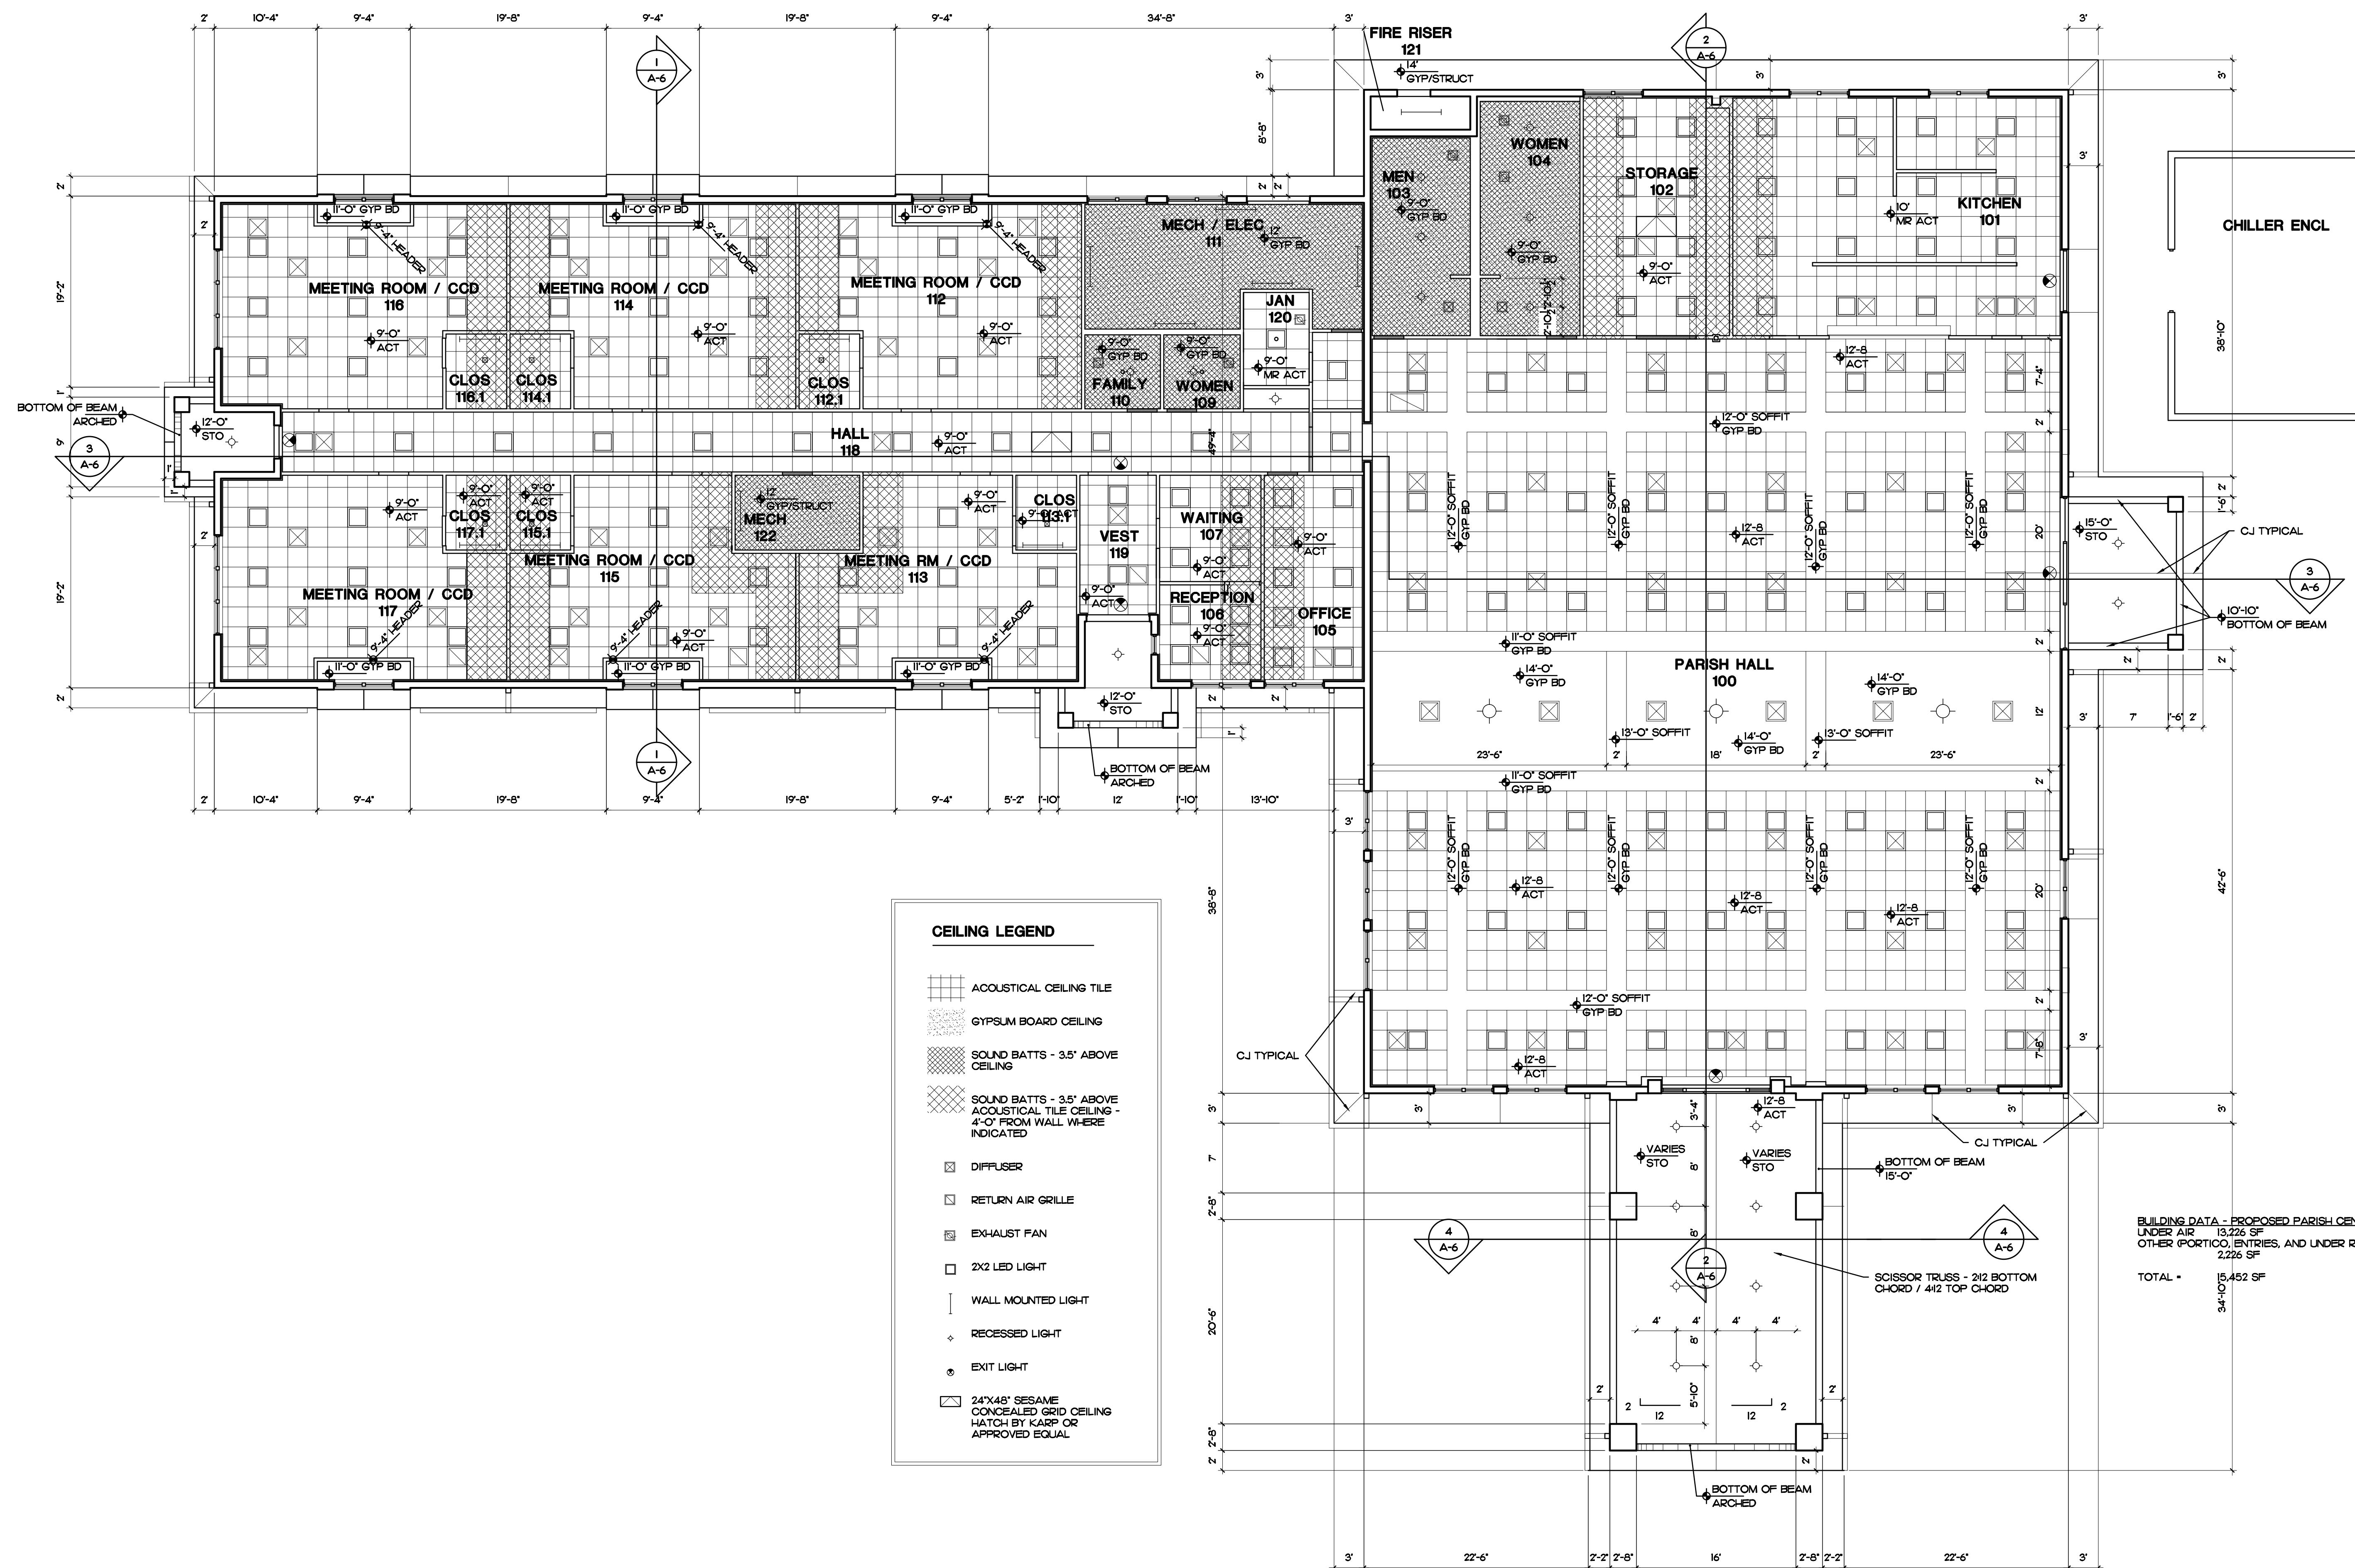

REFLECTED CEILING PLAN

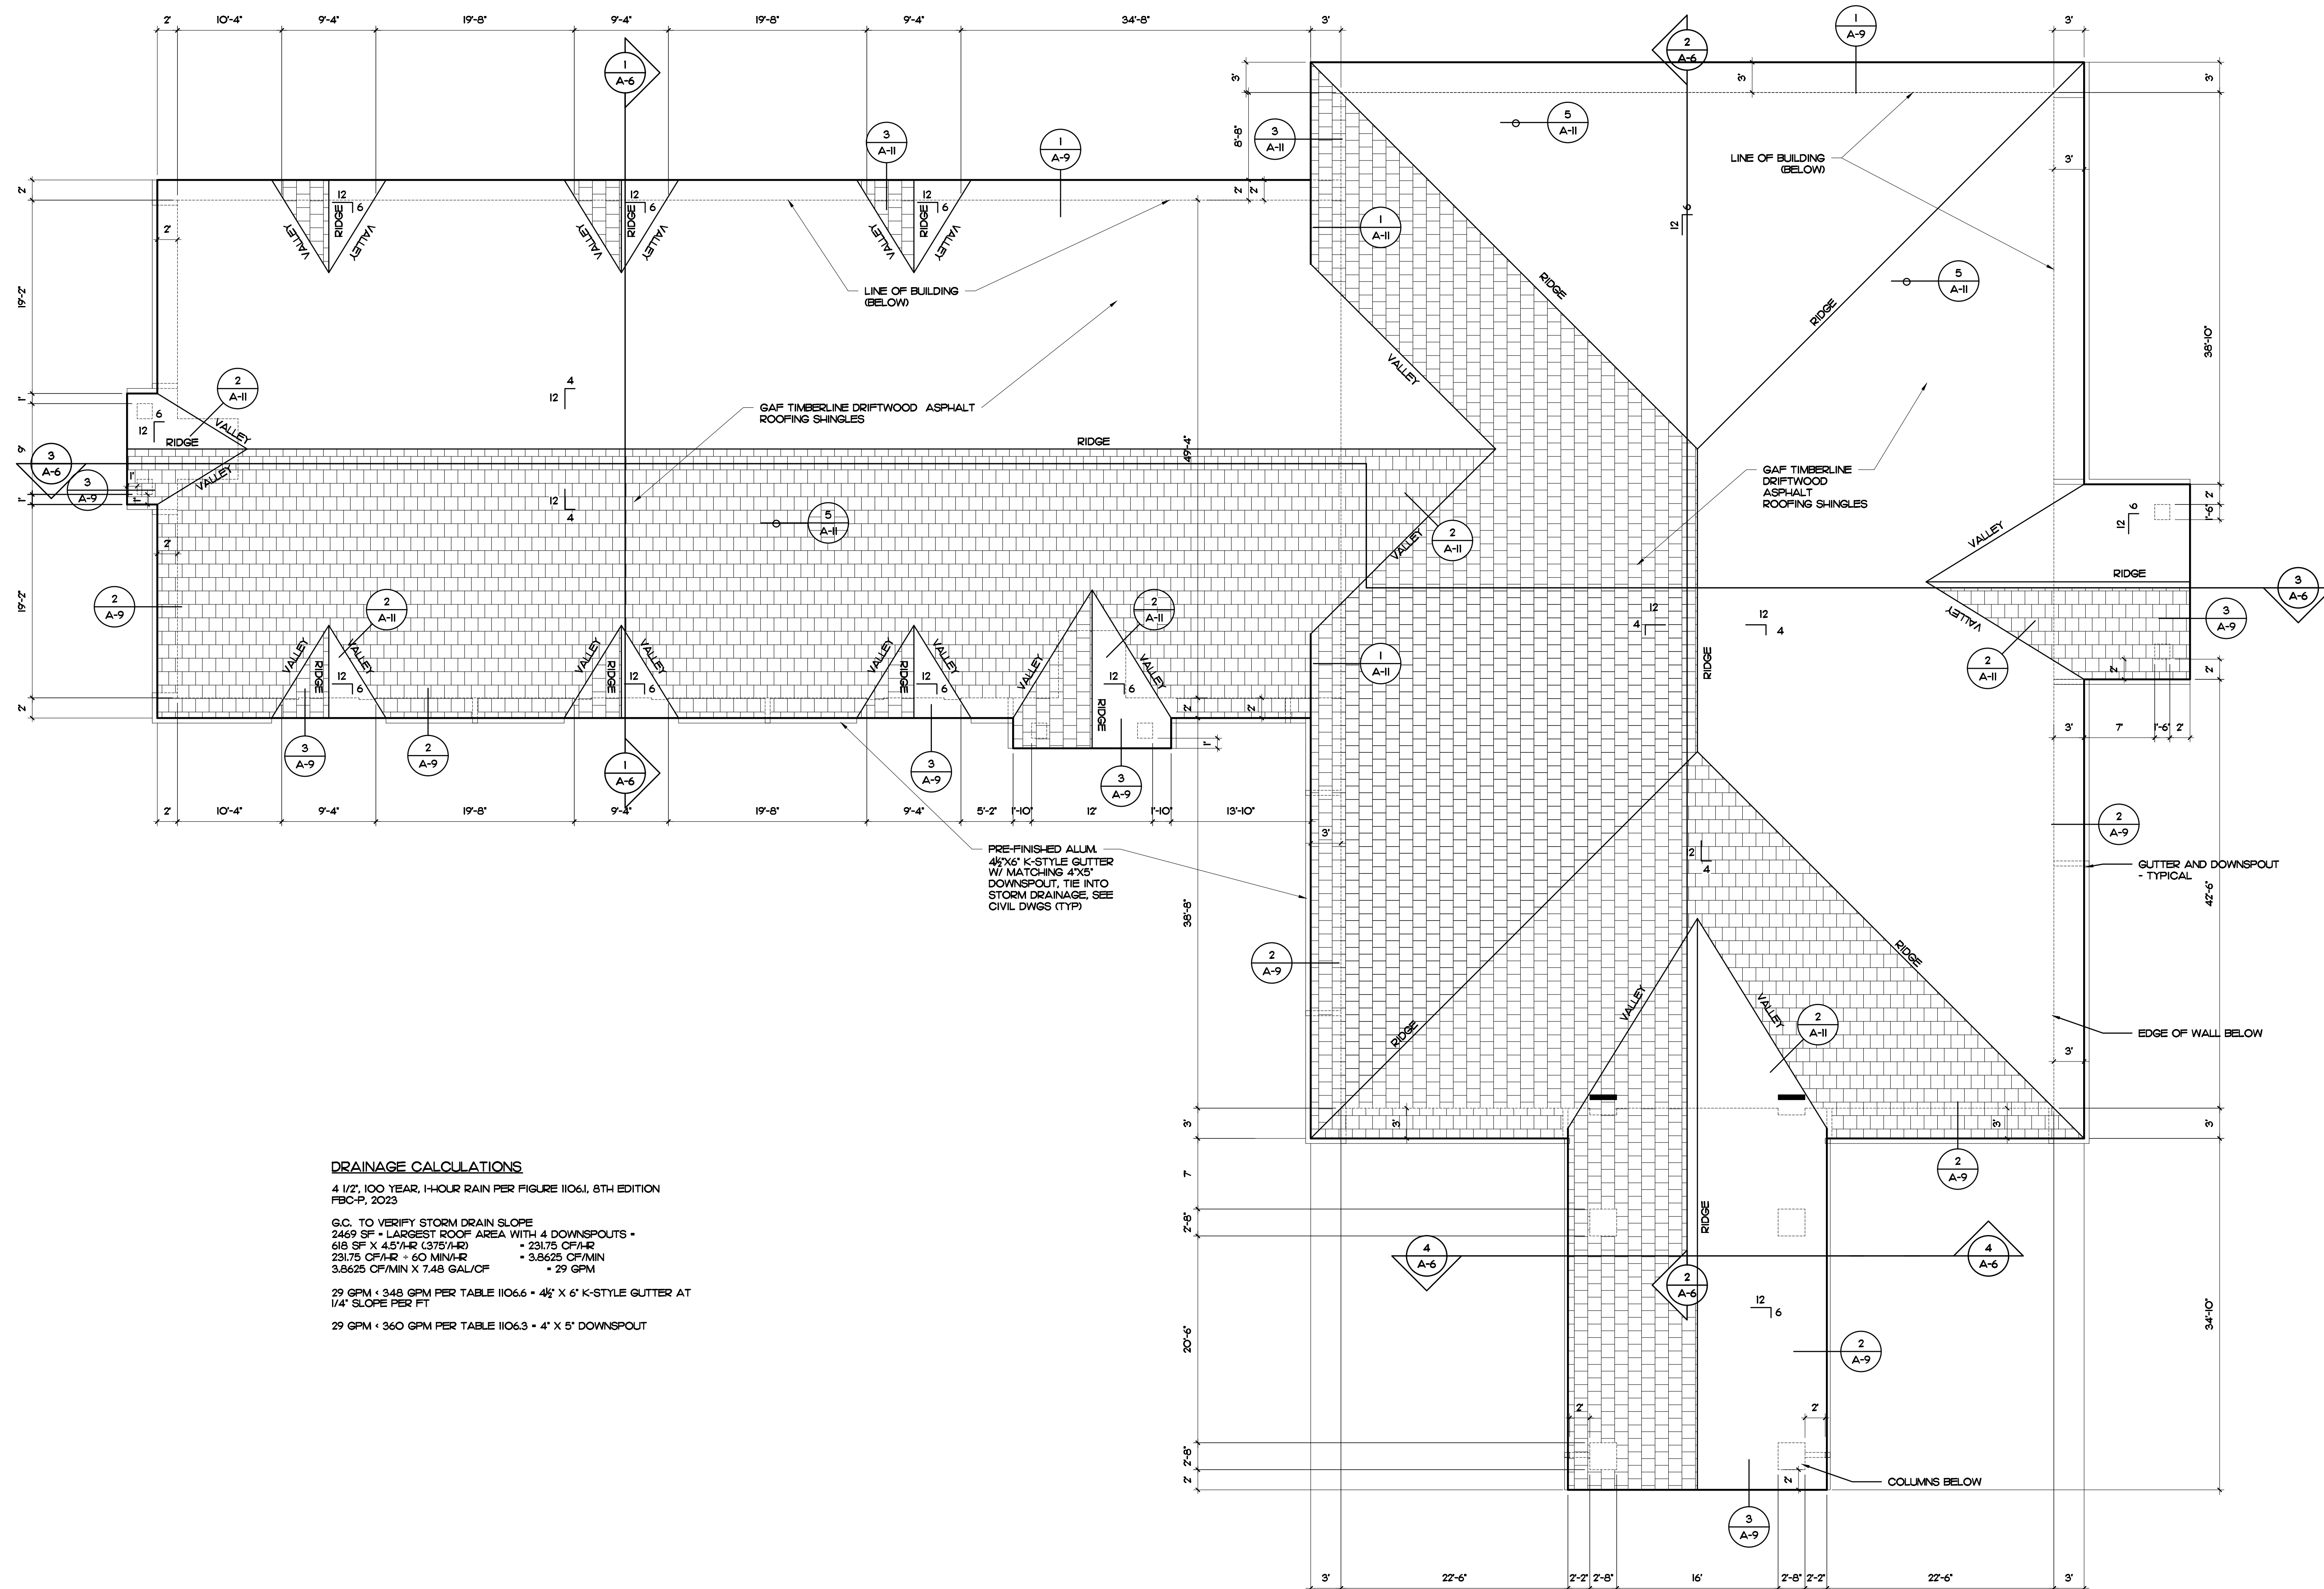

DRAINAGE CALCULATIONS
4 1/2" 100 YEAR, 1-HOUR RAIN PER FIGURE 1106.1, 8TH EDITION
FBC-P, 2023

G.C. TO VERIFY STORM DRAIN SLOPE
2469 SF = LARGEST ROOF AREA WITH 4 DOWNSPOUTS =
618 SF X 4.5"/HR (375/HR) = 231.75 CF/HR
231.75 CF/HR ÷ 60 MIN/HR = 3.8625 CF/MIN
3.8625 CF/MIN X 7.48 GAL/CF = 29 GPM


29 GPM ÷ 348 GPM PER TABLE 1106.6 = 4 1/2" X 6' K-STYLE GUTTER AT
1/4" SLOPE PER FT

29 GPM ÷ 360 GPM PER TABLE 1106.3 = 4" X 5" DOWNSPOUT

ROOF PLAN

11-144-00A / P22-120


SCALE: 1/8" = 1'-0"

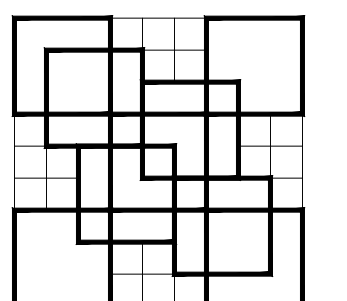

COLOME & Associates, Inc.
AA 0003439
530 24TH STREET
WEST PALM BEACH
FLORIDA 33407
(561) 833-9147
Architect: ELIZABETH A. G. COLOME
REG. NUMBER: AR 0014839



Printed copies of this document are not considered signed and sealed and the signature must be verified on any electronic copies

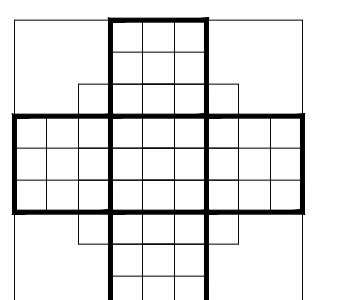


St. Elizabeth Ann Seton

New Parish Hall Building

930 SW Tunis Ave

PORT ST. LUCIE
FLORIDA

PROJECT NO.
202053

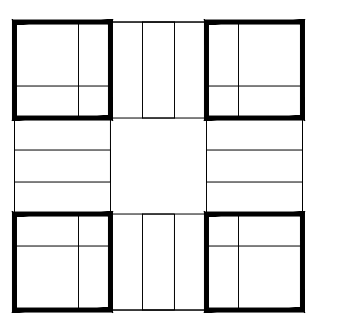

SHEET TITLE:
ROOF PLAN

REVISIONS:

DATE
2-15-24
DRAWN BY:
EAC
CHECKED BY:
EAC

SHEET
NUMBER:

A-3



Printed copies of this document are not considered signed and sealed and the signature must be verified on any electronic copies




New Parish Hall Building

930 SW Tunis Ave

PORT ST. LUCIE
FLORIDA

PROJECT NO.
202053

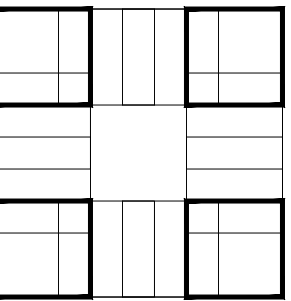

SHEET TITLE:
**EXTERIOR
ELEVATIONS**

REVISIONS.

DATE
2-15-22

DRAWN BY:

HDM

CHECKED BY:


SHEET
NUMBER:

A-4



SCALE: 1/8" = 1'-0"

1

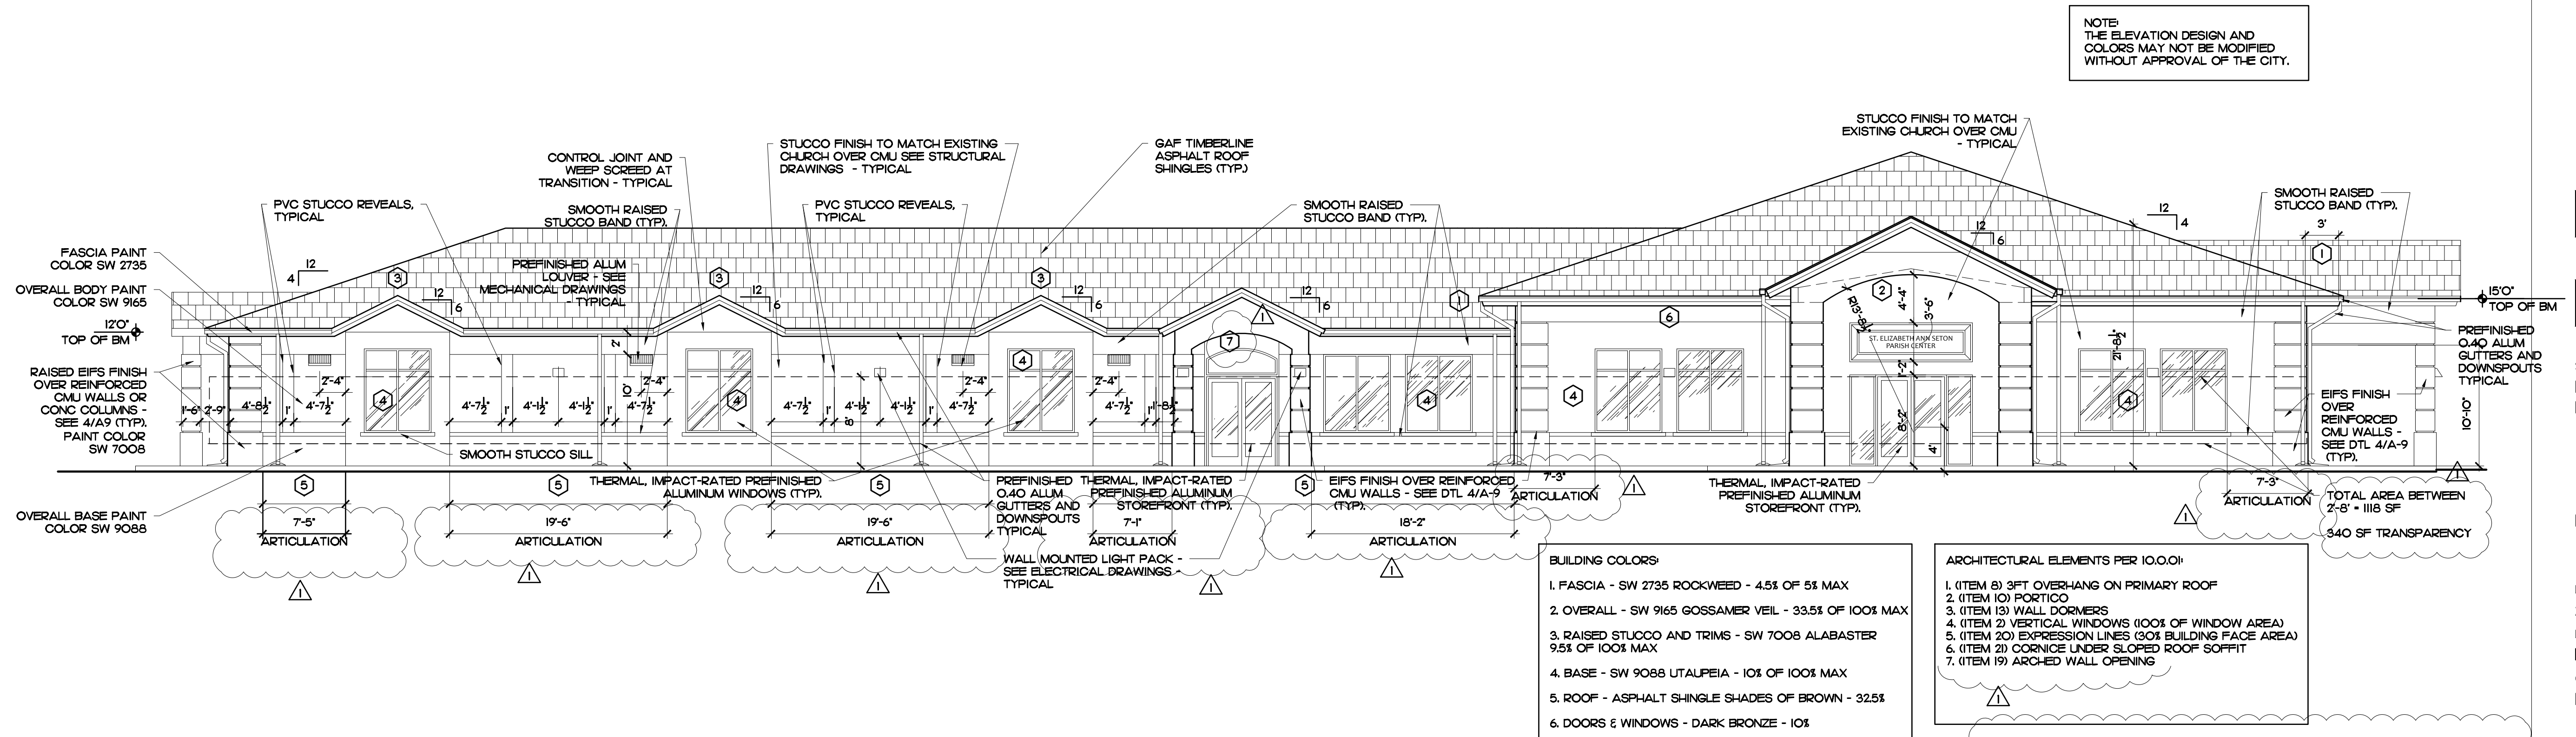


11-144-00A / P22-120

SCALE: 1/8" = 1'-0"


2

WEST ELEVATION - SIDE FACADE - MAIN ENTRANCE

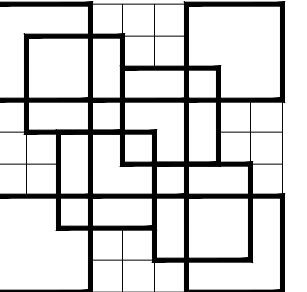

COLOME
& Associates, Inc.
AA 0003439
530 24TH STREET
WEST PALM BEACH
FLORIDA 33407
(561) 833-9147
Architect: ELIZABETH A. G. COLOME
REG. NUMBER: AR 0014839

Printed copies of this
document are not
considered signed and
sealed and the signature
must be verified on any
electronic copies

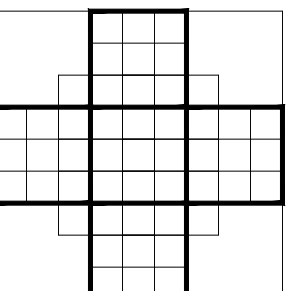



**St. Elizabeth
Ann Seton**

**New Parish Hall
Building**

930 SW Tunis Ave

PORT ST. LUCIE
FLORIDA

 PROJECT NO.
202053

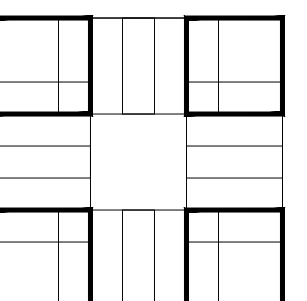

SHEET TITLE:
**EXTERIOR
ELEVATIONS**

REVISIONS:


DATE
2-15-22

DRAWN BY:
HDM

CHECKED BY:
EAC

SHEET
NUMBER:

A-5

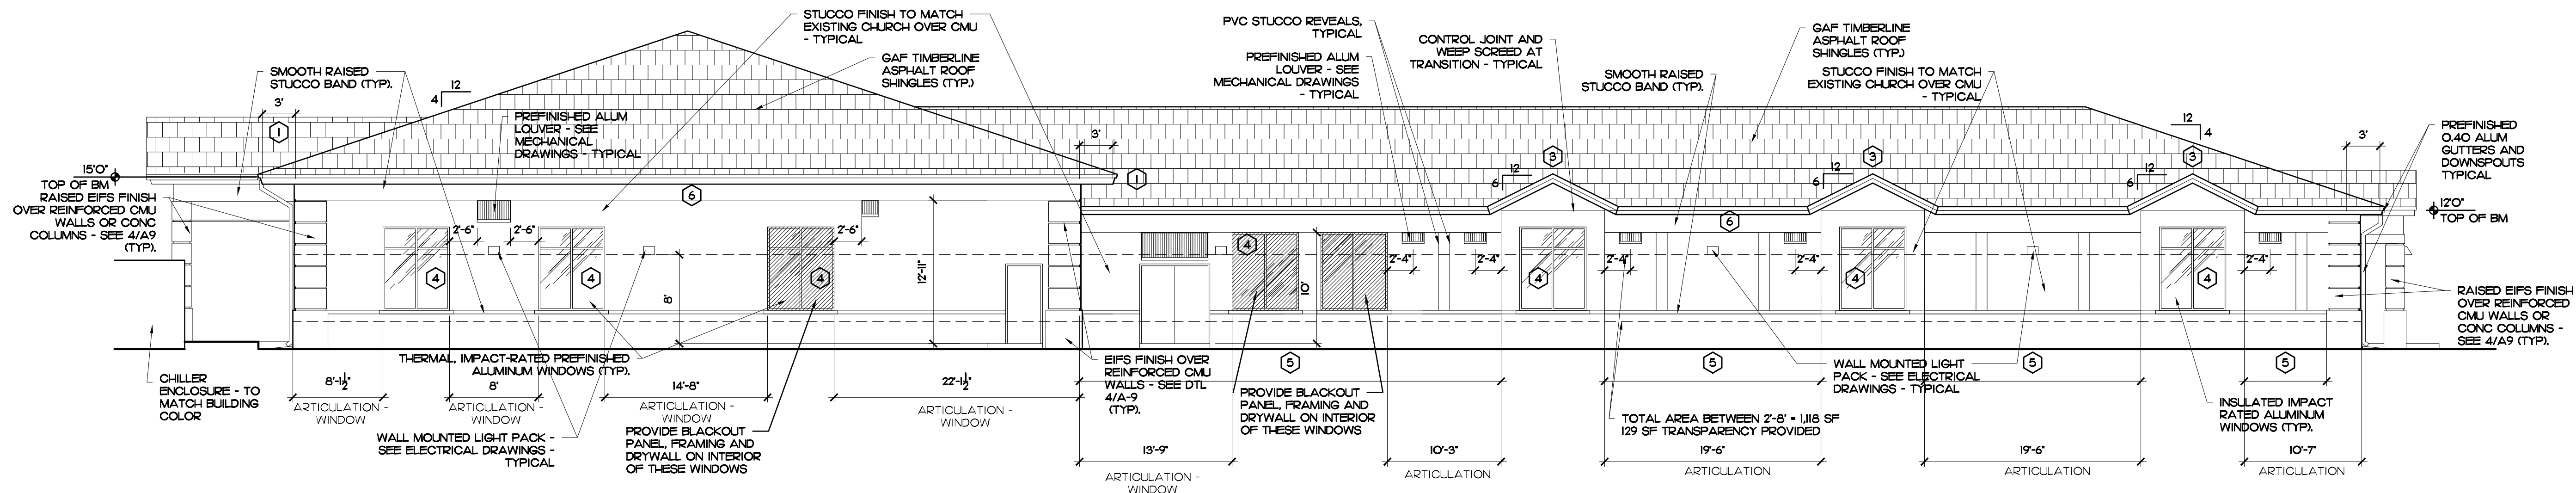


EAST ELEVATION - SIDE FACADE

SCALE: 1/8" = 1'-0"

1

NOTE:
THE ELEVATION DESIGN AND
COLORS MAY NOT BE MODIFIED
WITHOUT APPROVAL OF THE CITY.

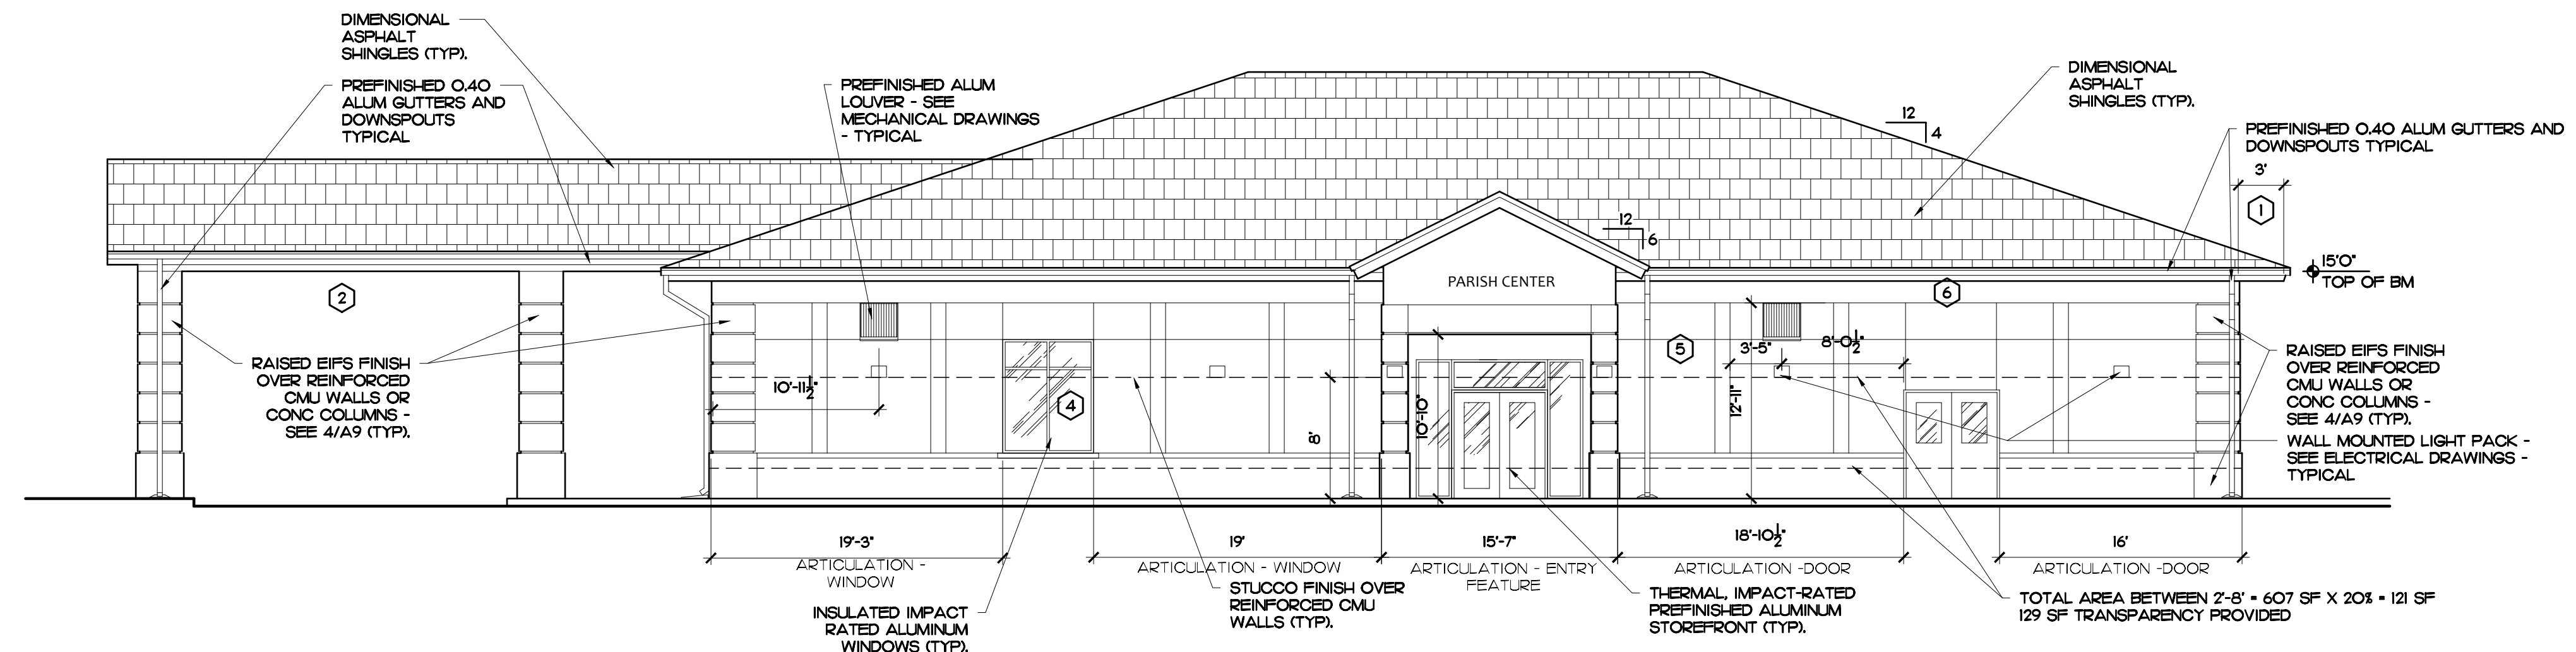


SOUTH ELEVATION - REAR FACADE

SCALE: 1/8" = 1'-0"

2

- BUILDING COLORS**
1. FASCIA - SW 2735 ROCKWEED - 45% OF 5% MAX
 2. OVERALL - SW 9165 GOSSAMER VEIL - 33.5% OF 100% MAX
 3. RAISED STUCCO AND TRIMS - SW 7008 ALABASTER 95% OF 100% MAX
 4. BASE - SW 9088 UTALEPIA - 10% OF 100% MAX
 5. ROOF - ASPHALT SHINGLE SHADES OF BROWN - 32.5%
 6. DOORS & WINDOWS - DARK BRONZE - 10%
- ARCHITECTURAL ELEMENTS PER 100.00'**
1. (ITEM 8) 3FT OVER-HANG ON PRIMARY ROOF
 2. (ITEM 10) PORTICO
 3. (ITEM 13) WALL DORMERS
 4. (ITEM 2) VERTICAL WINDOWS (100% OF WINDOW AREA)
 5. (ITEM 20) EXPRESSION LINES (30% BUILDING FACE AREA)
 6. (ITEM 21) CORNICE UNDER SLOPED ROOF SOFFIT
 7. (ITEM 19) ARCHED WALL OPENING

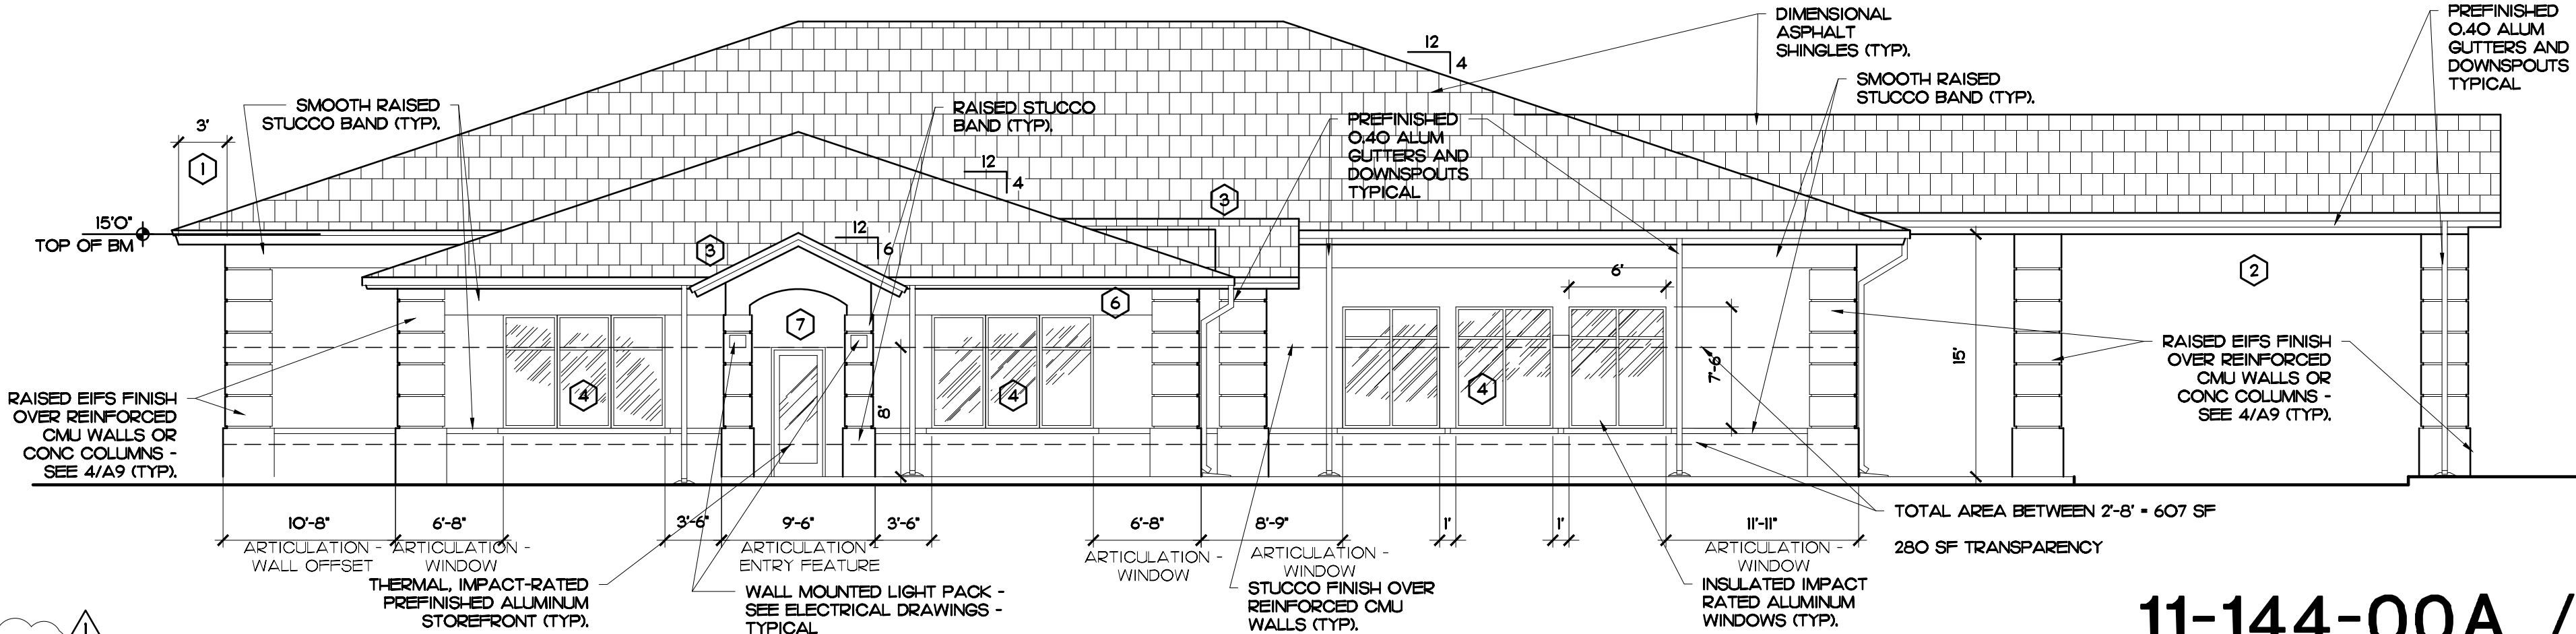


NORTH ELEVATION - FRONT FACADE

SCALE: 1/8" = 1'-0"

3


11-144-00A / P22-120

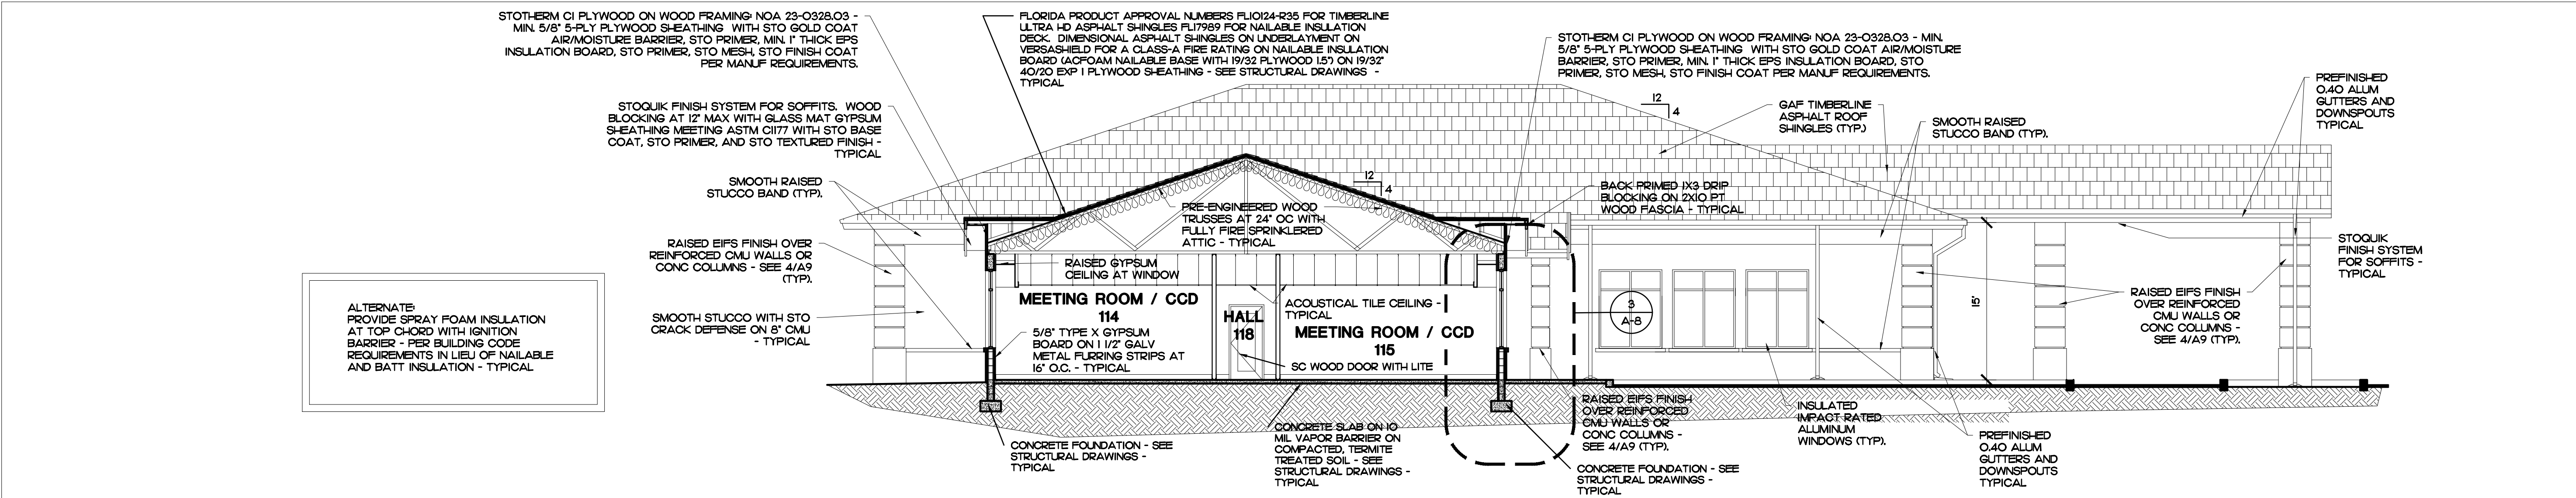

SECTION

SCALE: 1/8" = 1'-0"

1

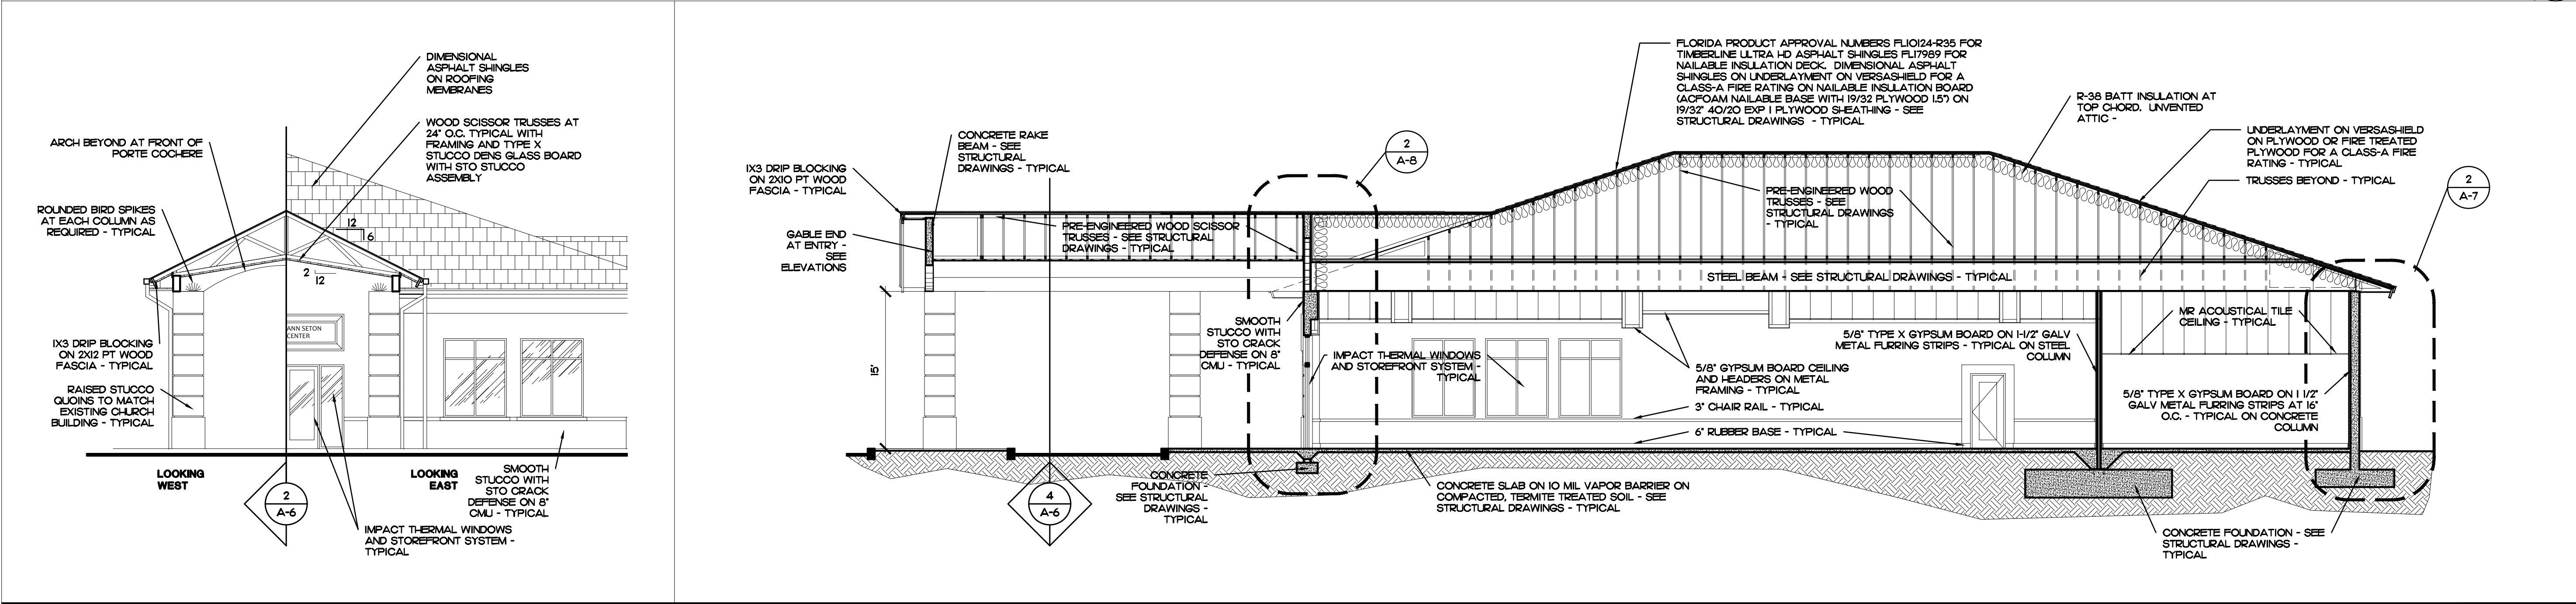

PORTE COCHERE SECTION


SCALE: 1/8" = 1'-0"

4

SECTION

SCALE: 1/8" = 1'-0"

2

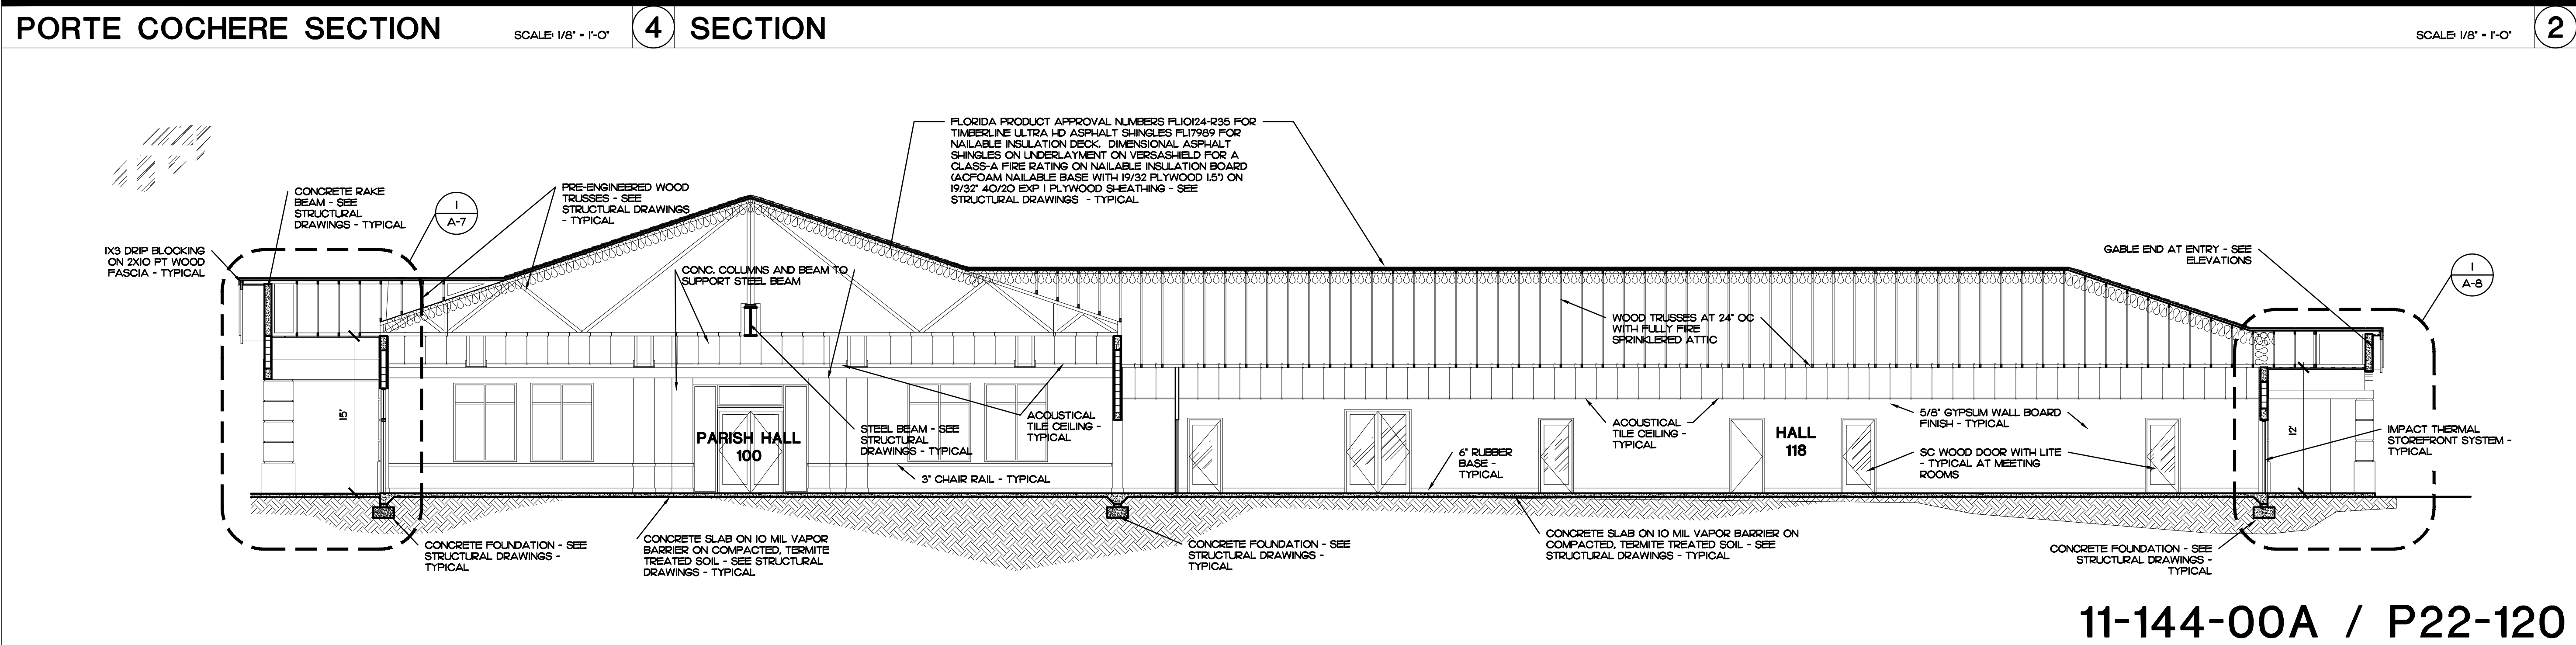


SECTION

SCALE: 1/8" = 1'-0"

3


11-144-00A / P22-120

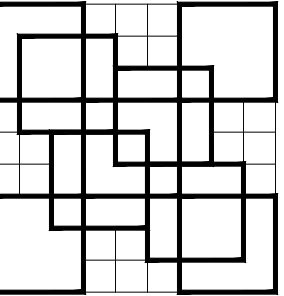

COLOME
& Associates, Inc.
AA 0003439
530 24TH STREET
WEST PALM BEACH
FLORIDA 33407
(561) 833-9147
Architect: ELIZABETH A. G. COLOME
REG. NUMBER: AR 0014839



Printed copies of this document are not considered signed and sealed and the signature must be verified on any electronic copies

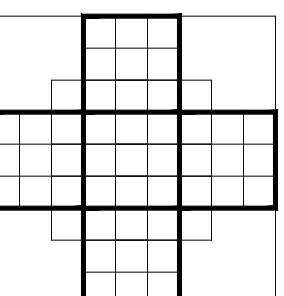



**St. Elizabeth
Ann Seton**

**New Parish Hall
Building**

930 SW Tunis Ave

PORT ST. LUCIE
FLORIDA

 PROJECT NO.
202053

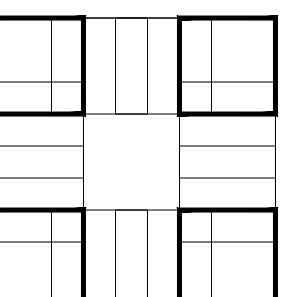

SHEET TITLE:
SECTIONS

REVISIONS:


DATE
2-15-24

DRAWN BY:
EAC

CHECKED BY:
EAC

SHEET
NUMBER:


A-6

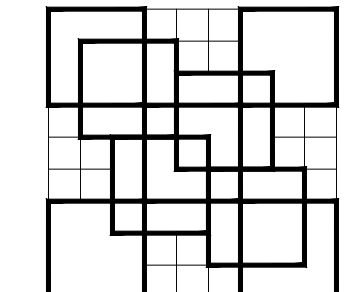

COLOME
& Associates, Inc.
AA 0003439
530 24TH STREET
WEST PALM BEACH
FLORIDA 33407
(561) 833-9147
Architect: ELIZABETH A. G. COLOME
REG. NUMBER: AR 0014839



Printed copies of this
document are not
considered signed and
sealed and the signature
must be verified on any
electronic copies

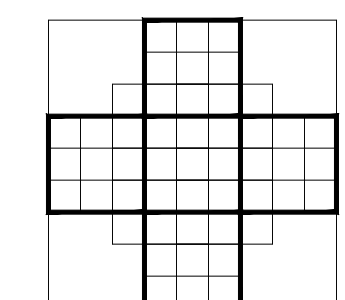



**St. Elizabeth
Ann Seton**

New Parish Hall Building

930 SW Tunis Ave

PORT ST. LUCIE
FLORIDA

 PROJECT NO.
202053

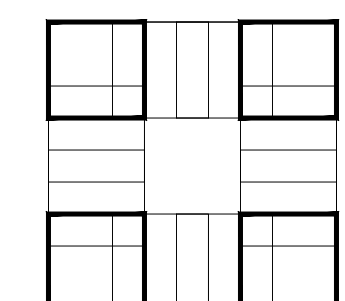

SHEET TITLE:
WALL SECTIONS

REVISIONS:



DATE
2-15-24
DRAWN BY:
EAC
CHECKED BY:
EAC


SHEET
NUMBER:

A-7

1

COPYRIGHT © COLOME & ASSOCIATES, INC.

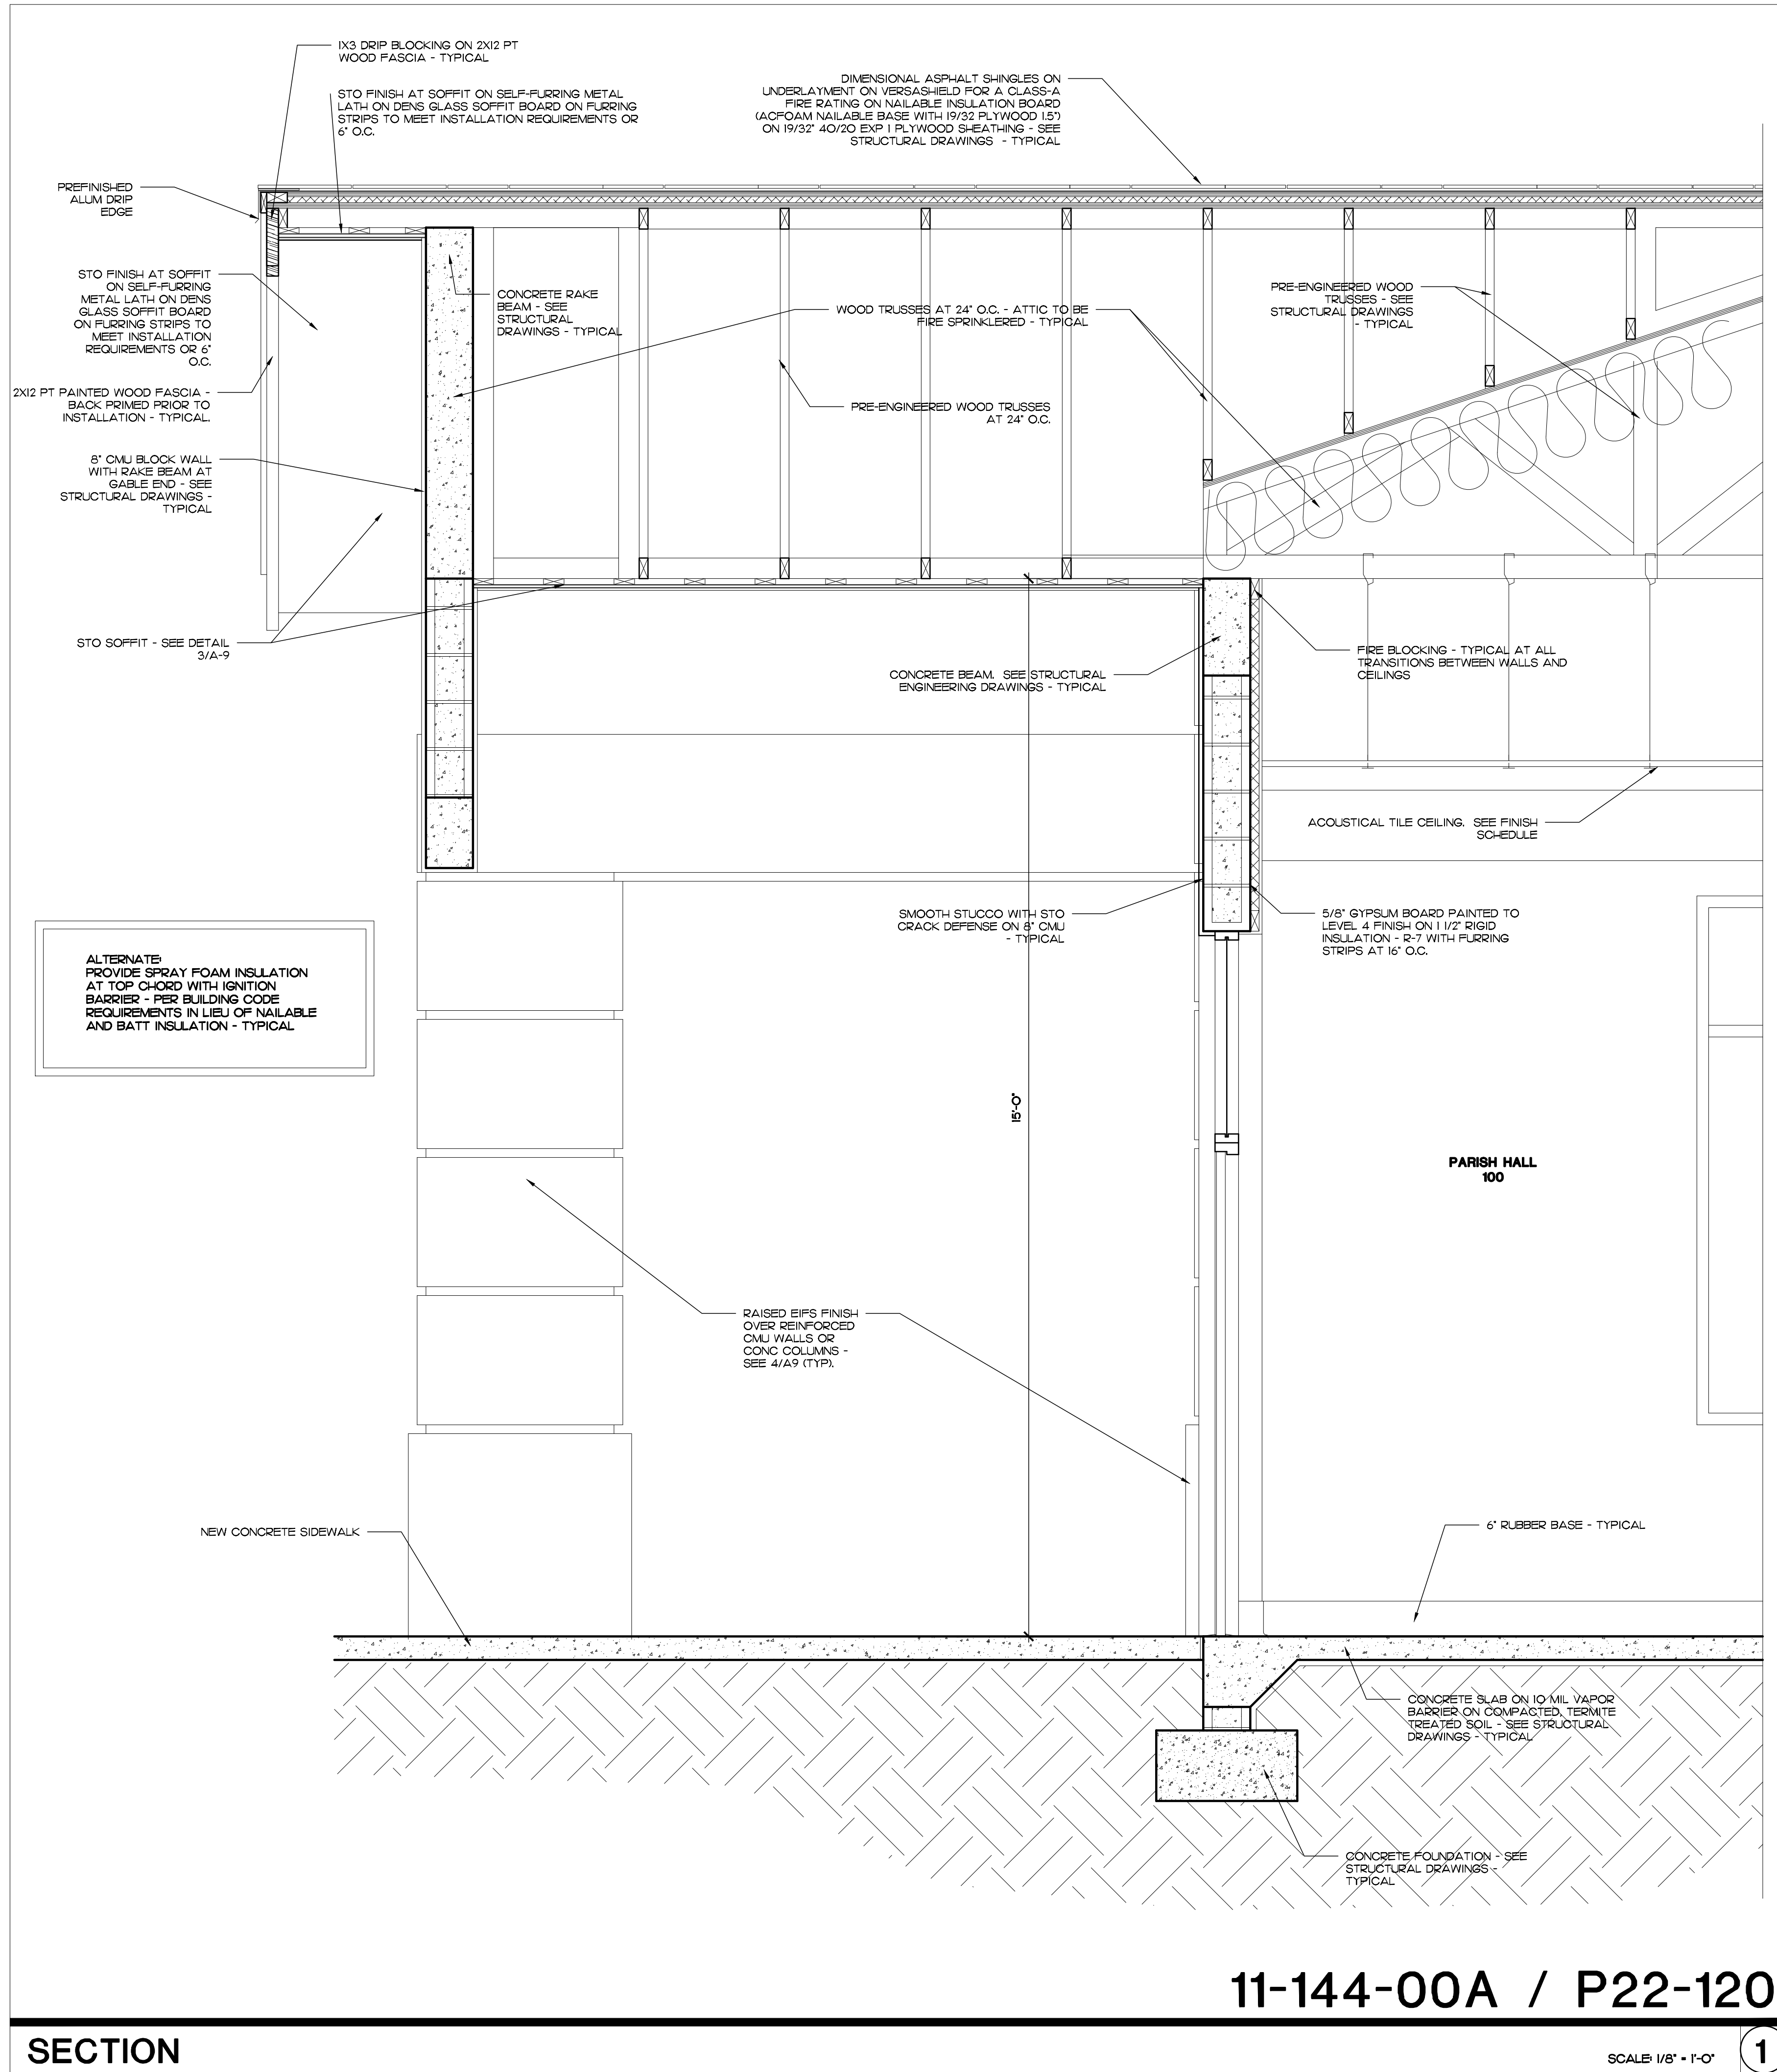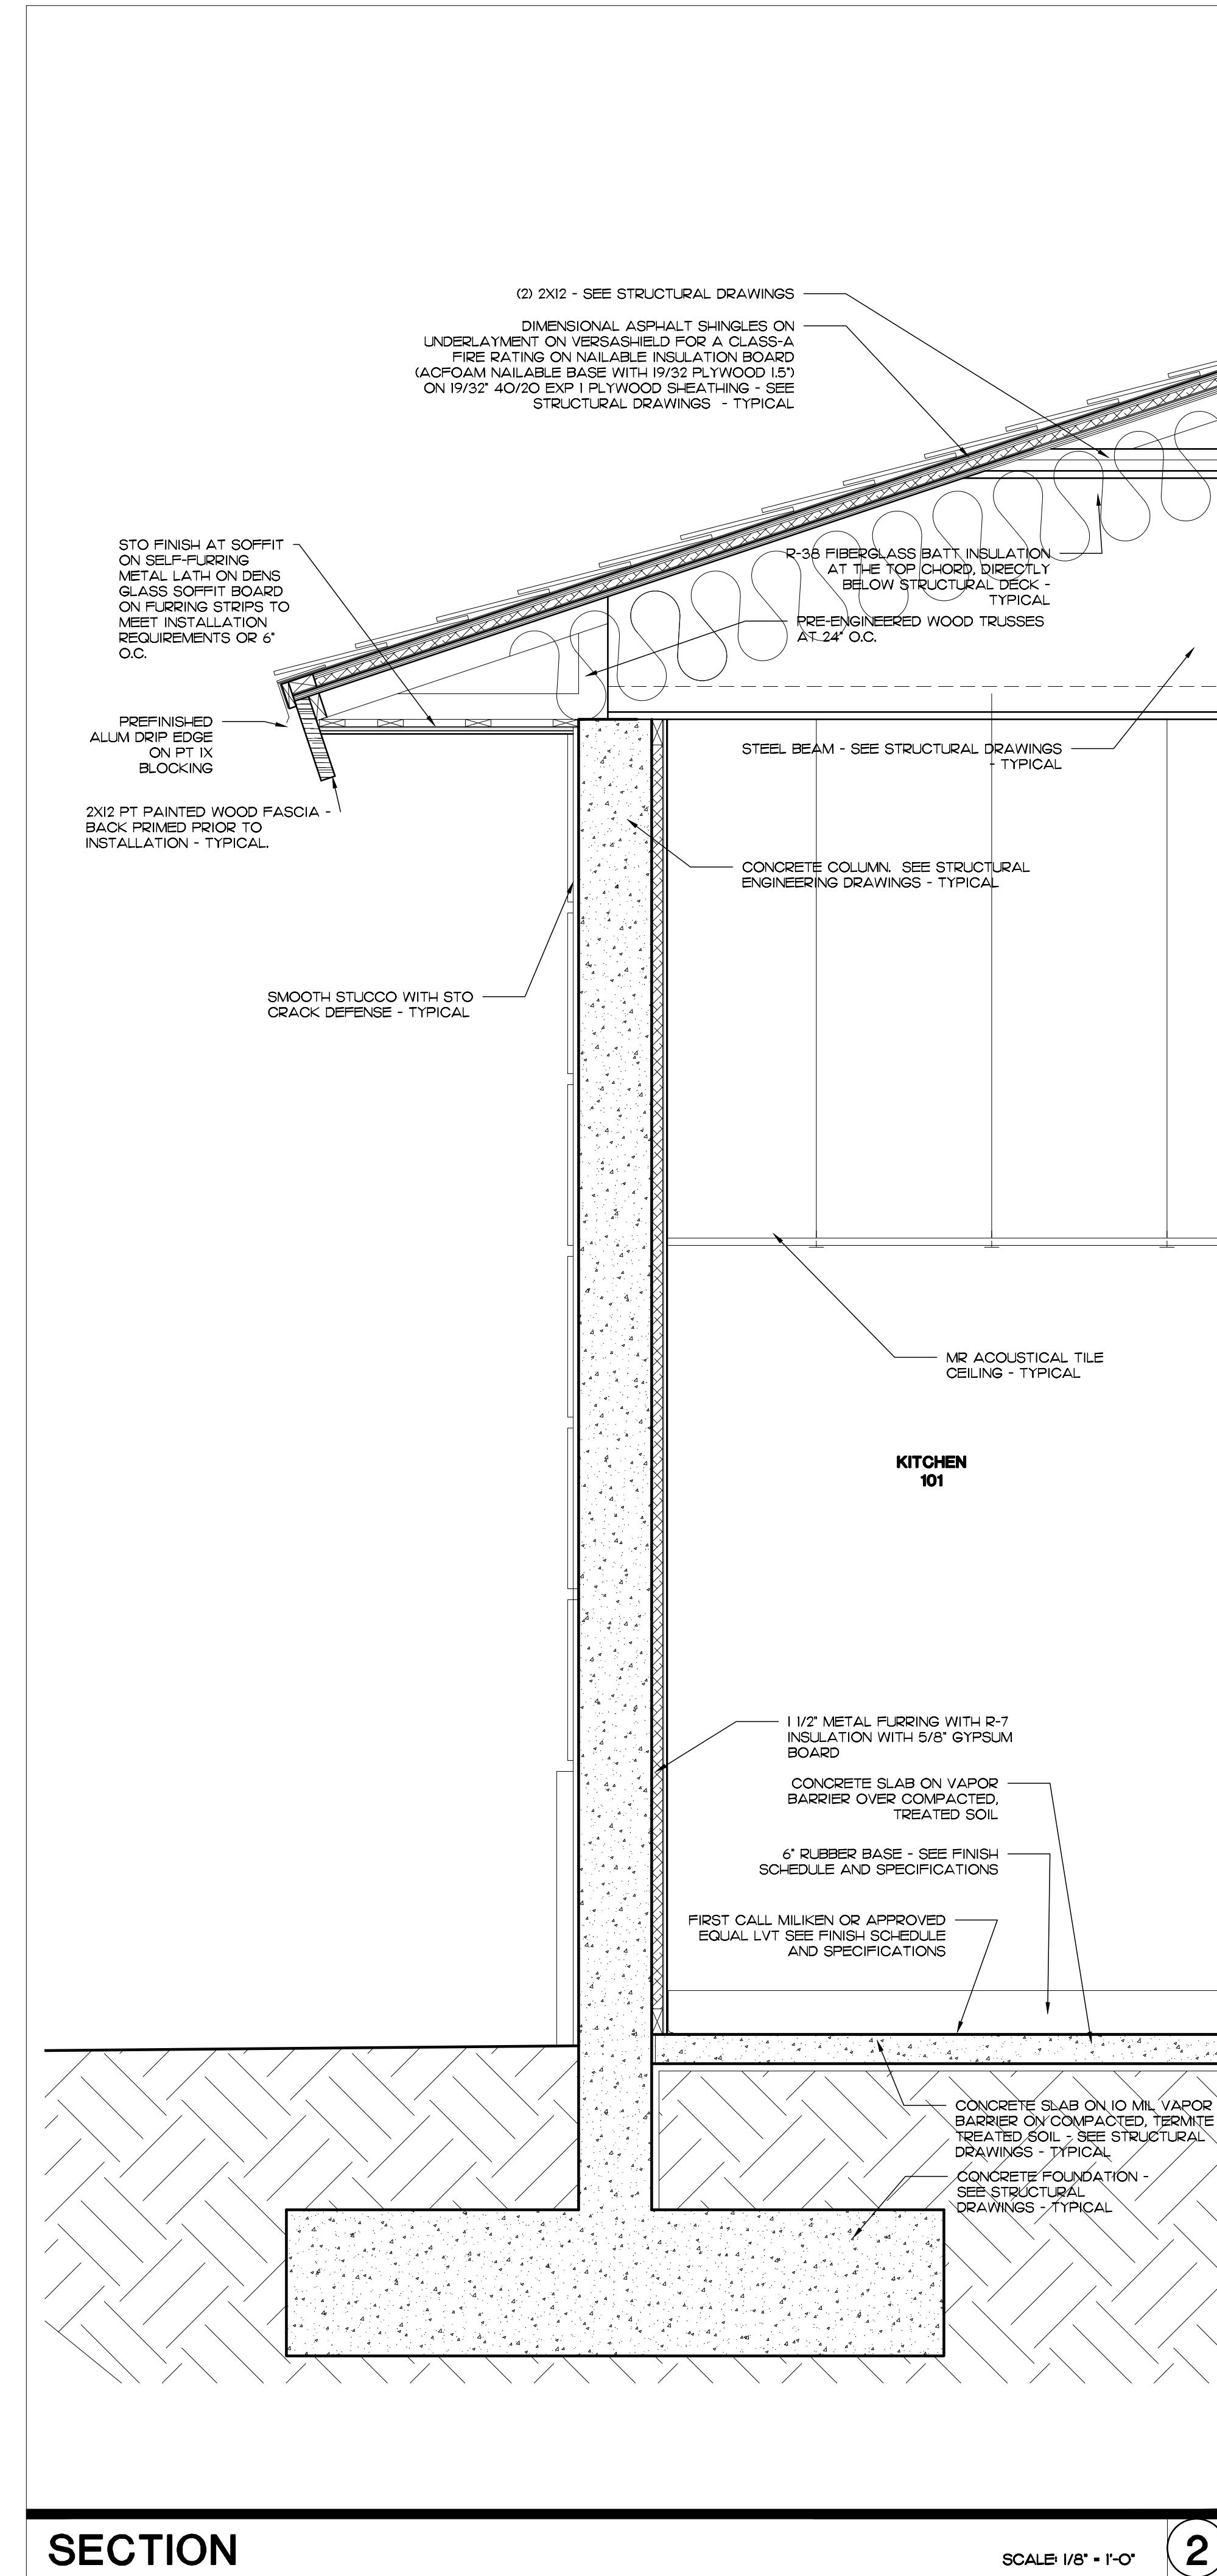


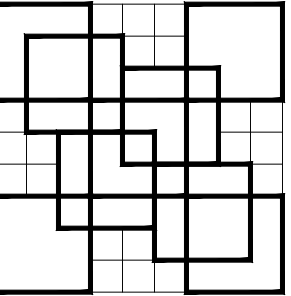

COLOME
& Associates, Inc.
AA 0003439
530 24TH STREET
WEST PALM BEACH
FLORIDA 33407
(561) 833-9147
Architect: ELIZABETH A. G. COLOME
REG. NUMBER: AR 0014839



Printed copies of this document are not considered signed and sealed and the signature must be verified on any electronic copies

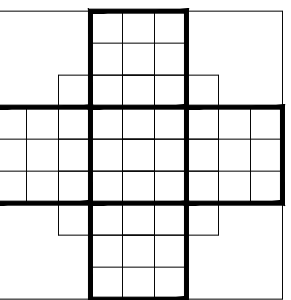



**St. Elizabeth
Ann Seton**

New Parish Hall Building

930 SW Tunis Ave

PORT ST. LUCIE
FLORIDA

 PROJECT NO.
202053

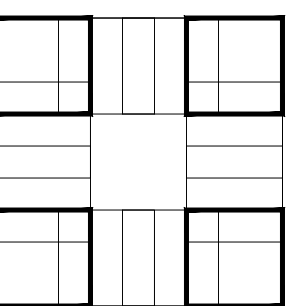


SHEET TITLE:
**EXTERIOR
ELEVATIONS**

REVISIONS:

DATE
2-15-24
DRAWN BY:
EAC
CHECKED BY:
EAC

SHEET
NUMBER:

A-8

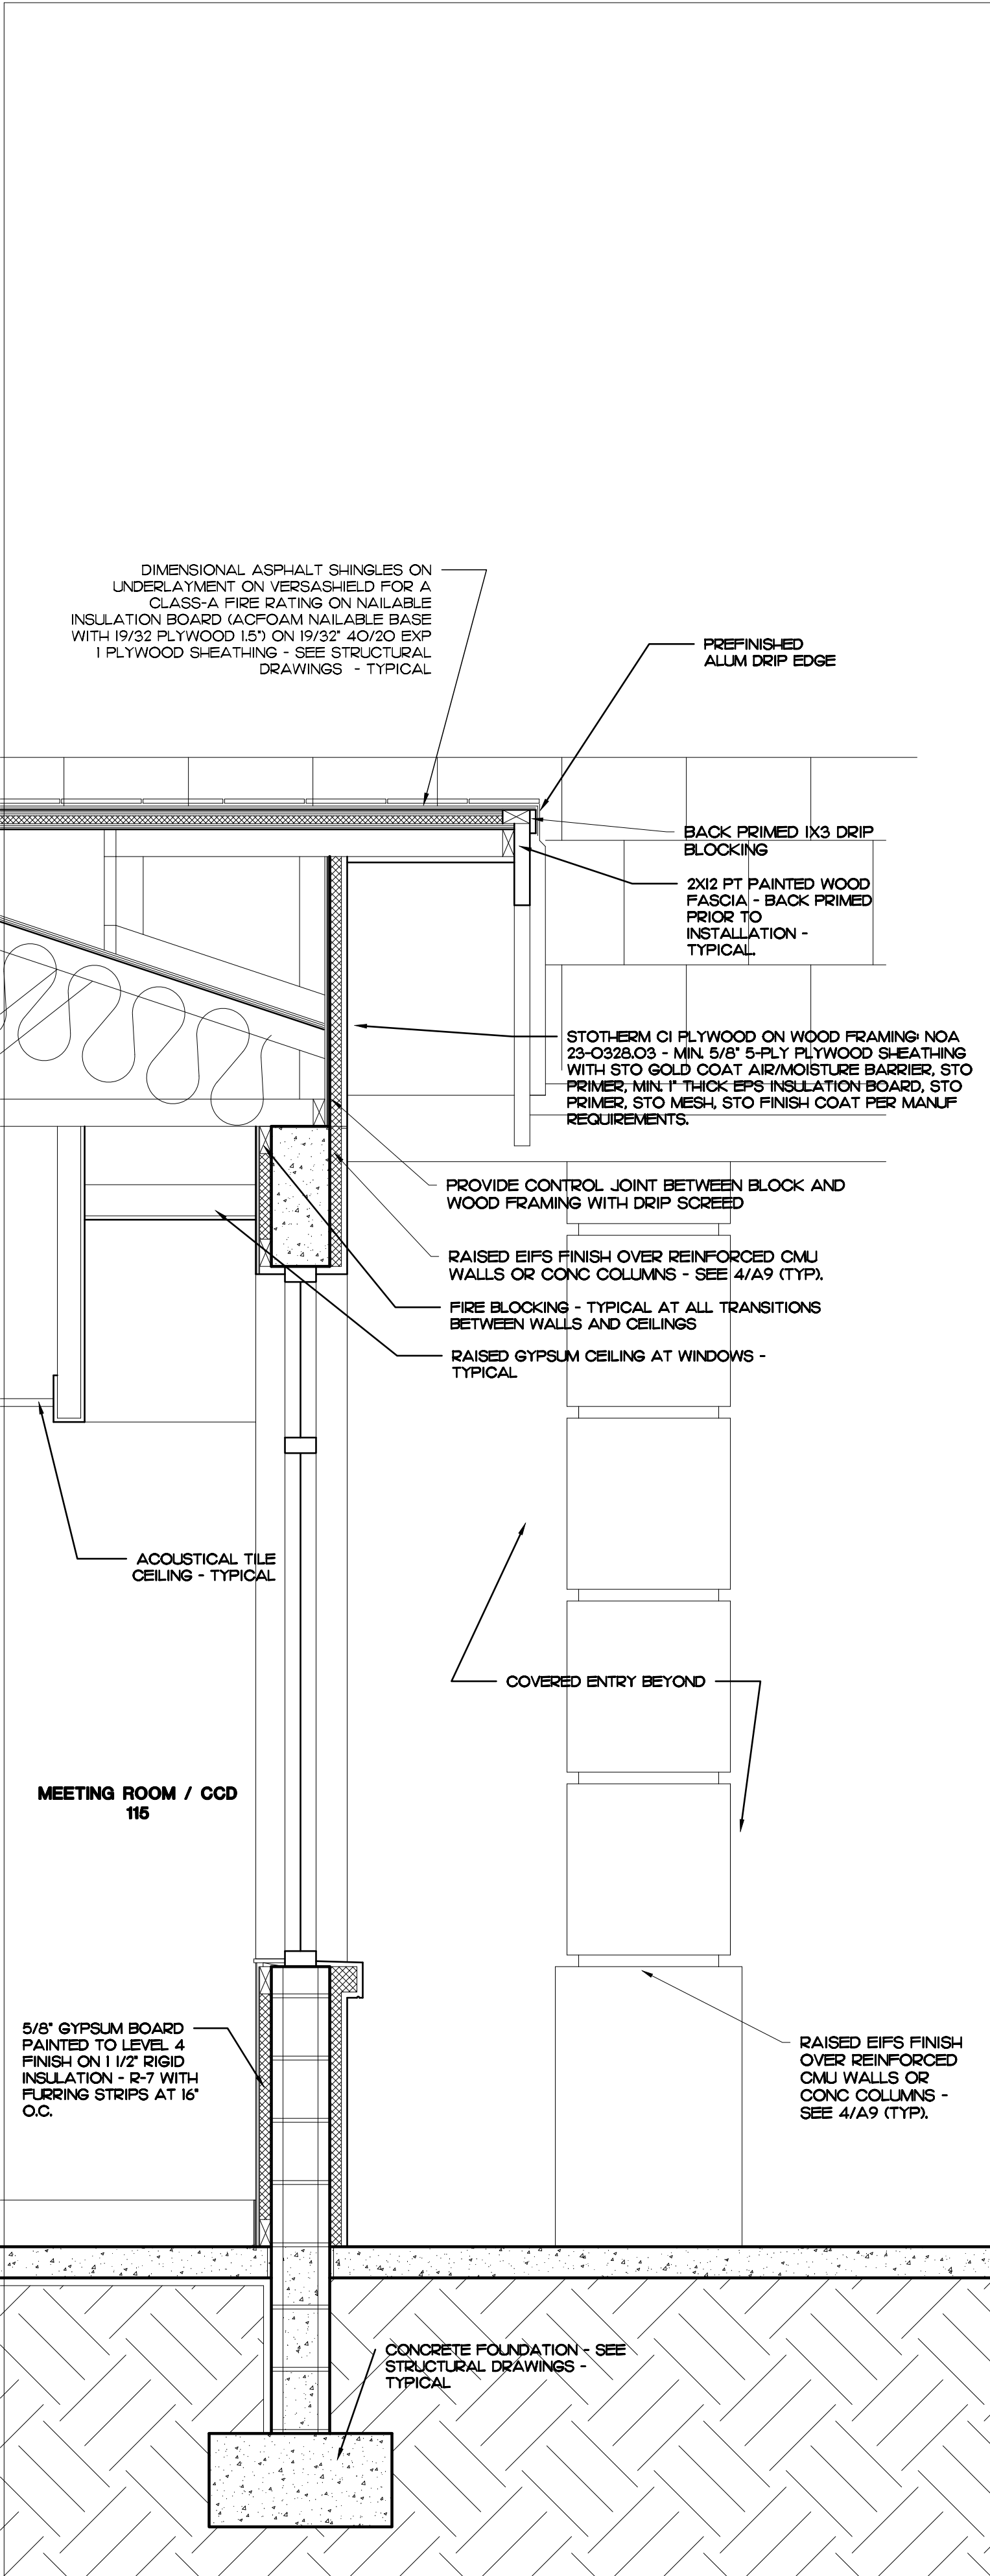

SECTION

SCALE: 3/4" = 1'-0"

3

SECTION

SCALE: 3/4" = 1'-0"


2

SECTION


SCALE: 3/4" = 1'-0"

1


11-144-00A / P22-120

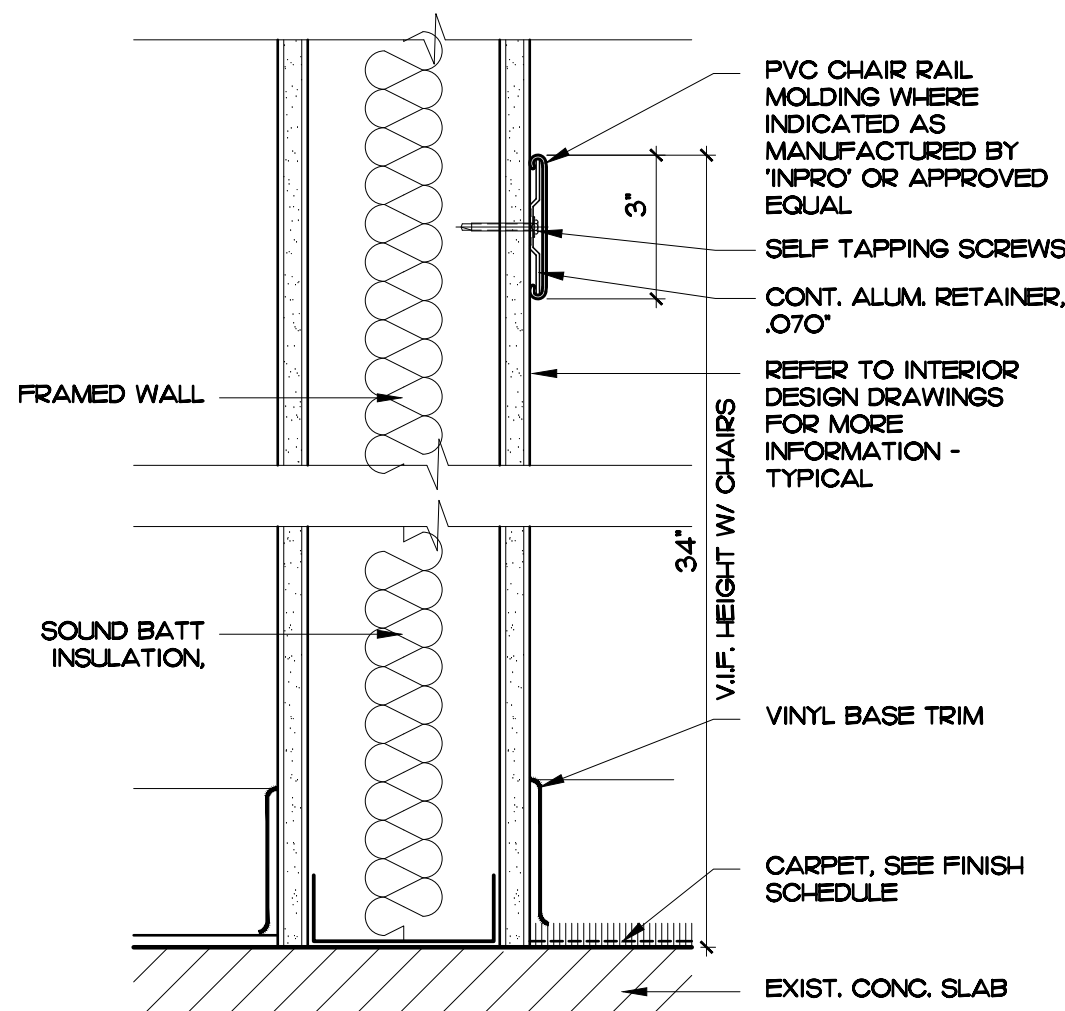


NOTE:
PROVIDE CHAIR RAIL AT ALL GYP BOARD WALLS OF THE PARISH HALL

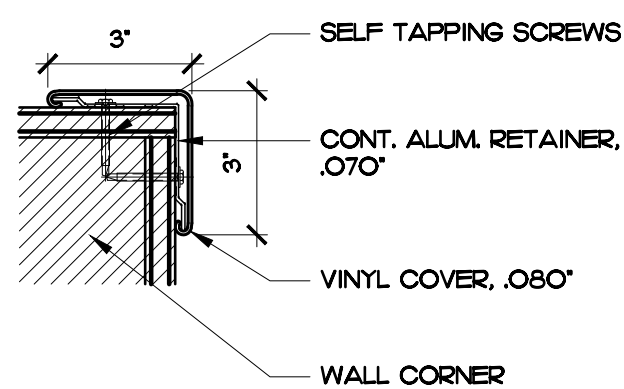

CONTRACTOR SHALL PROVIDE AND INSTALL CORNER GUARDS AS MANUFACTURED BY "INPRO CORPORATION MODEL 150BN" OR APPROVED EQUAL. INSTALL CORNER GUARDS AT HEIGHT SHOWN AT ALL KITCHEN WALLS

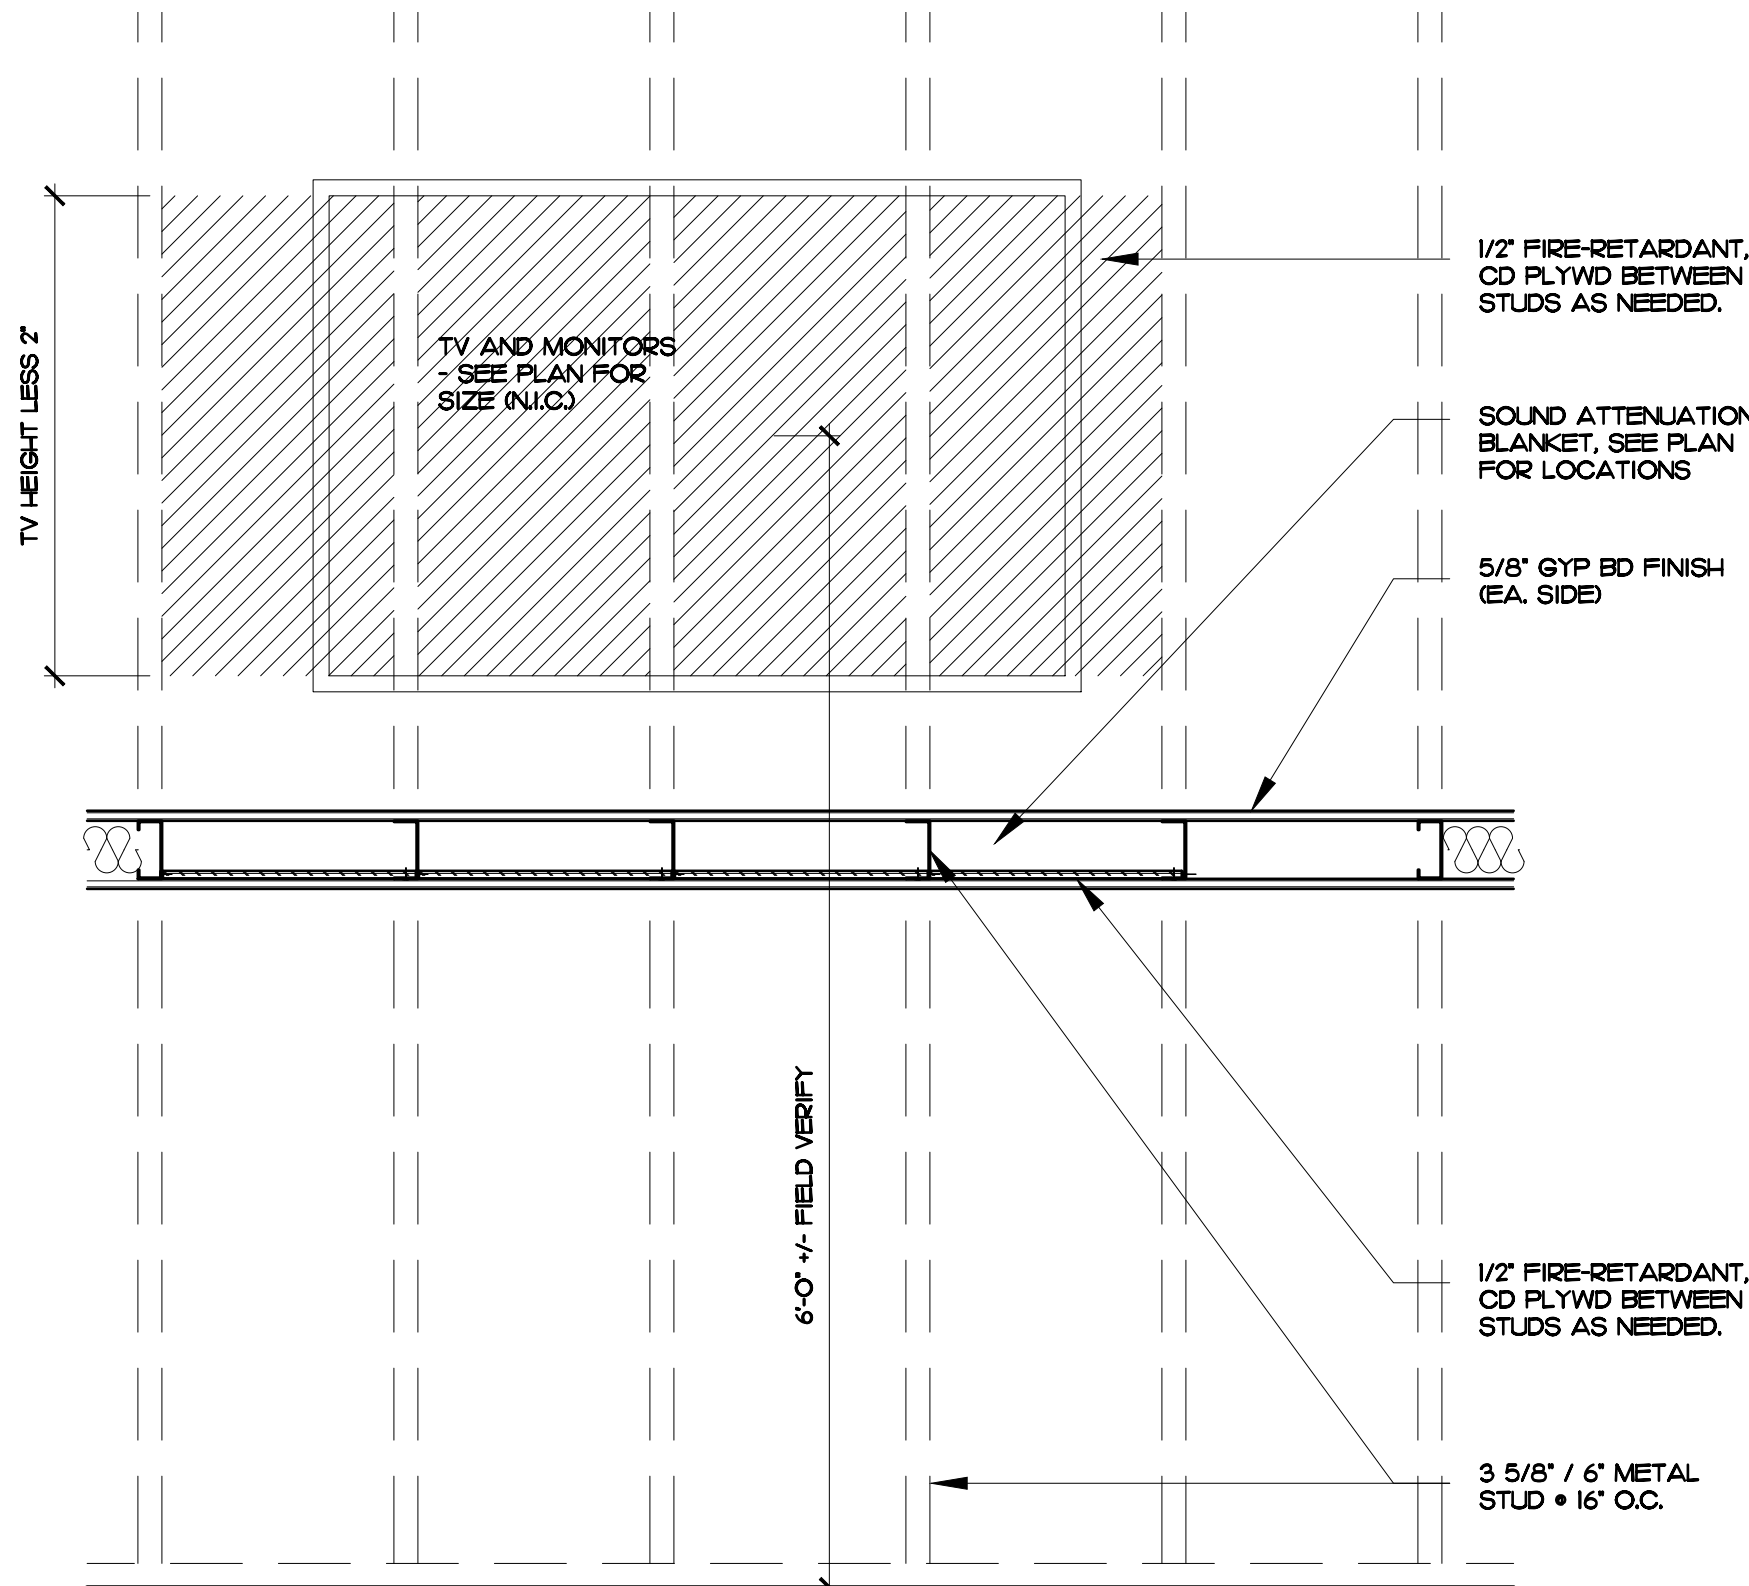

NOTE:
1. SIMILAR FOR WHITE BOARDS & BULLETIN BOARDS.
2. VERIFY WITH OWNER FOR LOCATION
3. PROVIDE FOR 1 LOCATION IN EACH MEETING ROOM AND OFFICE AND 2 IN PARISH HALL

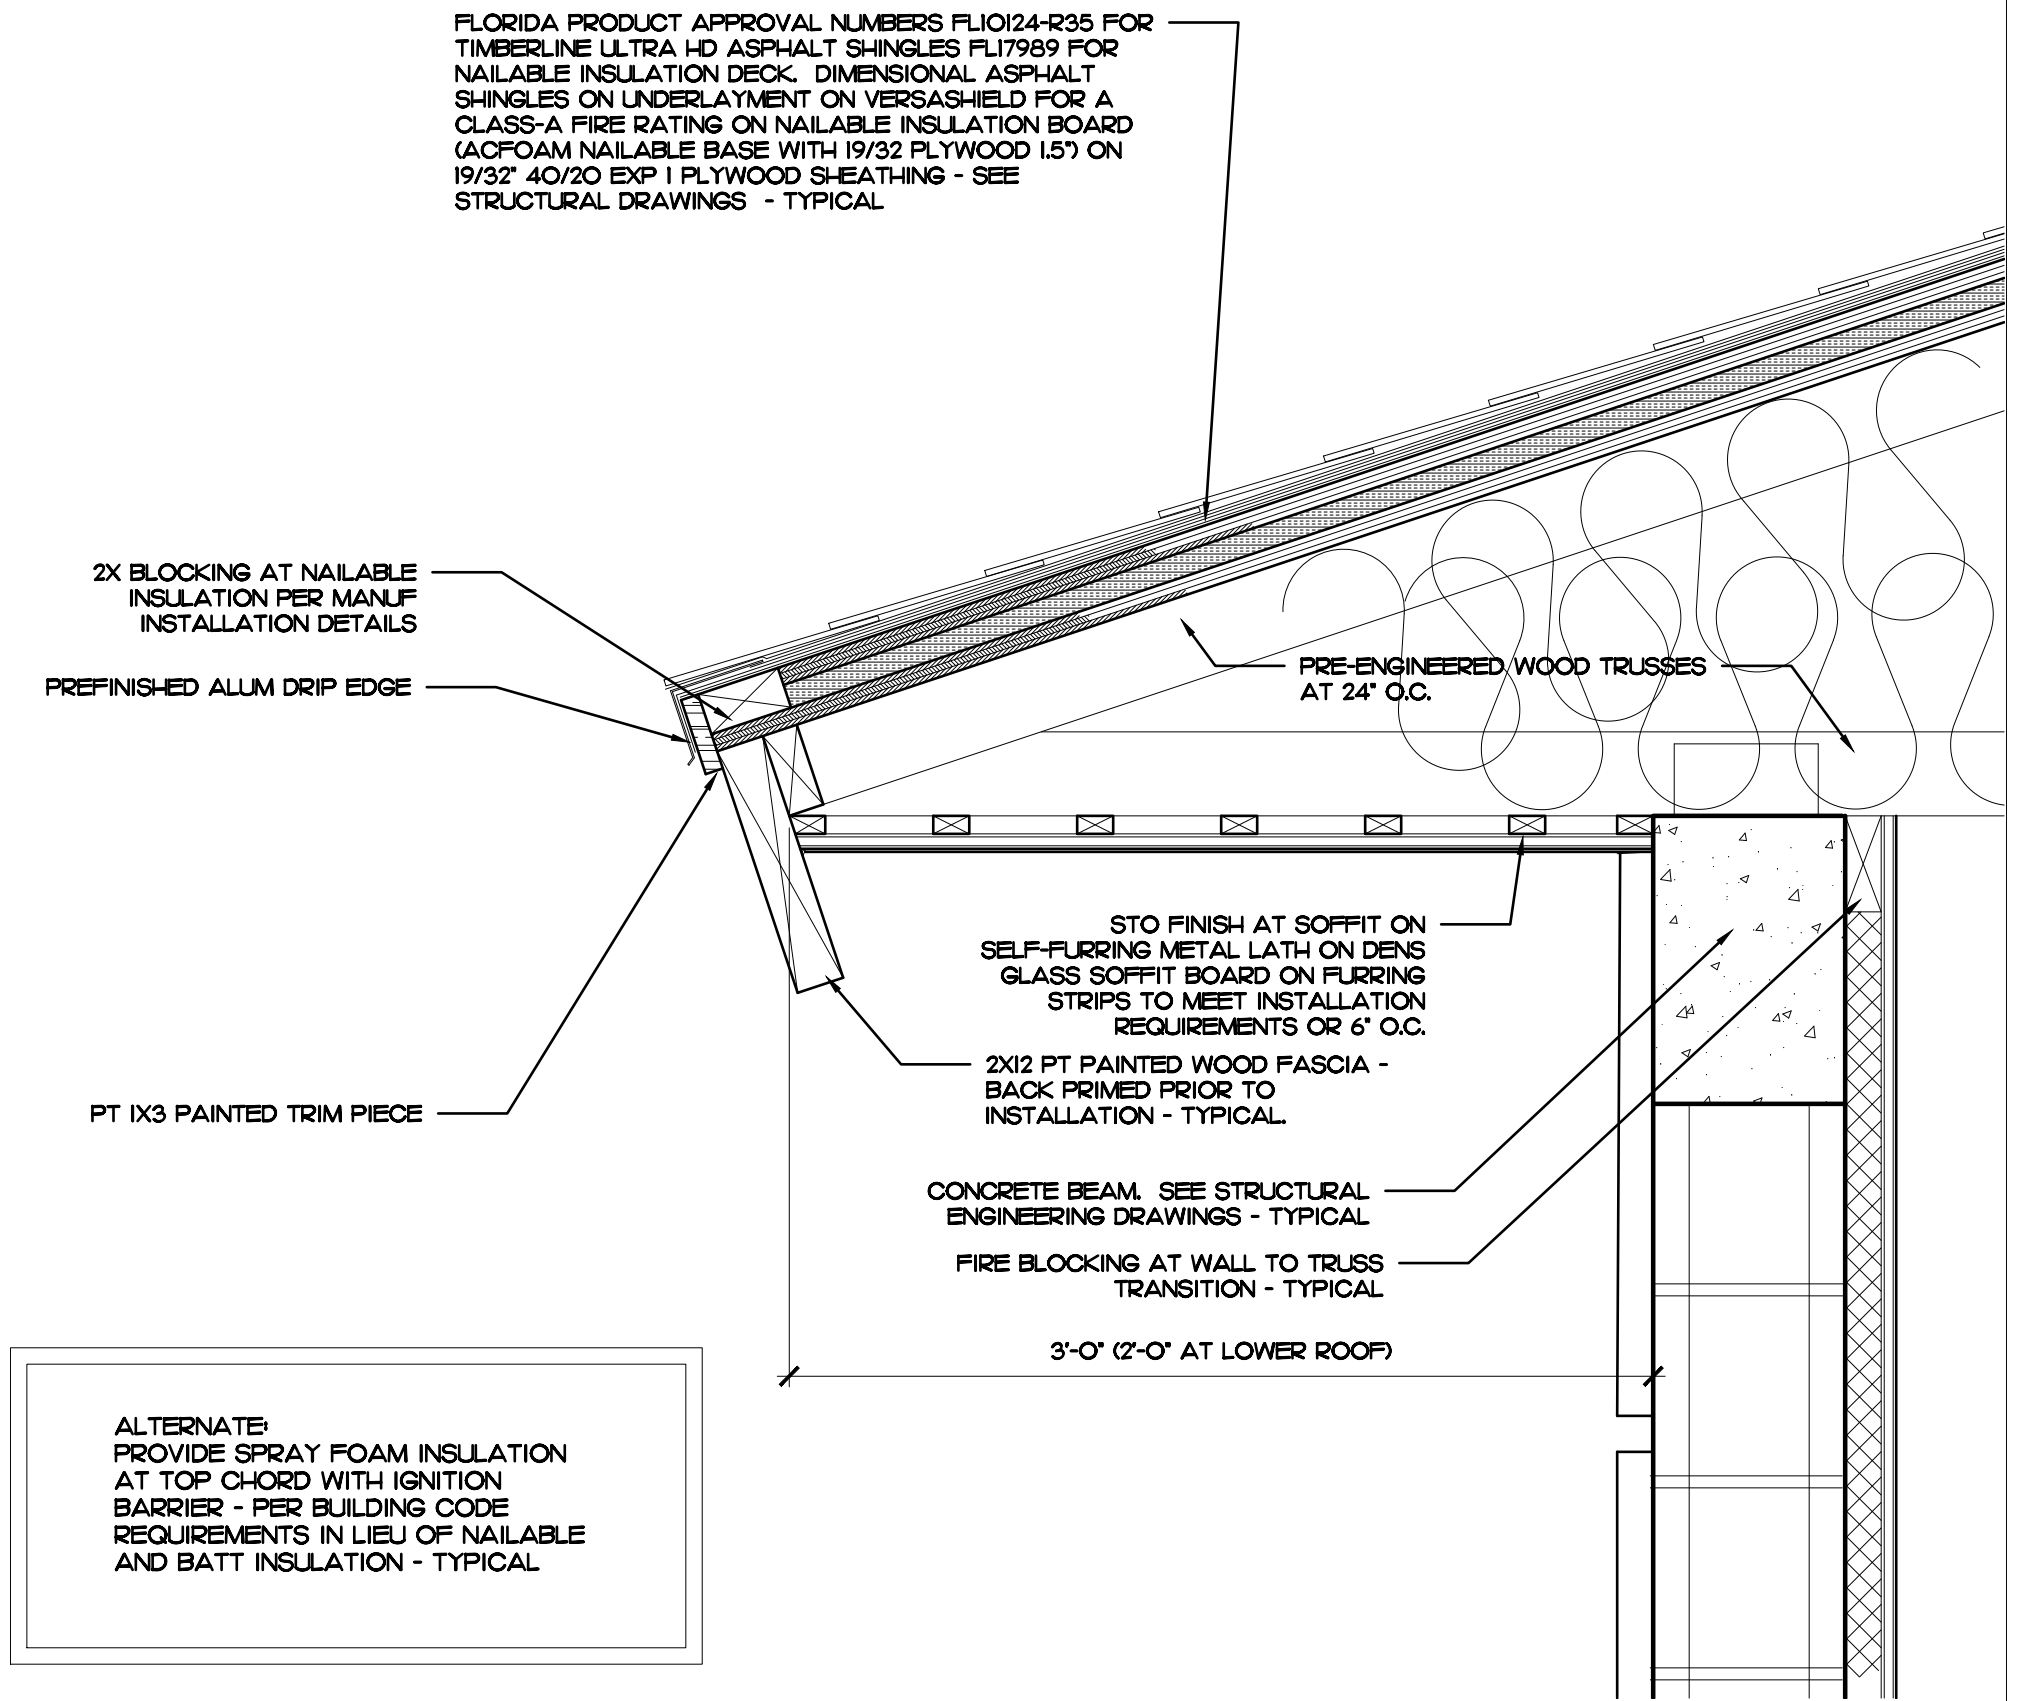

ALTERNATE:
PROVIDE SPRAY FOAM INSULATION AT TOP CHORD WITH IGNITION BARRIER - PER BUILDING CODE REQUIREMENTS IN LIEU OF NAILABLE AND BATT INSULATION - TYPICAL




WALL PROTECTION DETAILS

BACKING FOR WALL MOUNTED EQUIPMENT

ROOF EDGE DETAIL

SCALE: 1 1/2" = 1'-0"

1

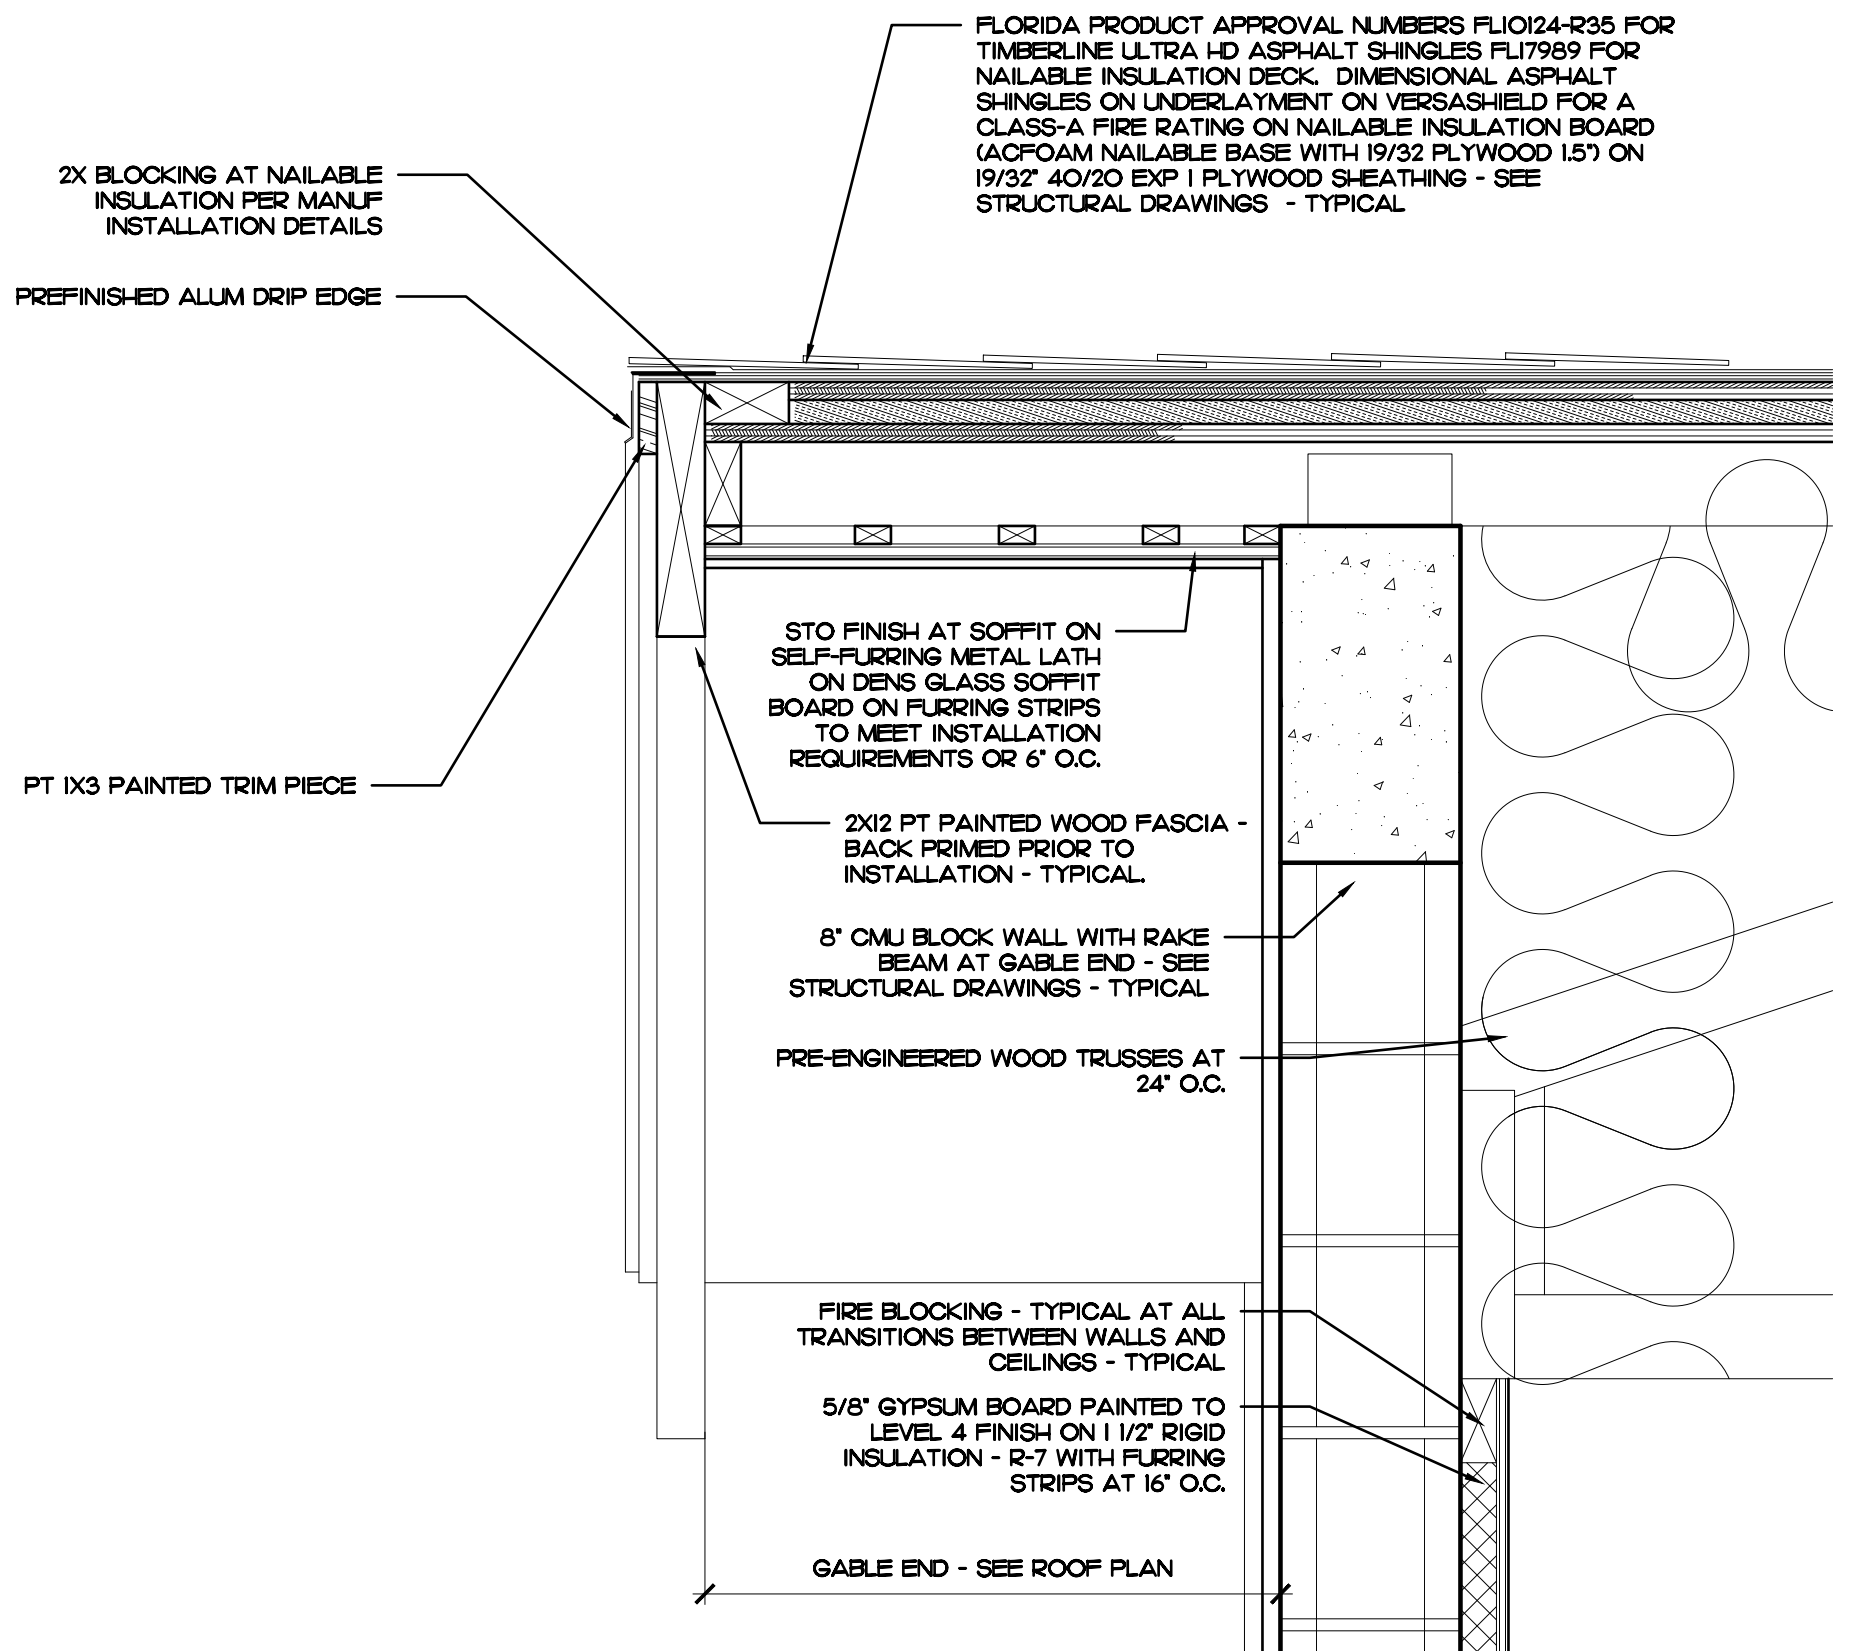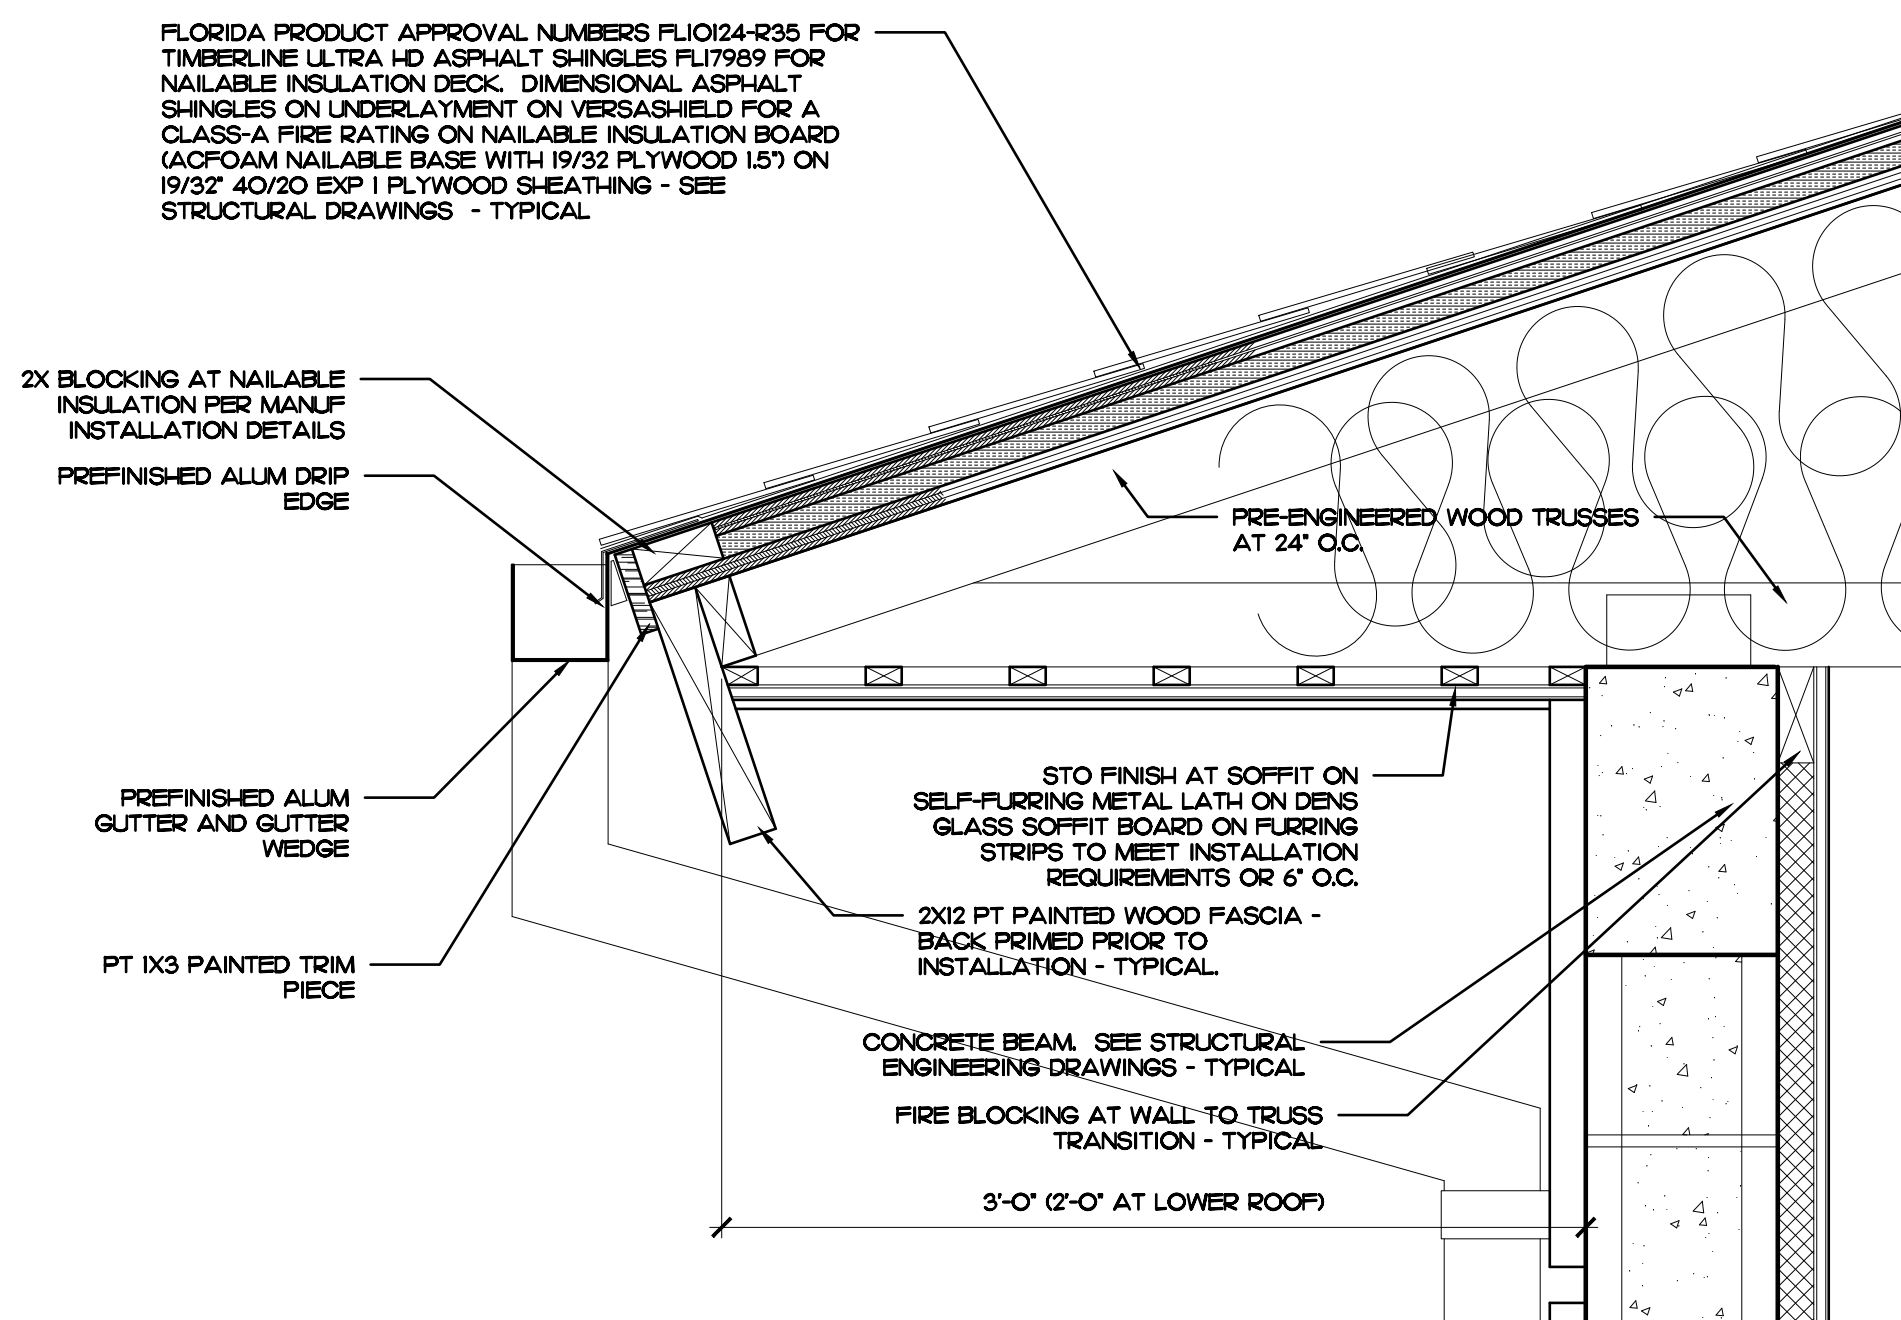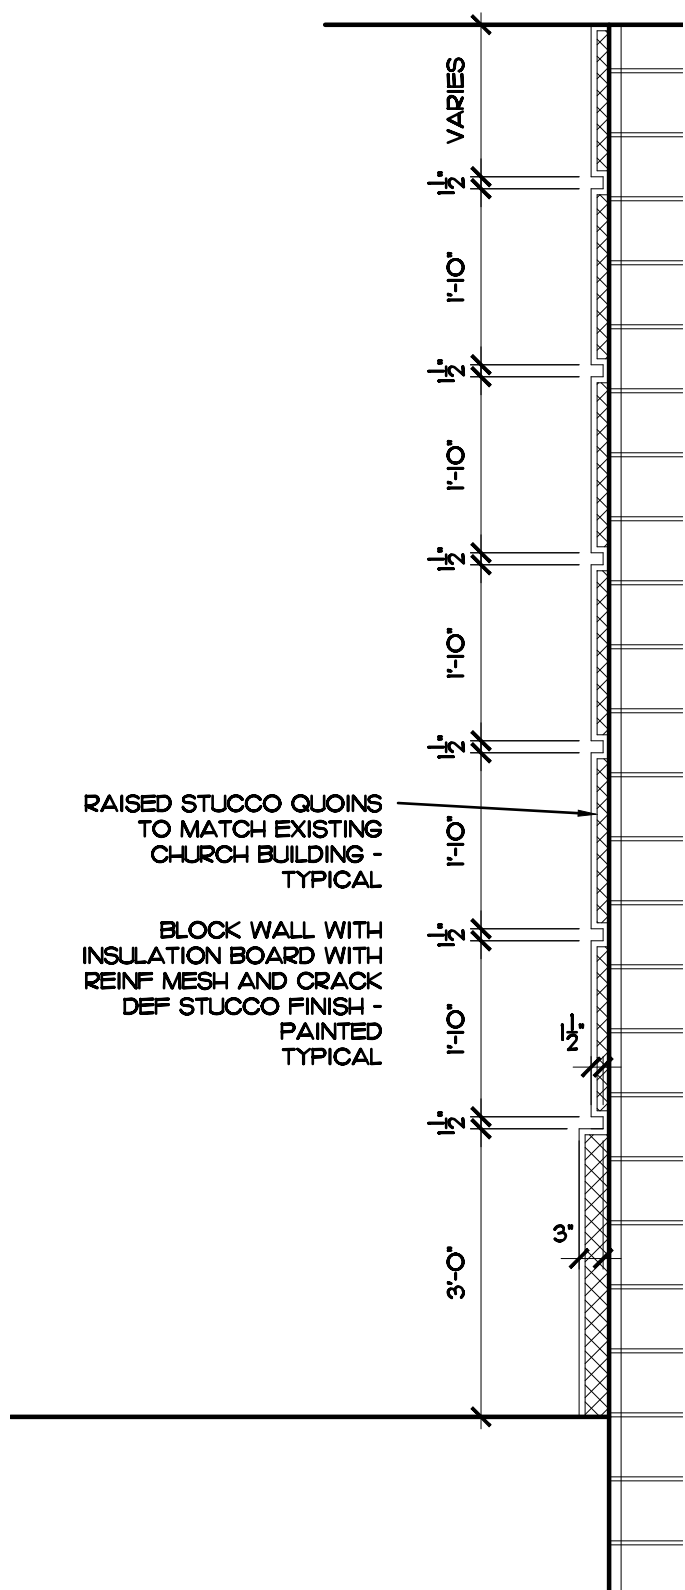

11-144-00A / P22-120

QUOIN DIMENSIONS

SCALE: 1 1/2" = 1'-0"


ROOF EDGE DETAIL

SCALE: 1 1/2" = 1'-0"


ROOF EDGE DETAIL

SCALE: 1 1/2" = 1'-0"


3

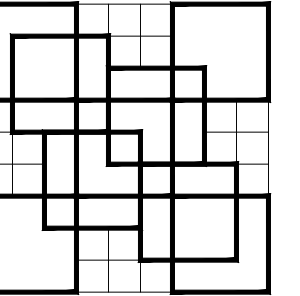

COLOME
& Associates, Inc.
AA 0003439
530 24TH STREET
WEST PALM BEACH
FLORIDA 33407
(561) 833-9147
Architect: ELIZABETH A. G. COLOME
REG. NUMBER: AR 0014839

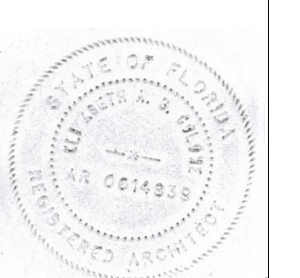

Printed copies of this document are not considered signed and sealed and the signature must be verified on any electronic copies

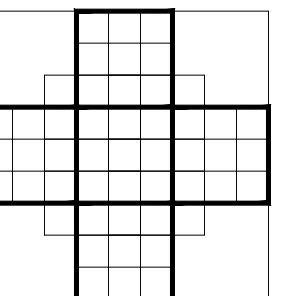


**St. Elizabeth
Ann Seton**

**New Parish Hall
Building**

930 SW Tunis Ave

PORT ST. LUCIE
FLORIDA

PROJECT NO.
202053

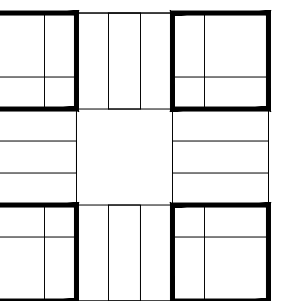

SHEET TITLE:
**EXTERIOR
ELEVATIONS**

REVISIONS:

DATE

2-15-24

DRAWN BY:

EAC

CHECKED BY:



EAC

SHEET
NUMBER:



A-9








A-10

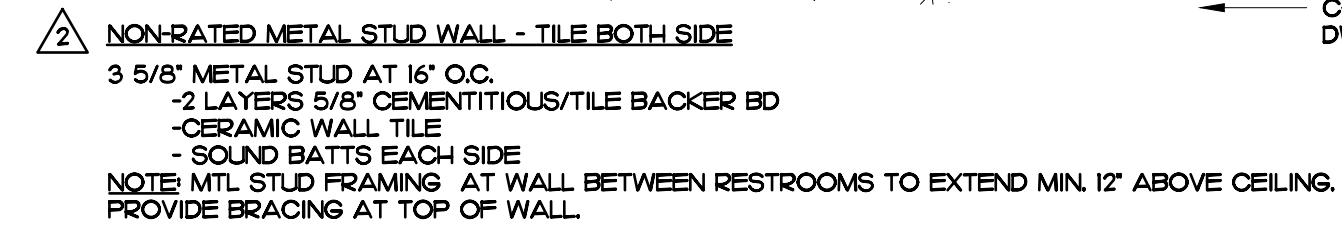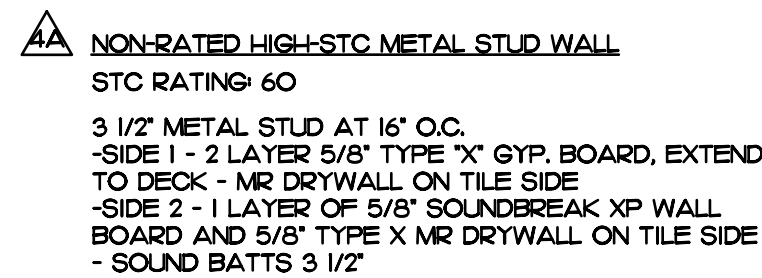


2)

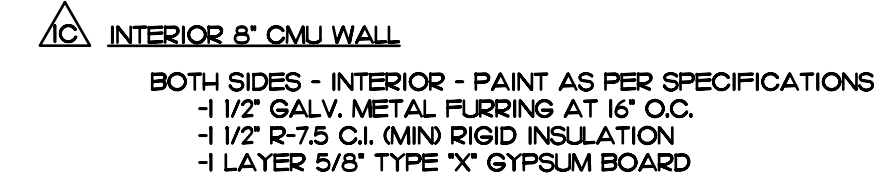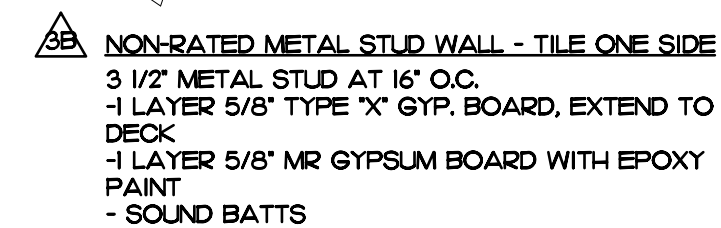

2

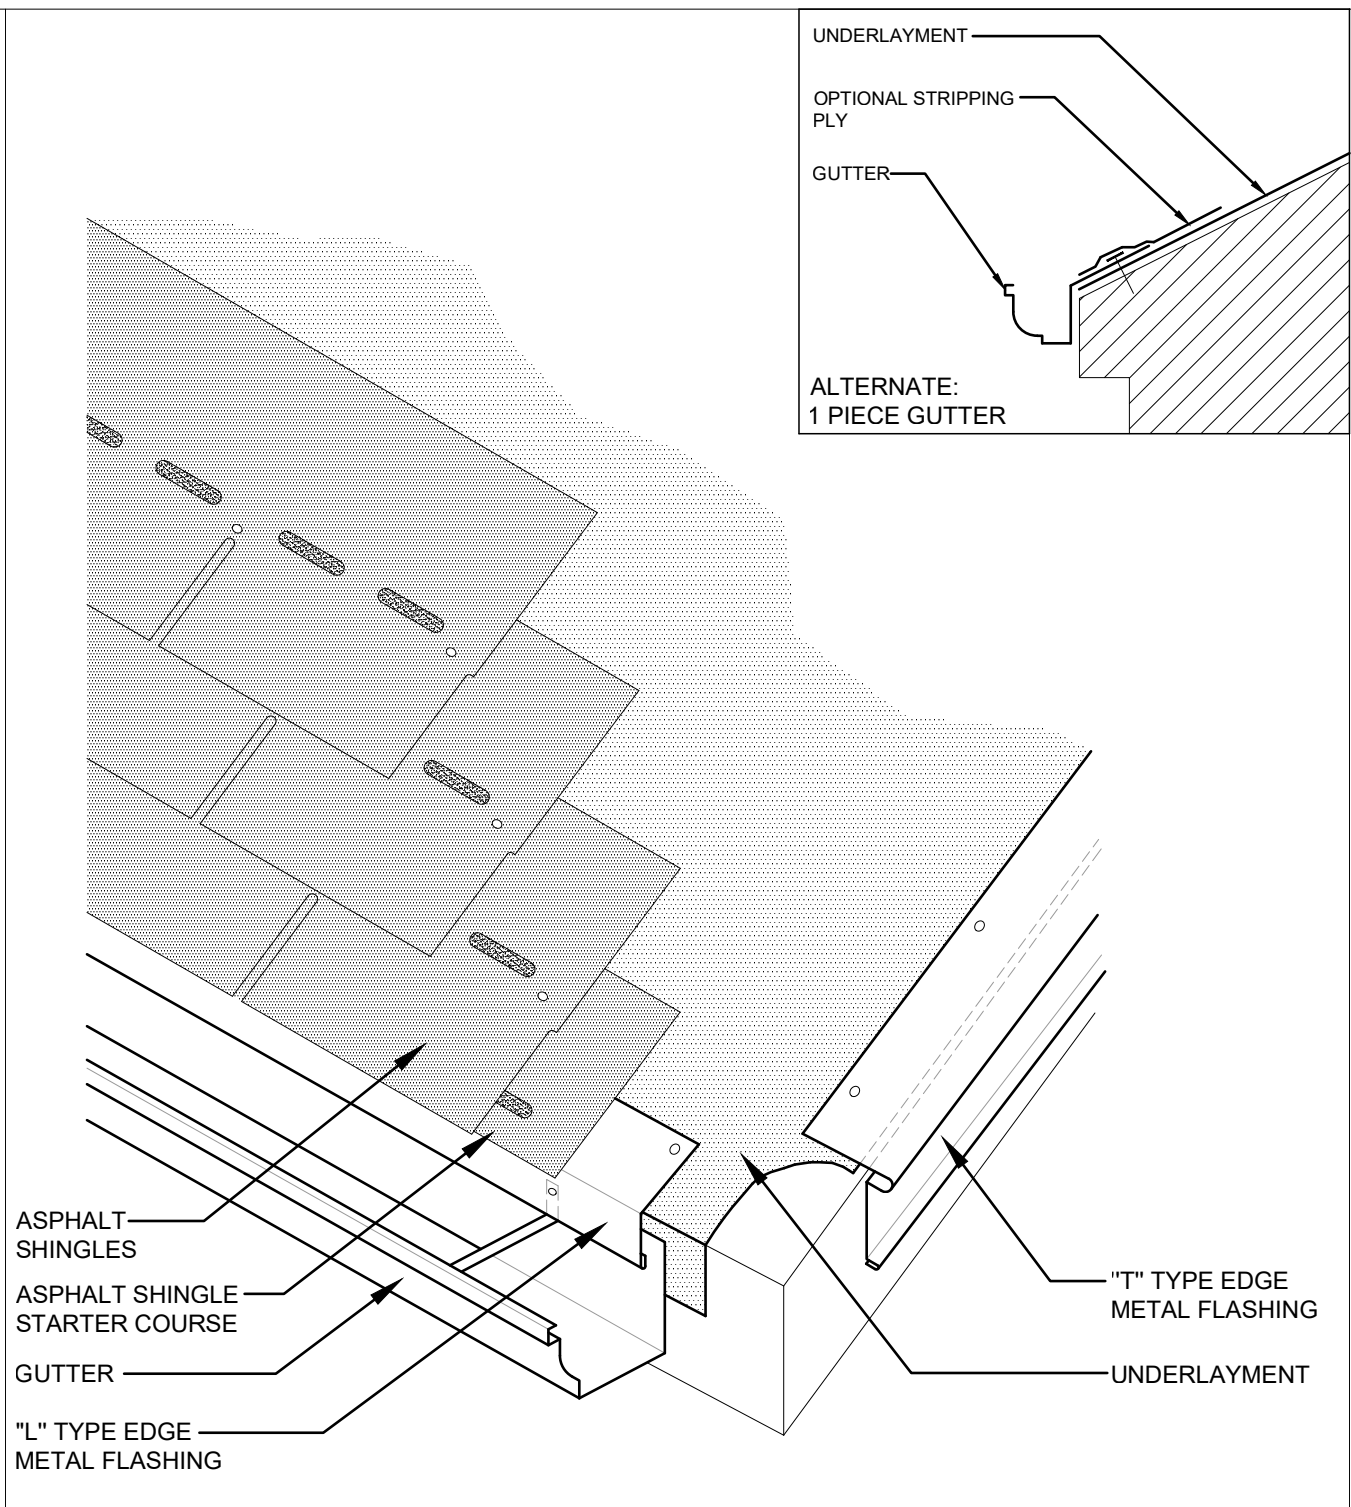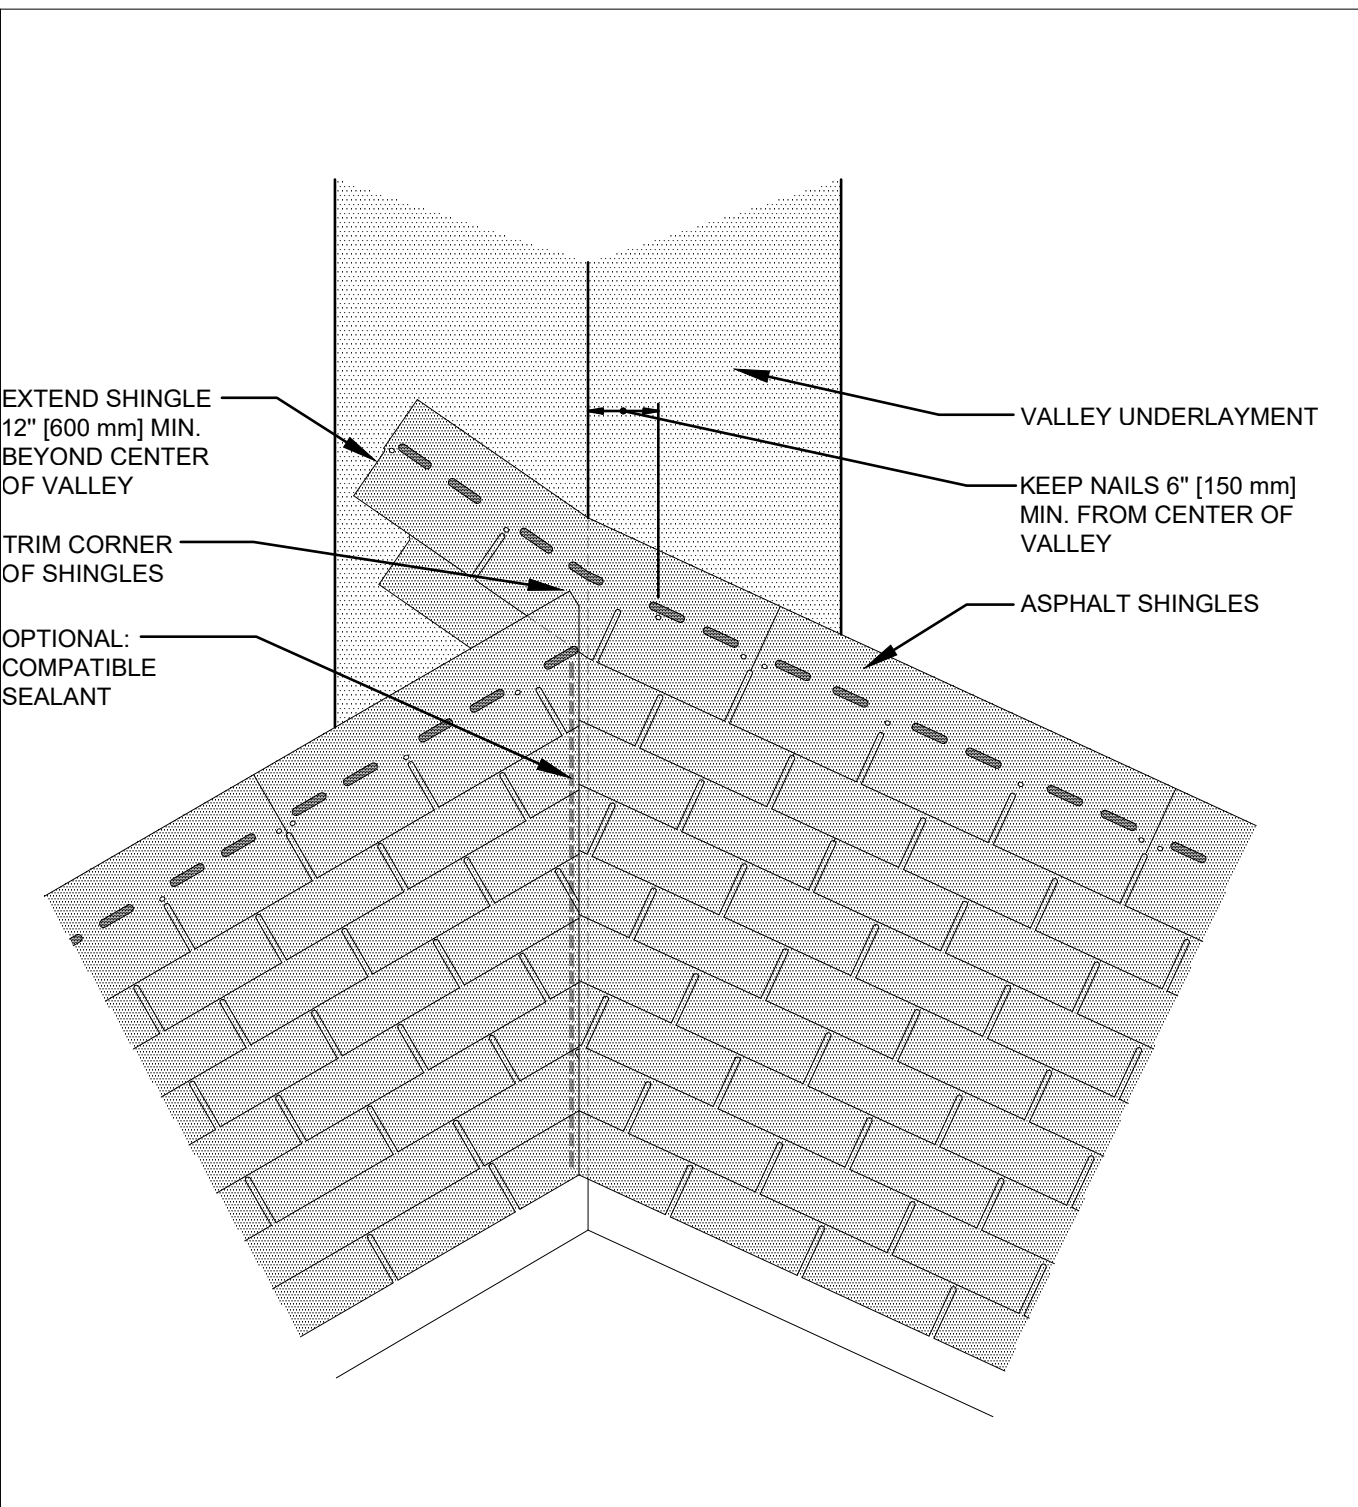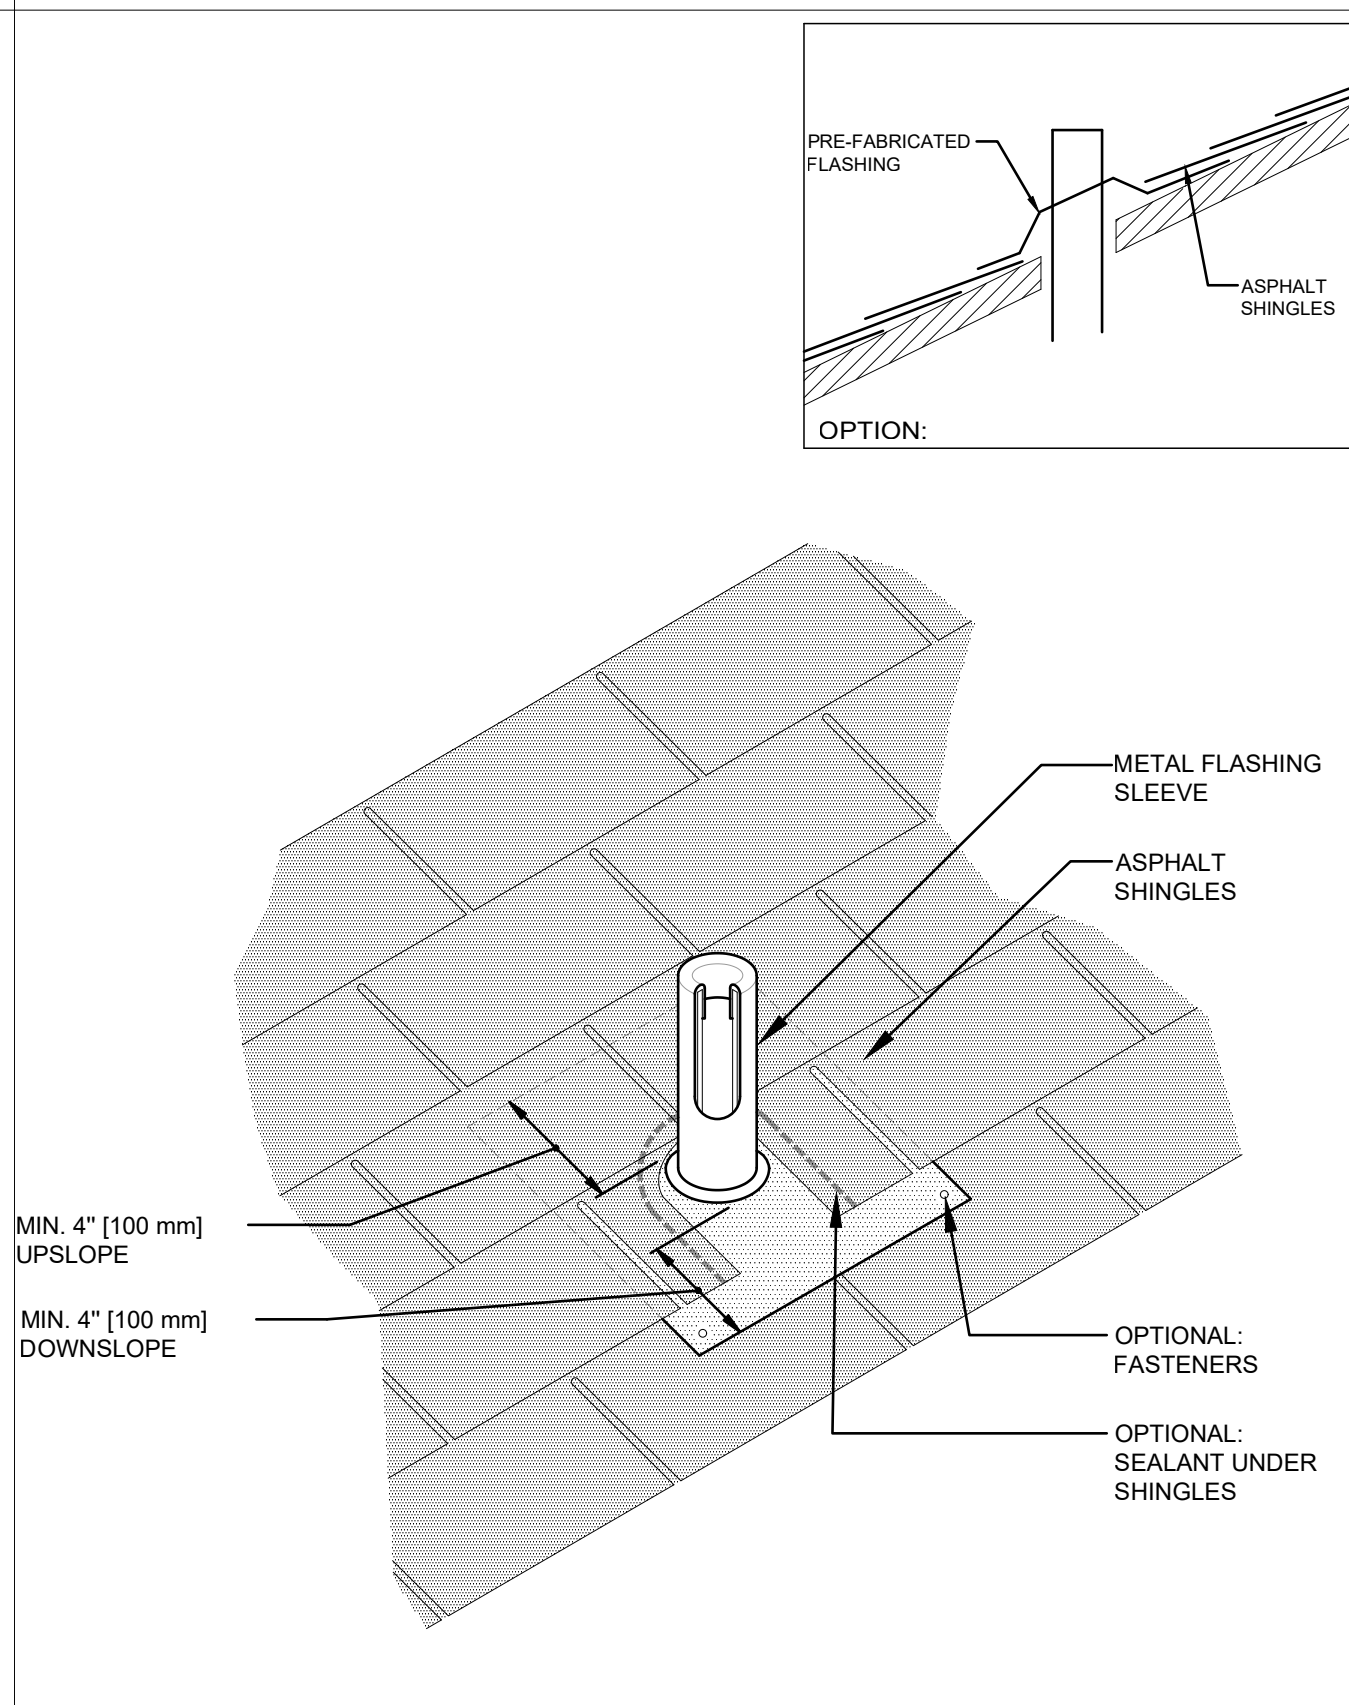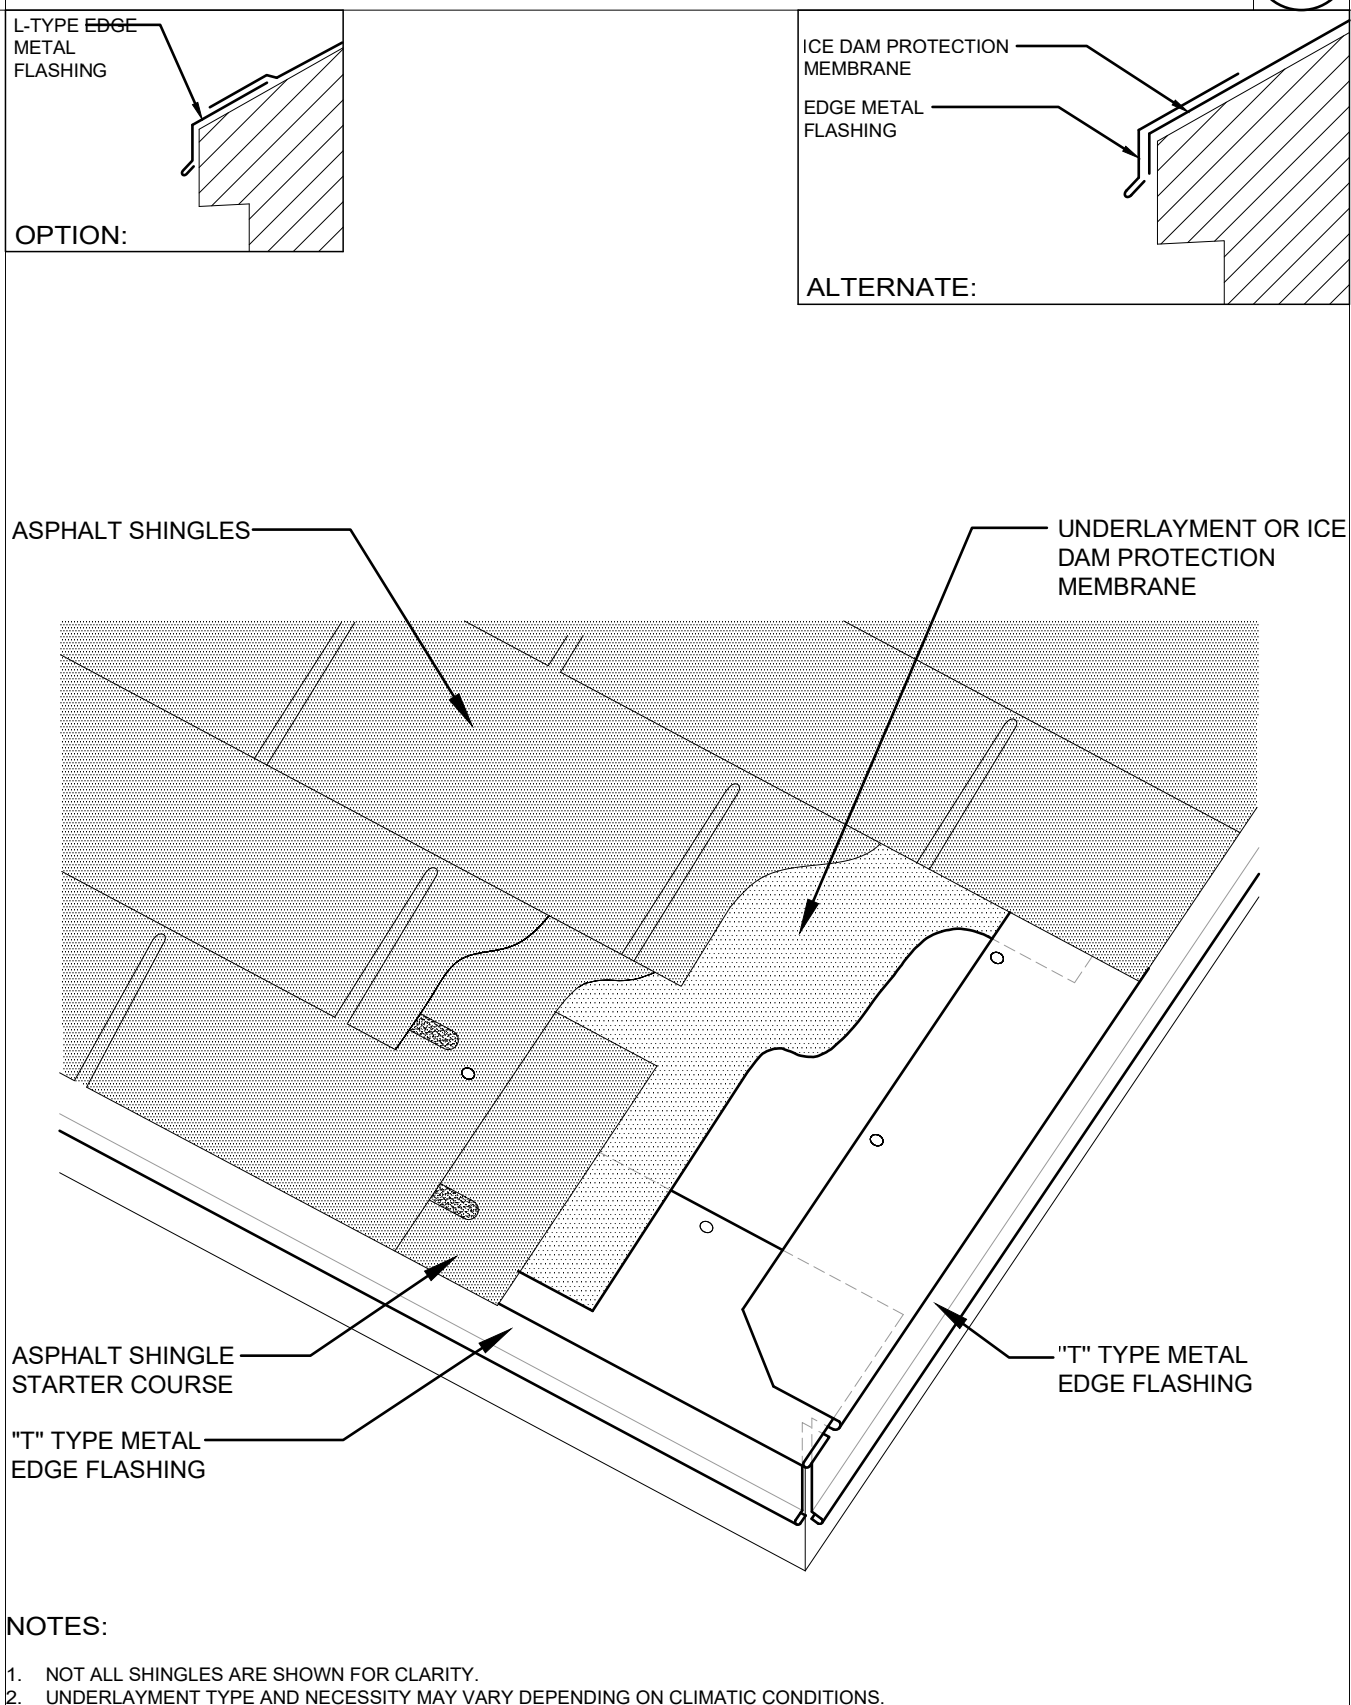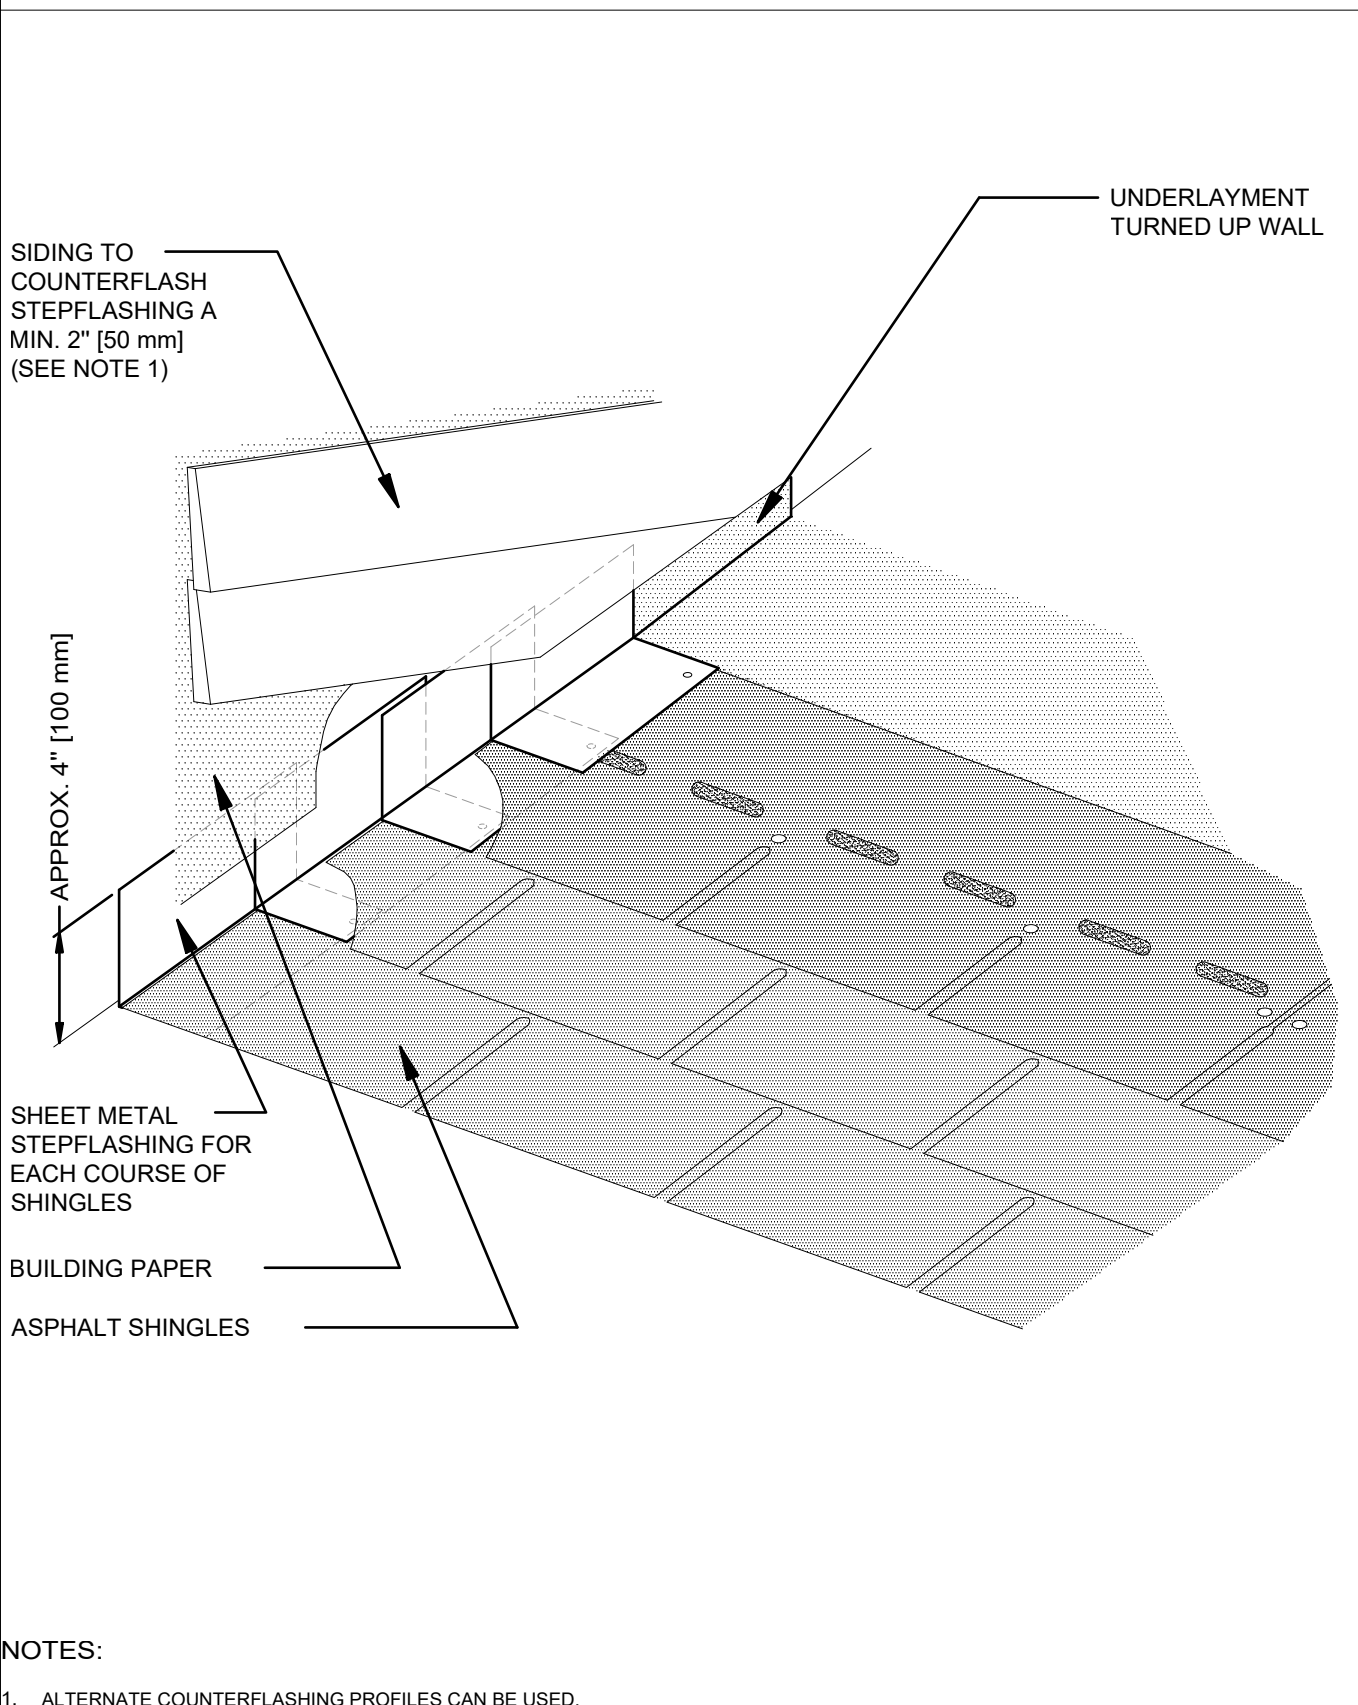		 UNDERLAYMENT OPTIONAL STRIPPING PLY GUTTER ALTERNATE: 1 PIECE GUTTER ASPHALT SHINGLES ASPHALT SHINGLE STARTER COURSE GUTTER "L" TYPE EDGE METAL FLASHING "T" TYPE EDGE METAL FLASHING UNDERLAYMENT NOTES: 1. UNDERLAYMENT CAN BE INSTALLED ON TOP OF OR UNDER THE EAVE EDGE METAL FLASHING DEPENDING ON CLIMATIC CONDITIONS. 2. UNDERLAYMENT TYPE AND NECESSITY MAY VARY DEPENDING ON CLIMATIC CONDITIONS. 3. THIS DETAIL SHOWS ONE TYPE OF GUTTER SUPPORT. GUTTER SECUREMENT AND SUPPORT OPTIONS VARY ACCORDING TO REGIONAL PRACTICES AND MANUFACTURERS SPECIFICATIONS. EAVE AND RAKE FLASHING WITH GUTTER 2001 NOT DRAWN TO SCALE ASPH-5	 EXTEND SHINGLE 12" (600 mm) MIN. BEYOND CENTER OF VALLEY TRIM CORNER OF SHINGLES OPTIONAL: COMPATIBLE SEALANT VALLEY UNDERLAYMENT KEEP NAILS 6" (150 mm) MIN. FROM CENTER OF VALLEY ASPHALT SHINGLES NOTES: 1. FIELD UNDERLAYMENT NOT SHOWN FOR CLARITY. 2. VALLEY UNDERLAYMENT TYPE AND NECESSITY MAY VARY DEPENDING ON CLIMATIC CONDITIONS. 3. THE CUT SIDE OF THE VALLEY SHOULD BE ON THE SIDE WITH THE GREATEST AREA. CLOSED CUT VALLEY 2001 NOT DRAWN TO SCALE ASPH-7	
		4	2	
	 PRE-FABRICATED FLASHING ASPHALT SHINGLES OPTION: MIN. 4" [100 mm] UPSLOPE MIN. 4" [100 mm] DOWNSLOPE METAL FLASHING SLEEVE ASPHALT SHINGLES OPTIONAL: FASTENERS OPTIONAL: SEALANT UNDER SHINGLES PIPE PENETRATION 2001 NOT DRAWN TO SCALE ASPH-8	 L-TYPE EDGE METAL FLASHING OPTION: ICE DAM PROTECTION MEMBRANE EDGE METAL FLASHING ALTERNATE: ASPHALT SHINGLES UNDERLAYMENT OR ICE DAM PROTECTION MEMBRANE ASPHALT SHINGLE STARTER COURSE "T" TYPE METAL EDGE FLASHING NOTES: 1. NOT ALL SHINGLES ARE SHOWN FOR CLARITY. 2. UNDERLAYMENT TYPE AND NECESSITY MAY VARY DEPENDING ON CLIMATIC CONDITIONS. EAVE AND RAKE FLASHING 2001 NOT DRAWN TO SCALE ASPH-4	 SIDING TO COUNTERFLASH STEPFLASHING A MIN. 2" [50 mm] (SEE NOTE 1) UNDERLAYMENT TURNED UP WALL APPROX. 4" [100 mm] SHEET METAL STEPFLASHING FOR EACH COURSE OF SHINGLES BUILDING PAPER ASPHALT SHINGLES NOTES: 1. ALTERNATE COUNTERFLASHING PROFILES CAN BE USED. SIDEWALL FLASHING 2001 NOT DRAWN TO SCALE ASPH-2	
		5	3	1
11-144-00A / P22-120				


ROOF DETAILS

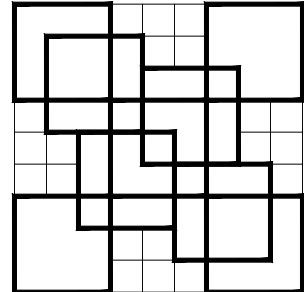

COLOME
& Associates, Inc.
AA 0003439
530 24TH STREET
WEST PALM BEACH
FLORIDA 33407
(561) 833-9147
Architect: ELIZABETH A. G. COLOME
REG. NUMBER: AR 0014839



Printed copies of this document are not considered signed and sealed and the signature must be verified on any electronic copies

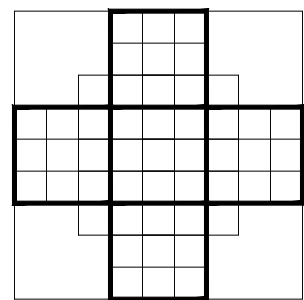



**St. Elizabeth
Ann Seton**

**New Parish Hall
Building**

930 SW Tunis Ave

PORT ST. LUCIE
FLORIDA

 PROJECT NO.
202053

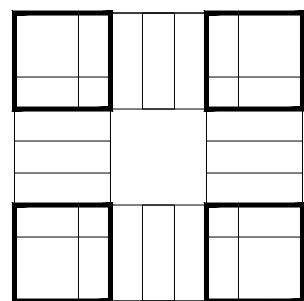


SHEET TITLE:
ROOF DETAILS

REVISIONS:


DATE
2-15-24
DRAWN BY:
EAC
CHECKED BY:
EAC

SHEET
NUMBER:



A-11

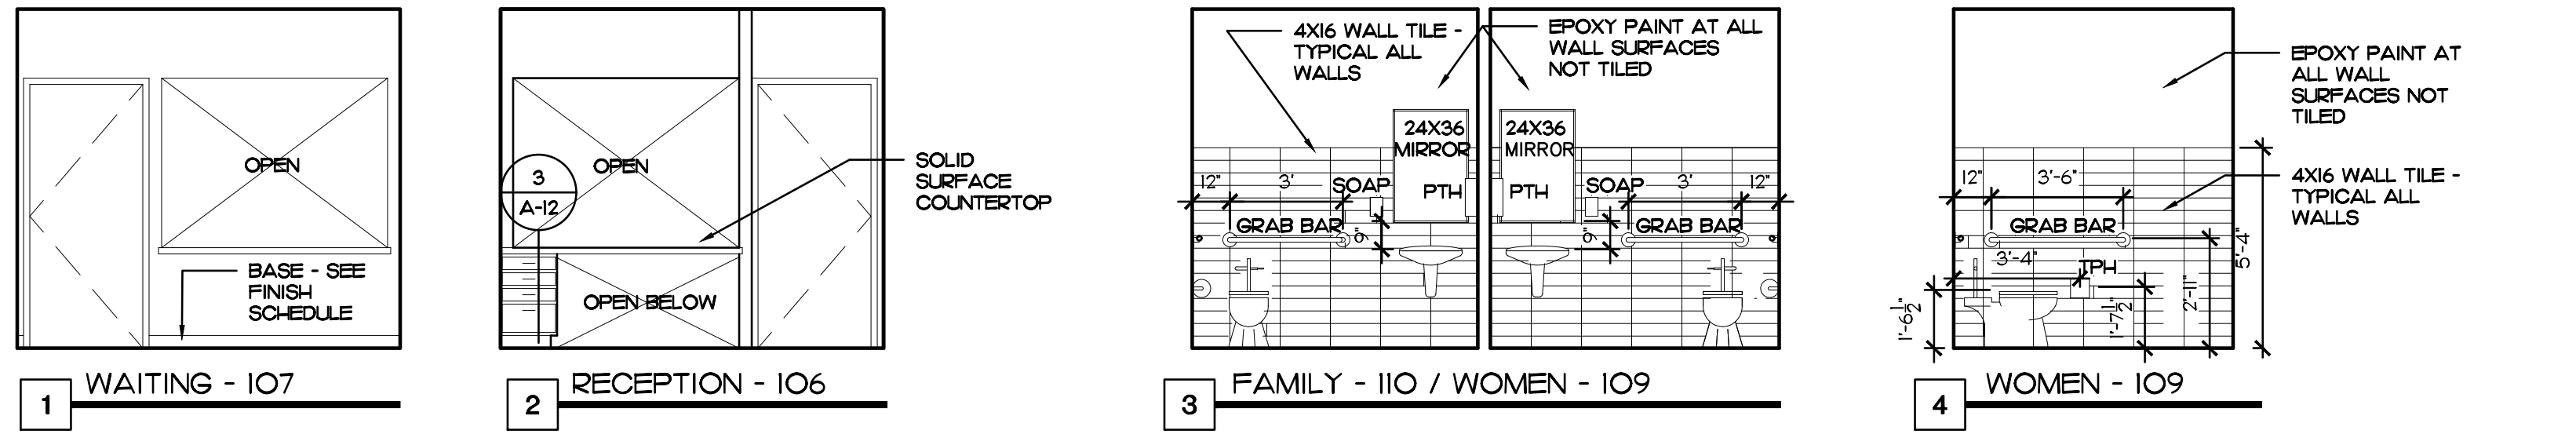

INTERIOR ELEVATIONS

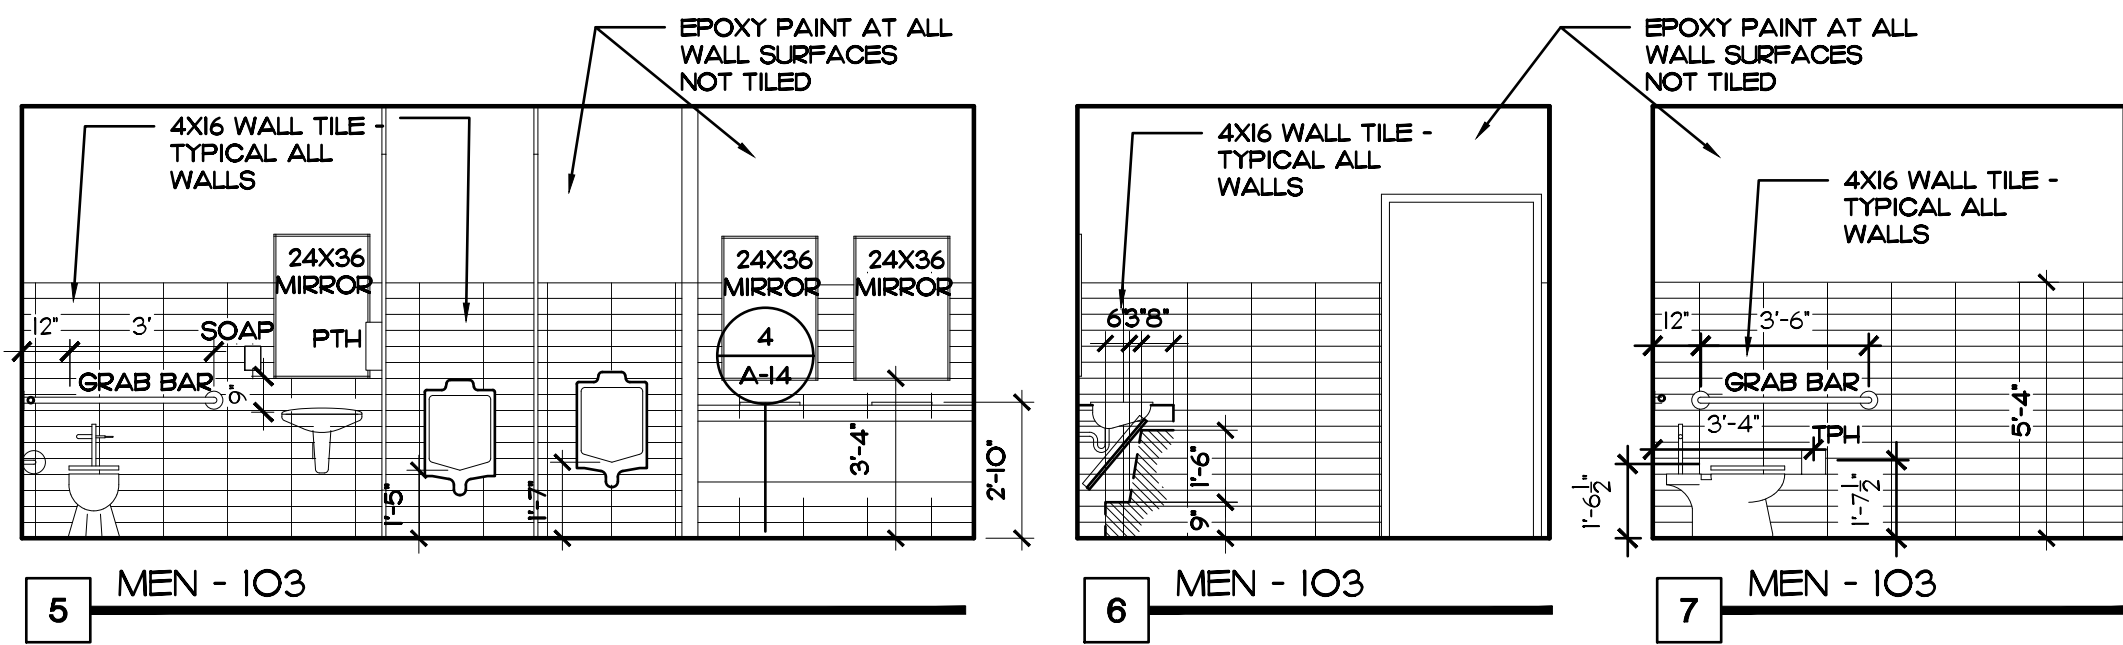


INTERIOR ELEVATIONS

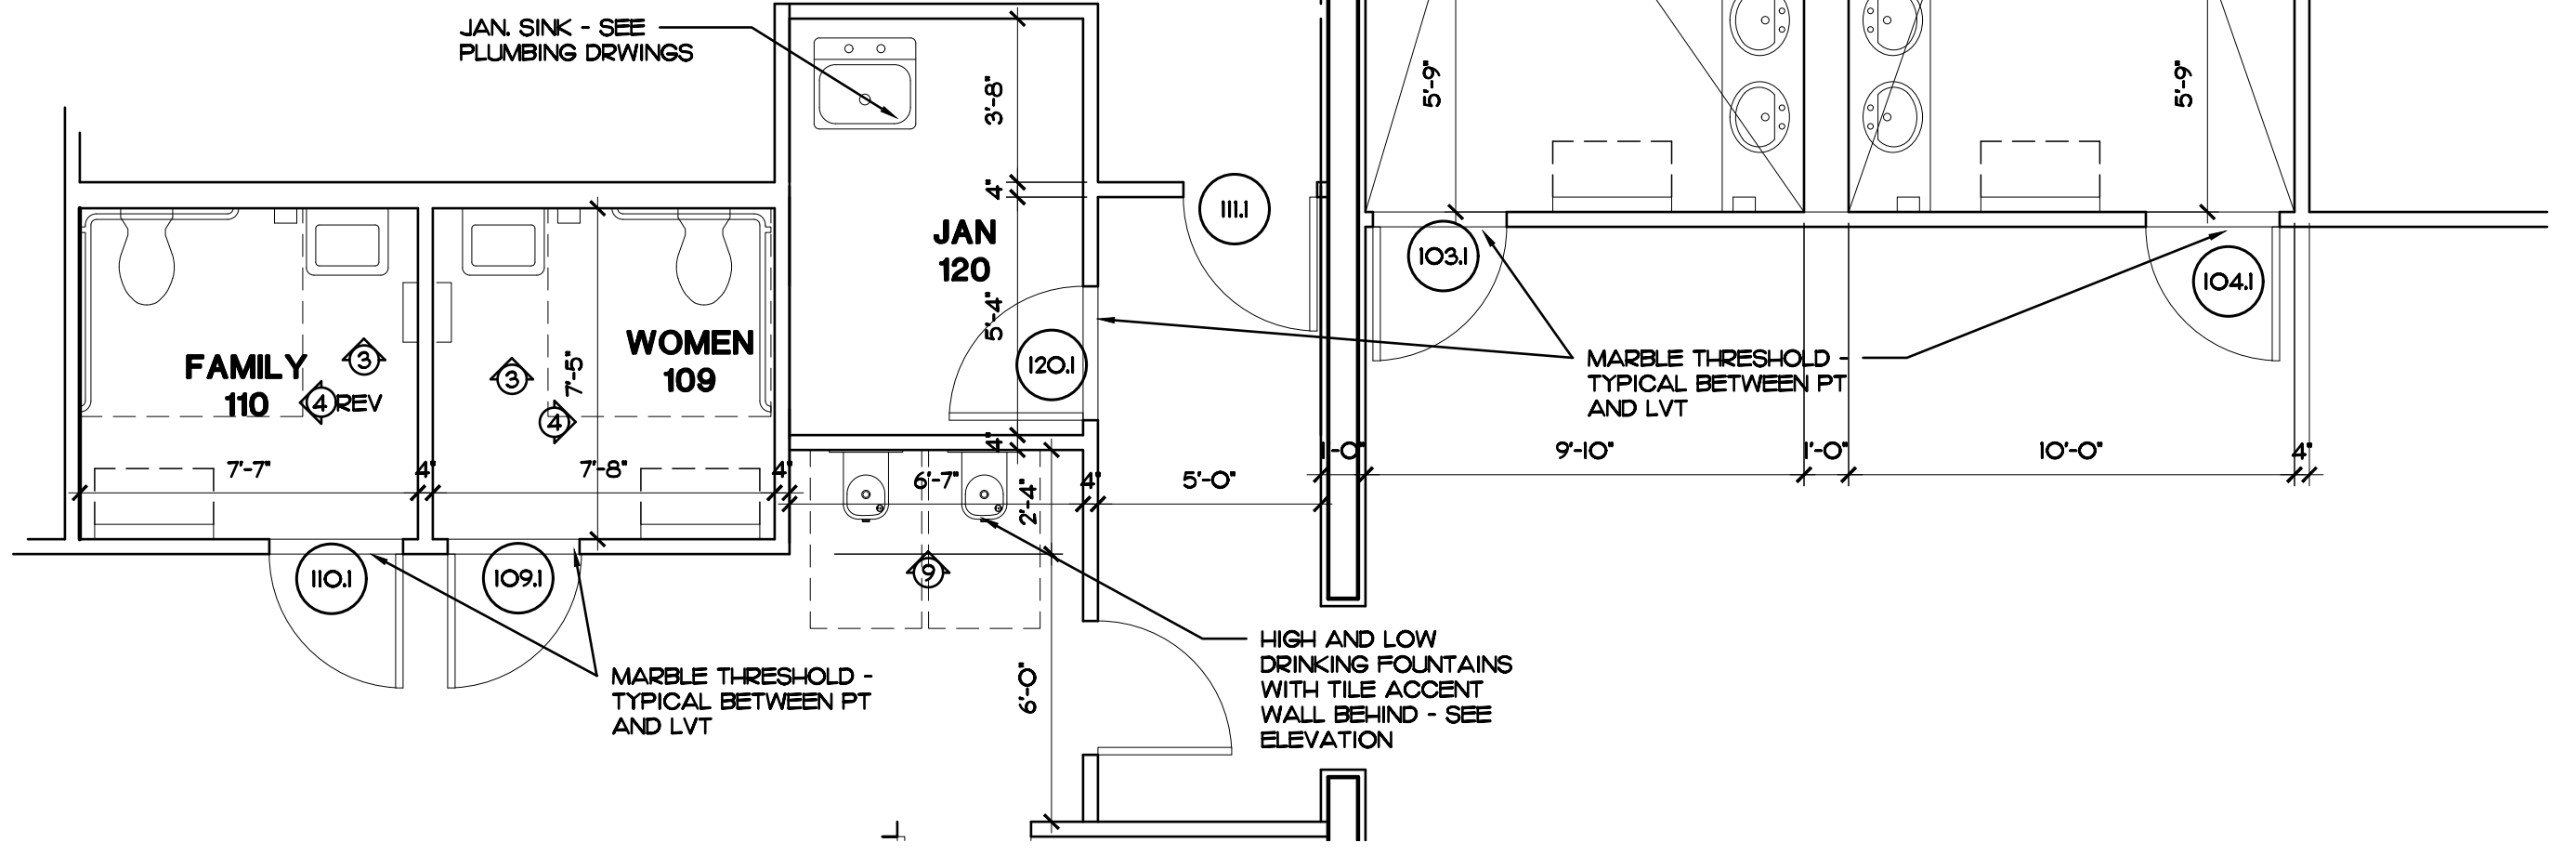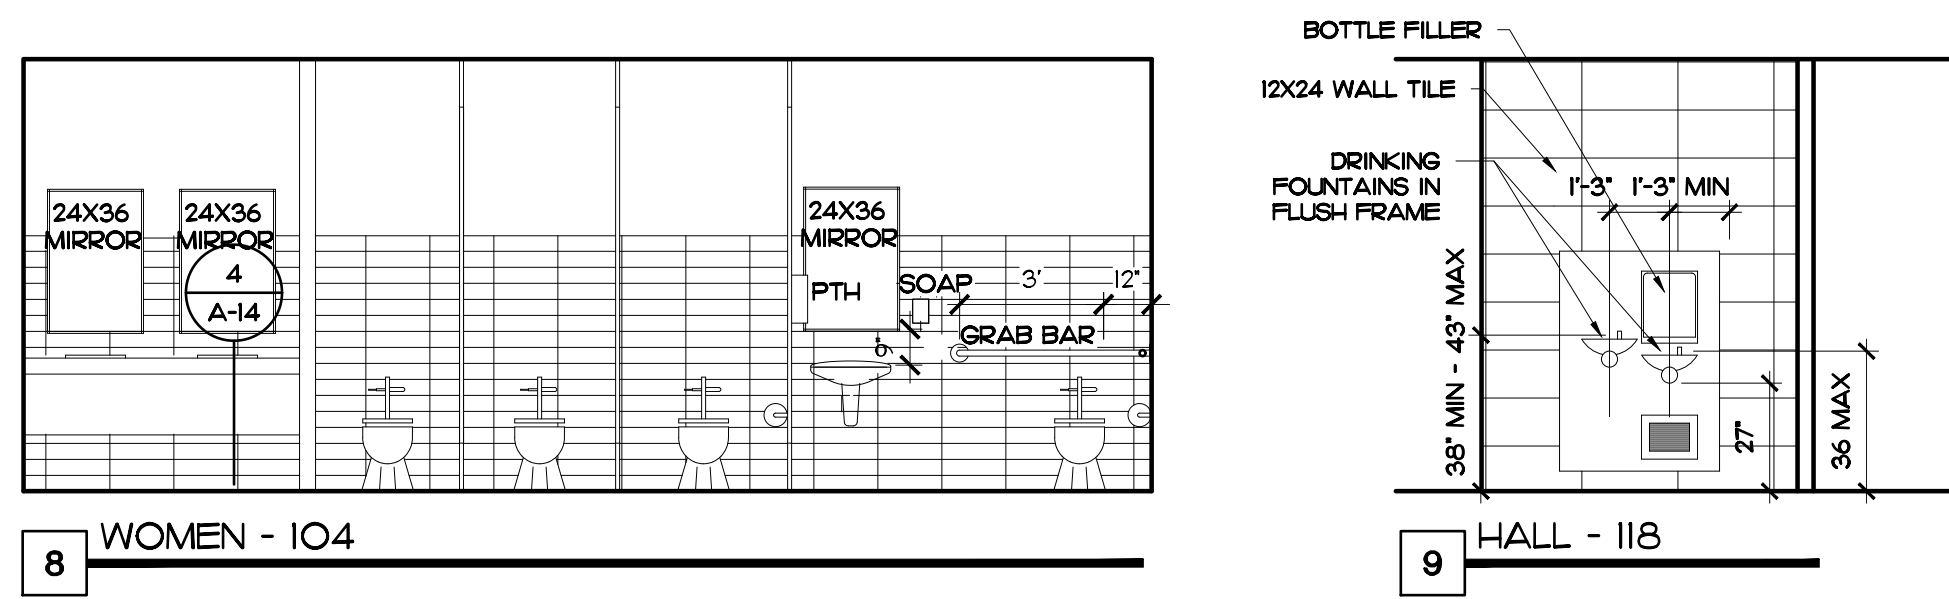

INTERIOR ELEVATIONS


ENLARGED FLOOR PLAN

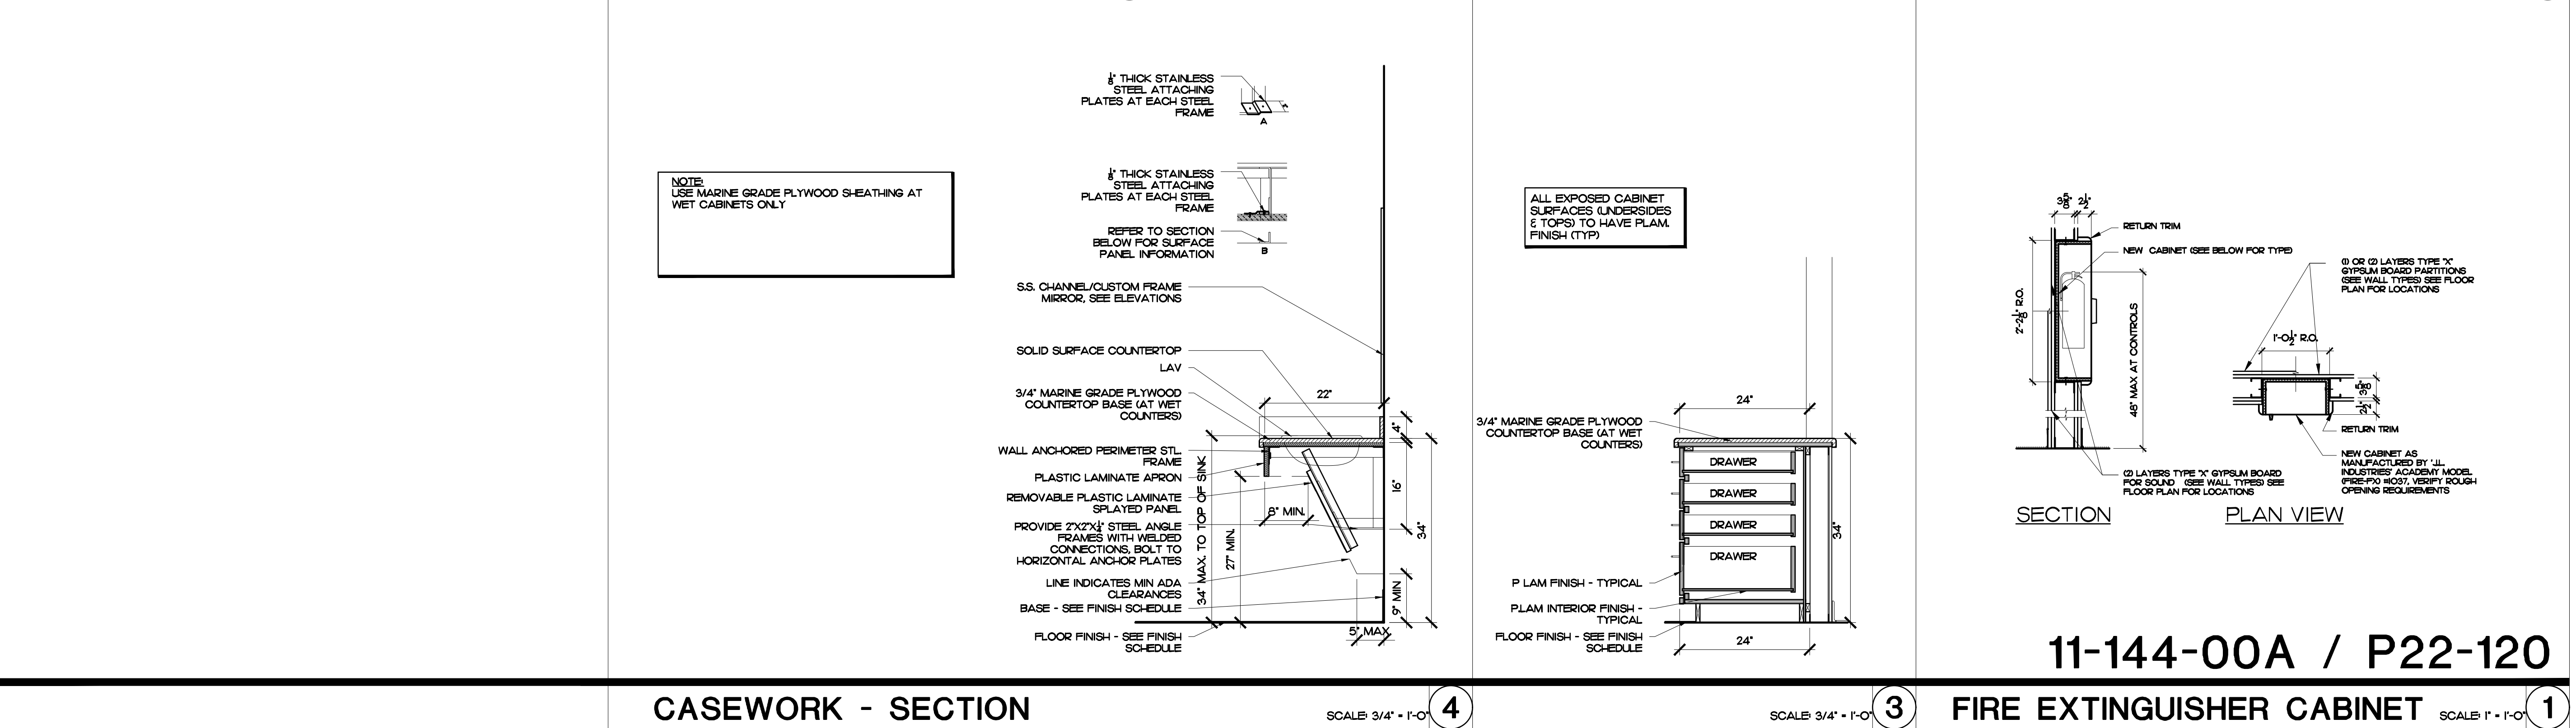

COLOME & Associates, Inc.
AA 0003439
530 24TH STREET
WEST PALM BEACH
FLORIDA 33407
(561) 833-9147
Architect: ELIZABETH A. G. COLOME
REG. NUMBER: AR 0014839



Printed copies of this document are not considered signed and sealed and the signature must be verified on any electronic copies

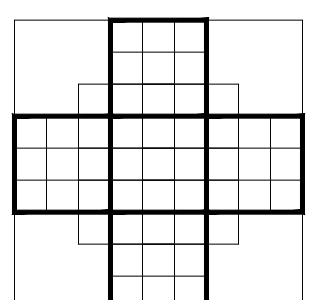



St. Elizabeth Ann Seton

New Parish Hall Building

930 SW Tunis Ave

PORT ST. LUCIE
FLORIDA

 PROJECT NO.
202053

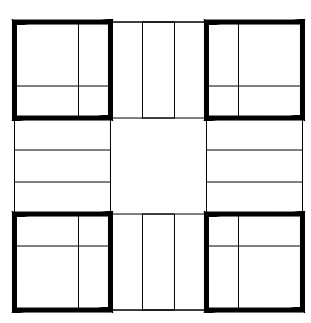


SHEET TITLE:
INTERIOR
ELEVATIONS

REVISIONS:

DATE
2-15-24
DRAWN BY:
EAC
CHECKED BY:
EAC

SHEET
NUMBER:


A-12

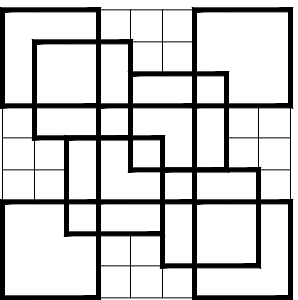

COLOME & Associates, Inc.
AA 0003439
530 24TH STREET
WEST PALM BEACH
FLORIDA 33407
(561) 833-9147
Architect: ELIZABETH A. G. COLOME
REG. NUMBER: AR 0014839



Printed copies of this document are not considered signed and sealed and the signature must be verified on any electronic copies

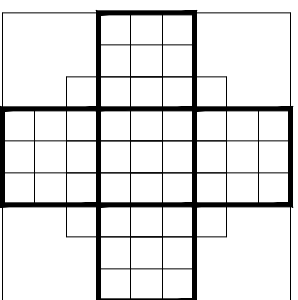



St. Elizabeth Ann Seton

New Parish Hall Building

930 SW Tunis Ave

PORT ST. LUCIE
FLORIDA

 PROJECT NO.
202053

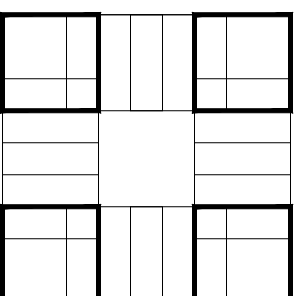


SHEET TITLE:
DOOR AND WINDOW DETAILS

REVISIONS:

DATE
2-15-24
DRAWN BY:
EAC
CHECKED BY:
EAC


SHEET
NUMBER:

A-14

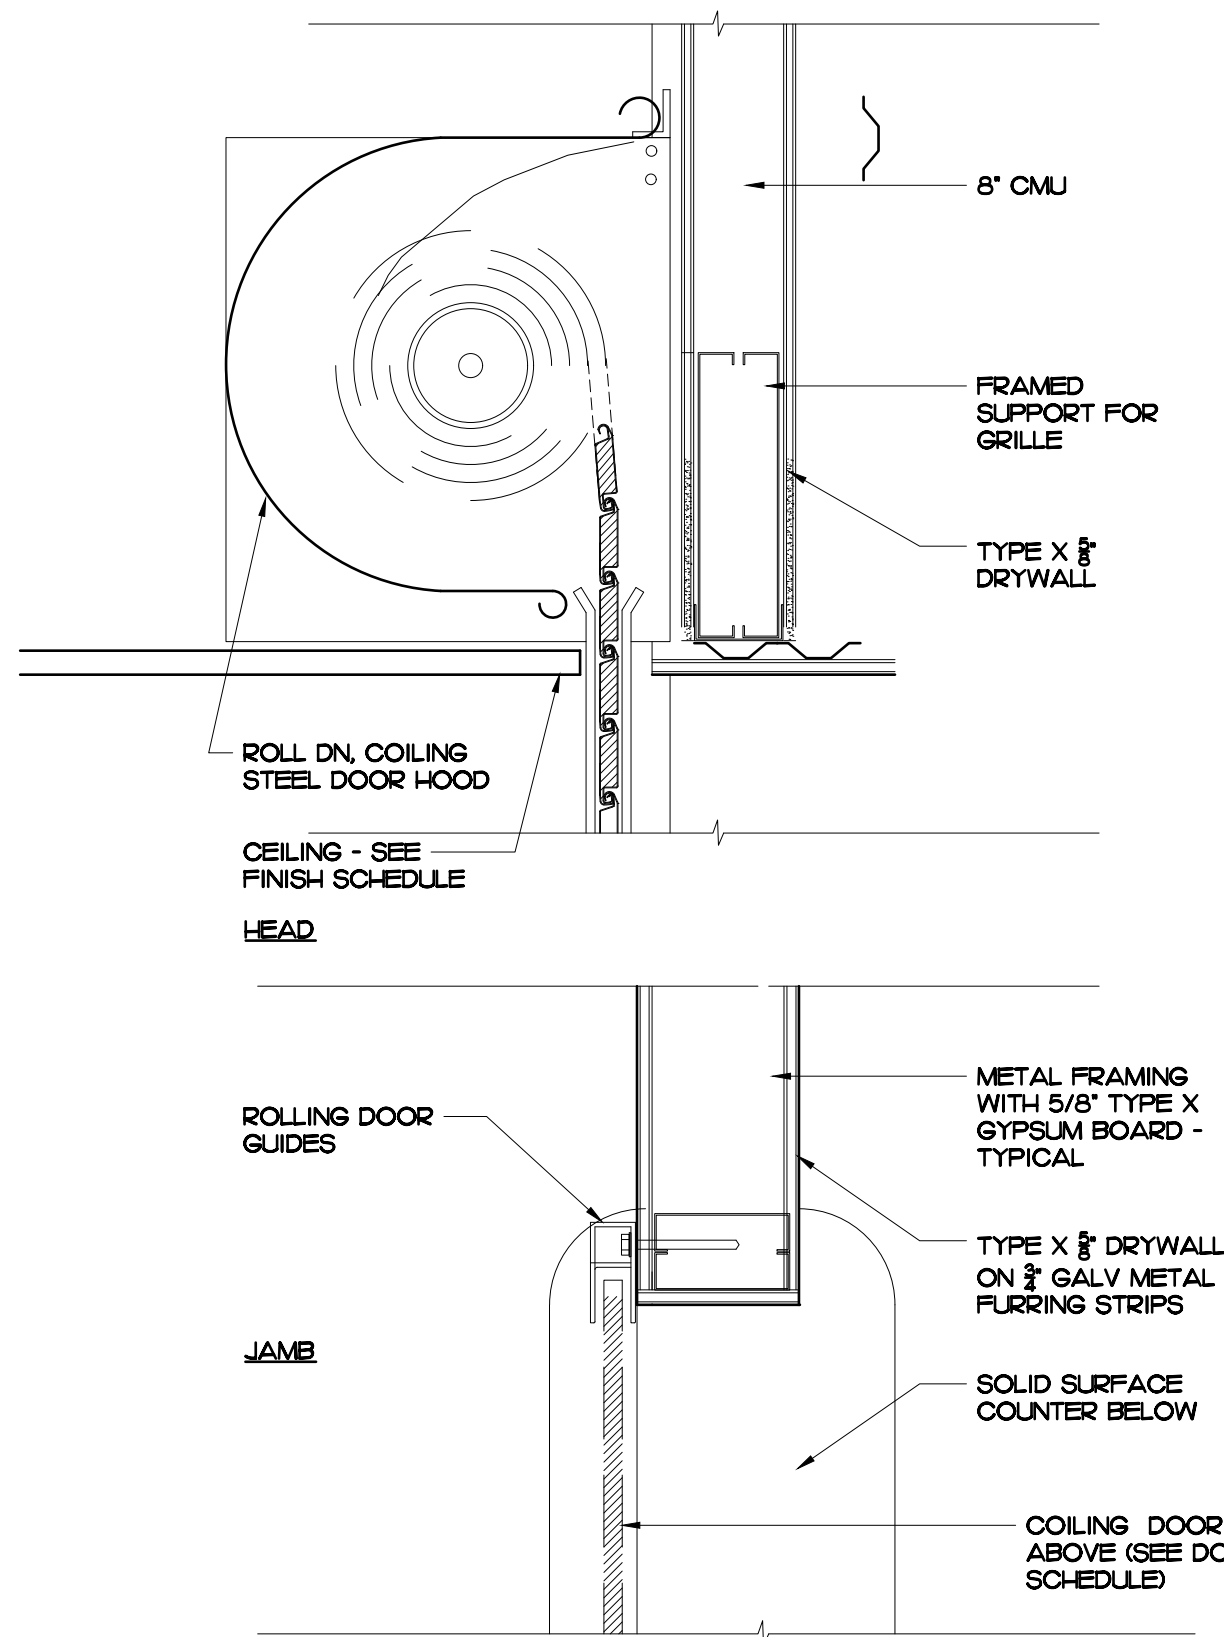


COILING GRILLE DETAIL

SCALE: 1 1/2" = 1'-0" **6**

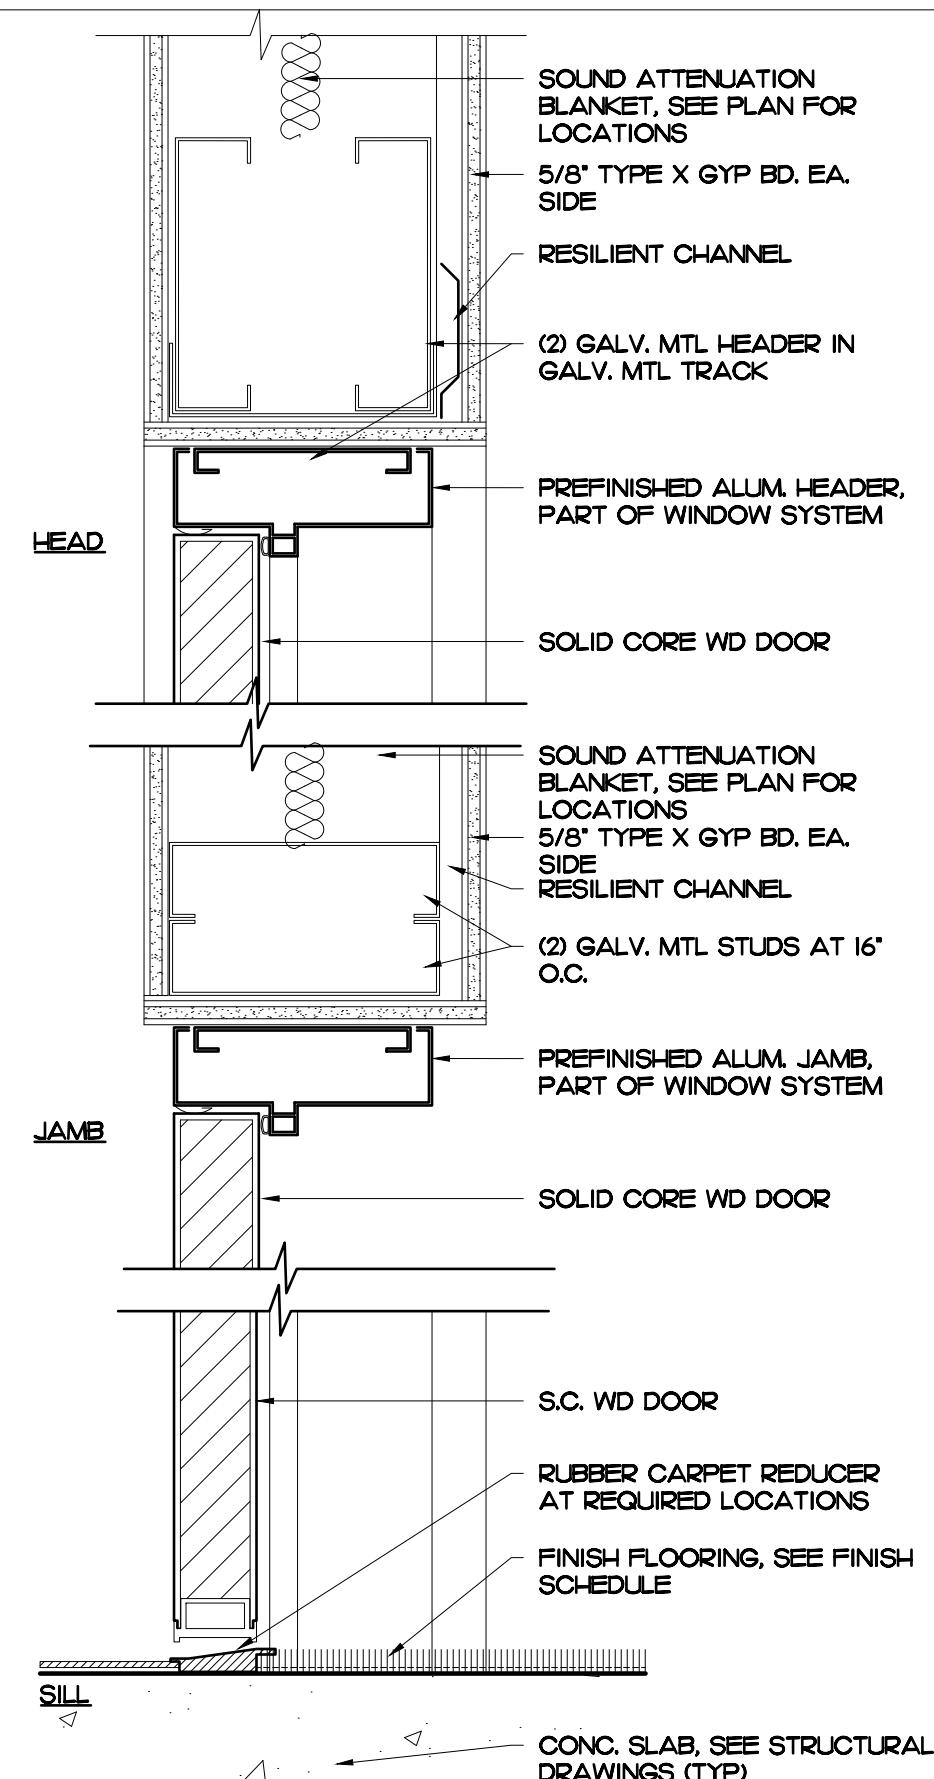


DOOR DTL

SCALE: 3" = 1'-0" **5**

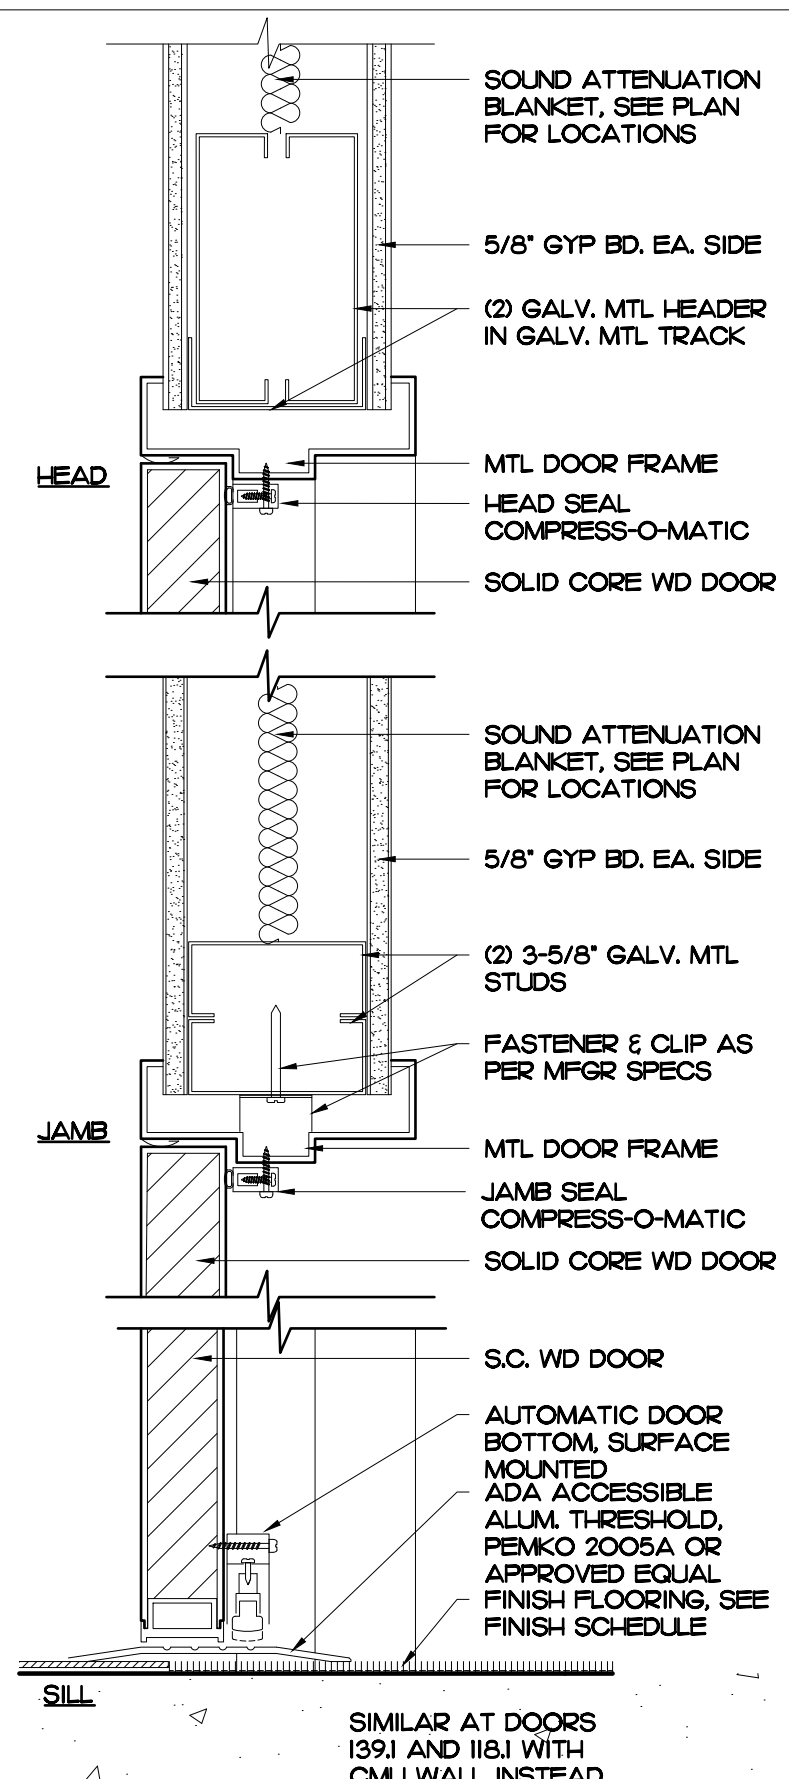


DOOR DTL

SCALE: 3" = 1'-0" **4**

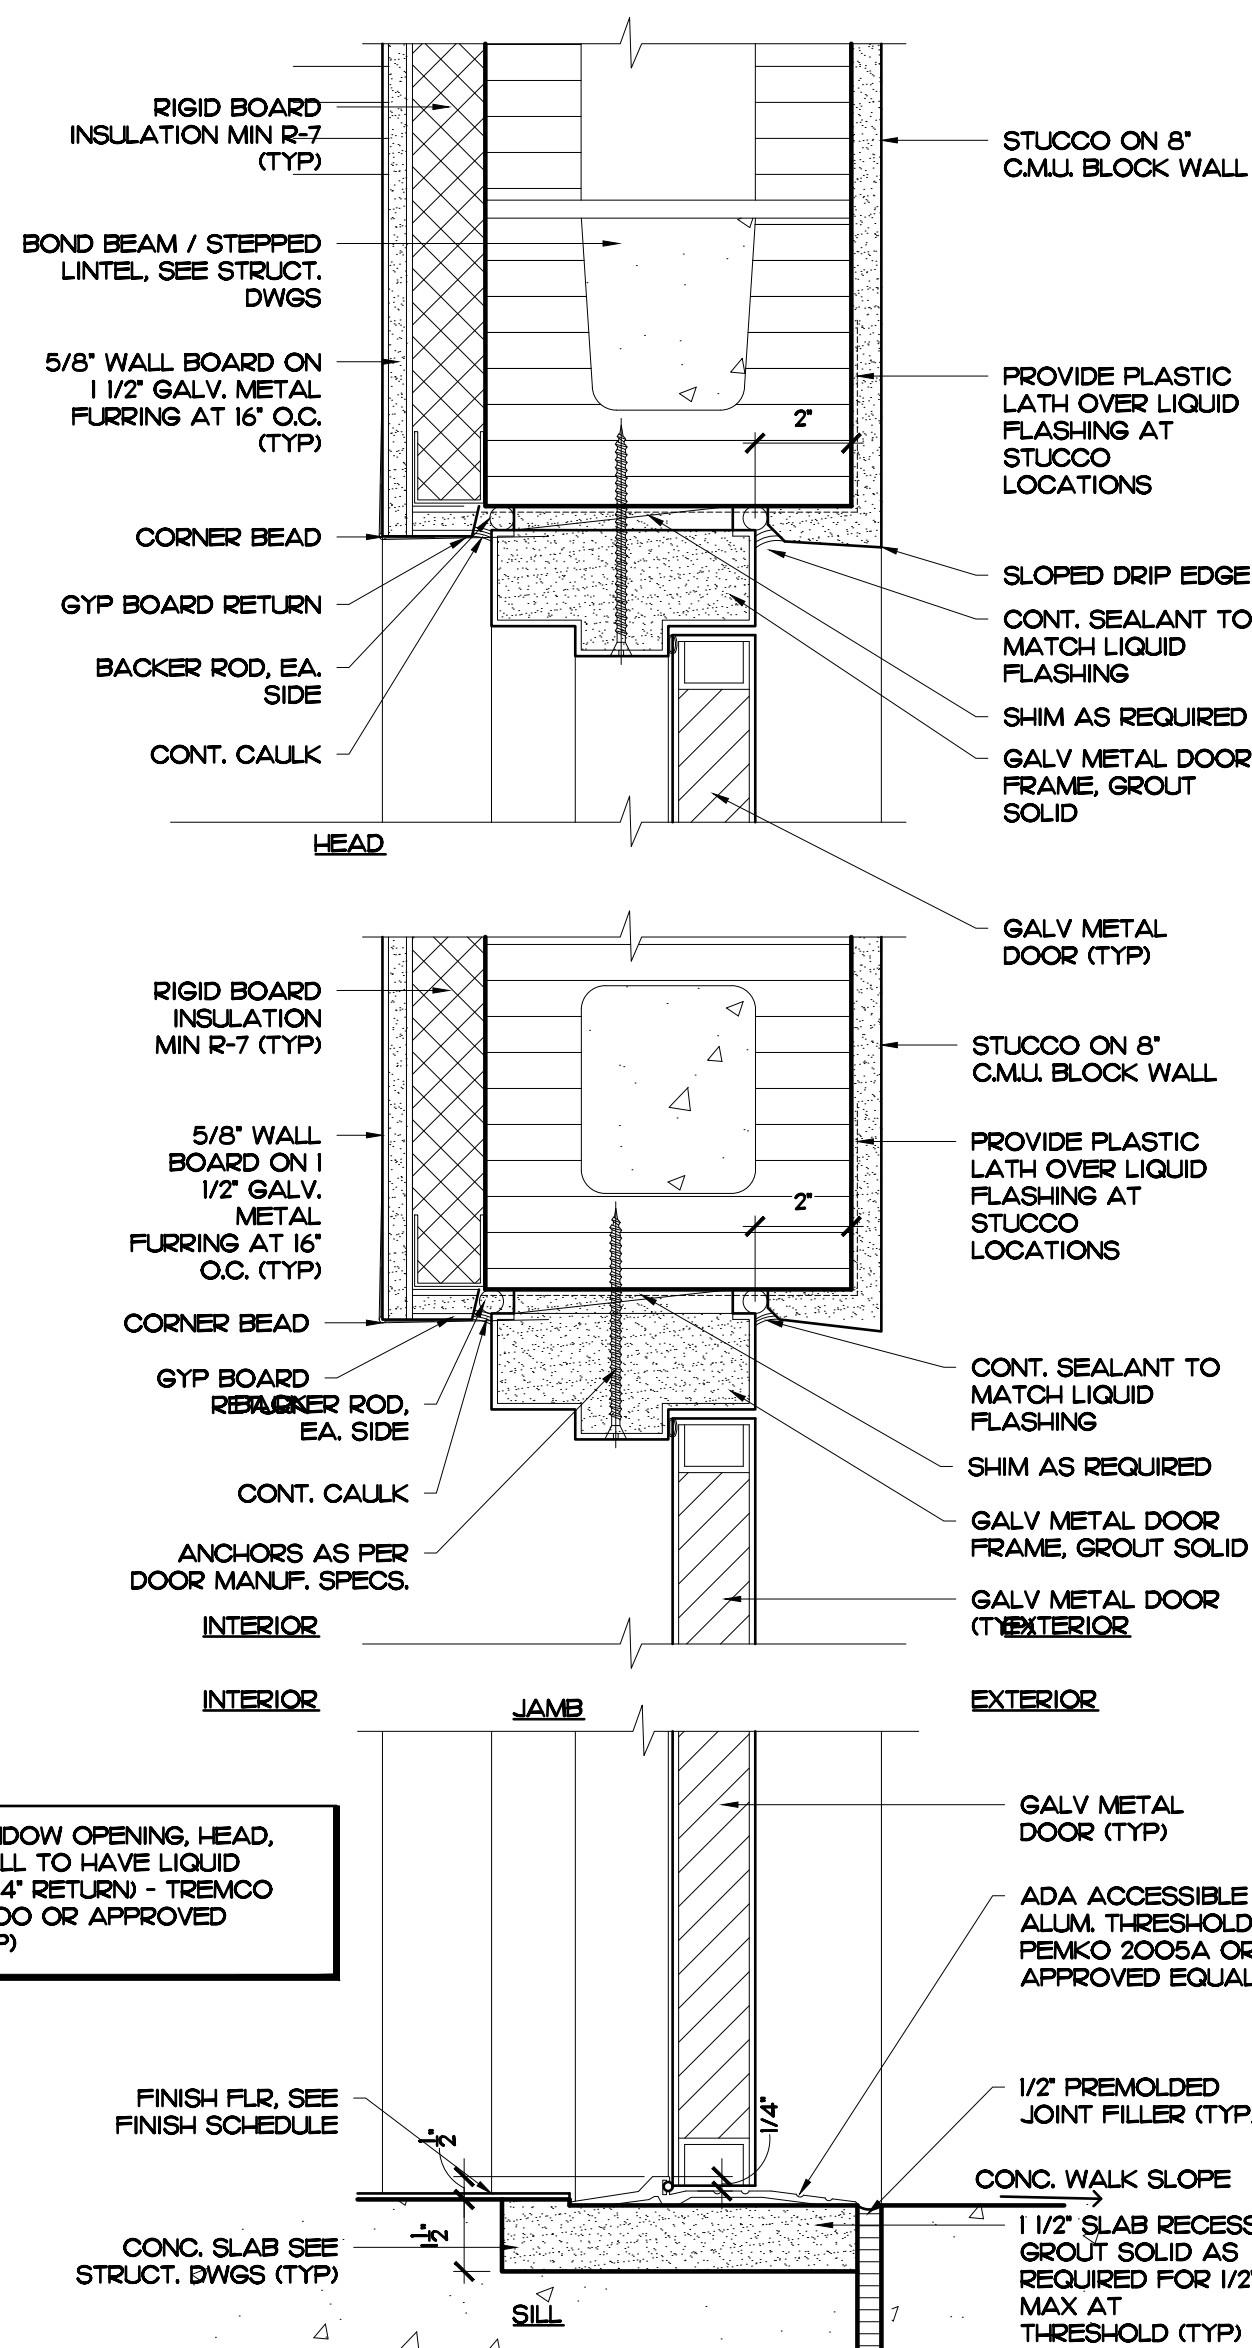


HM DOOR DETAILS

SCALE: 3" = 1'-0" **3**

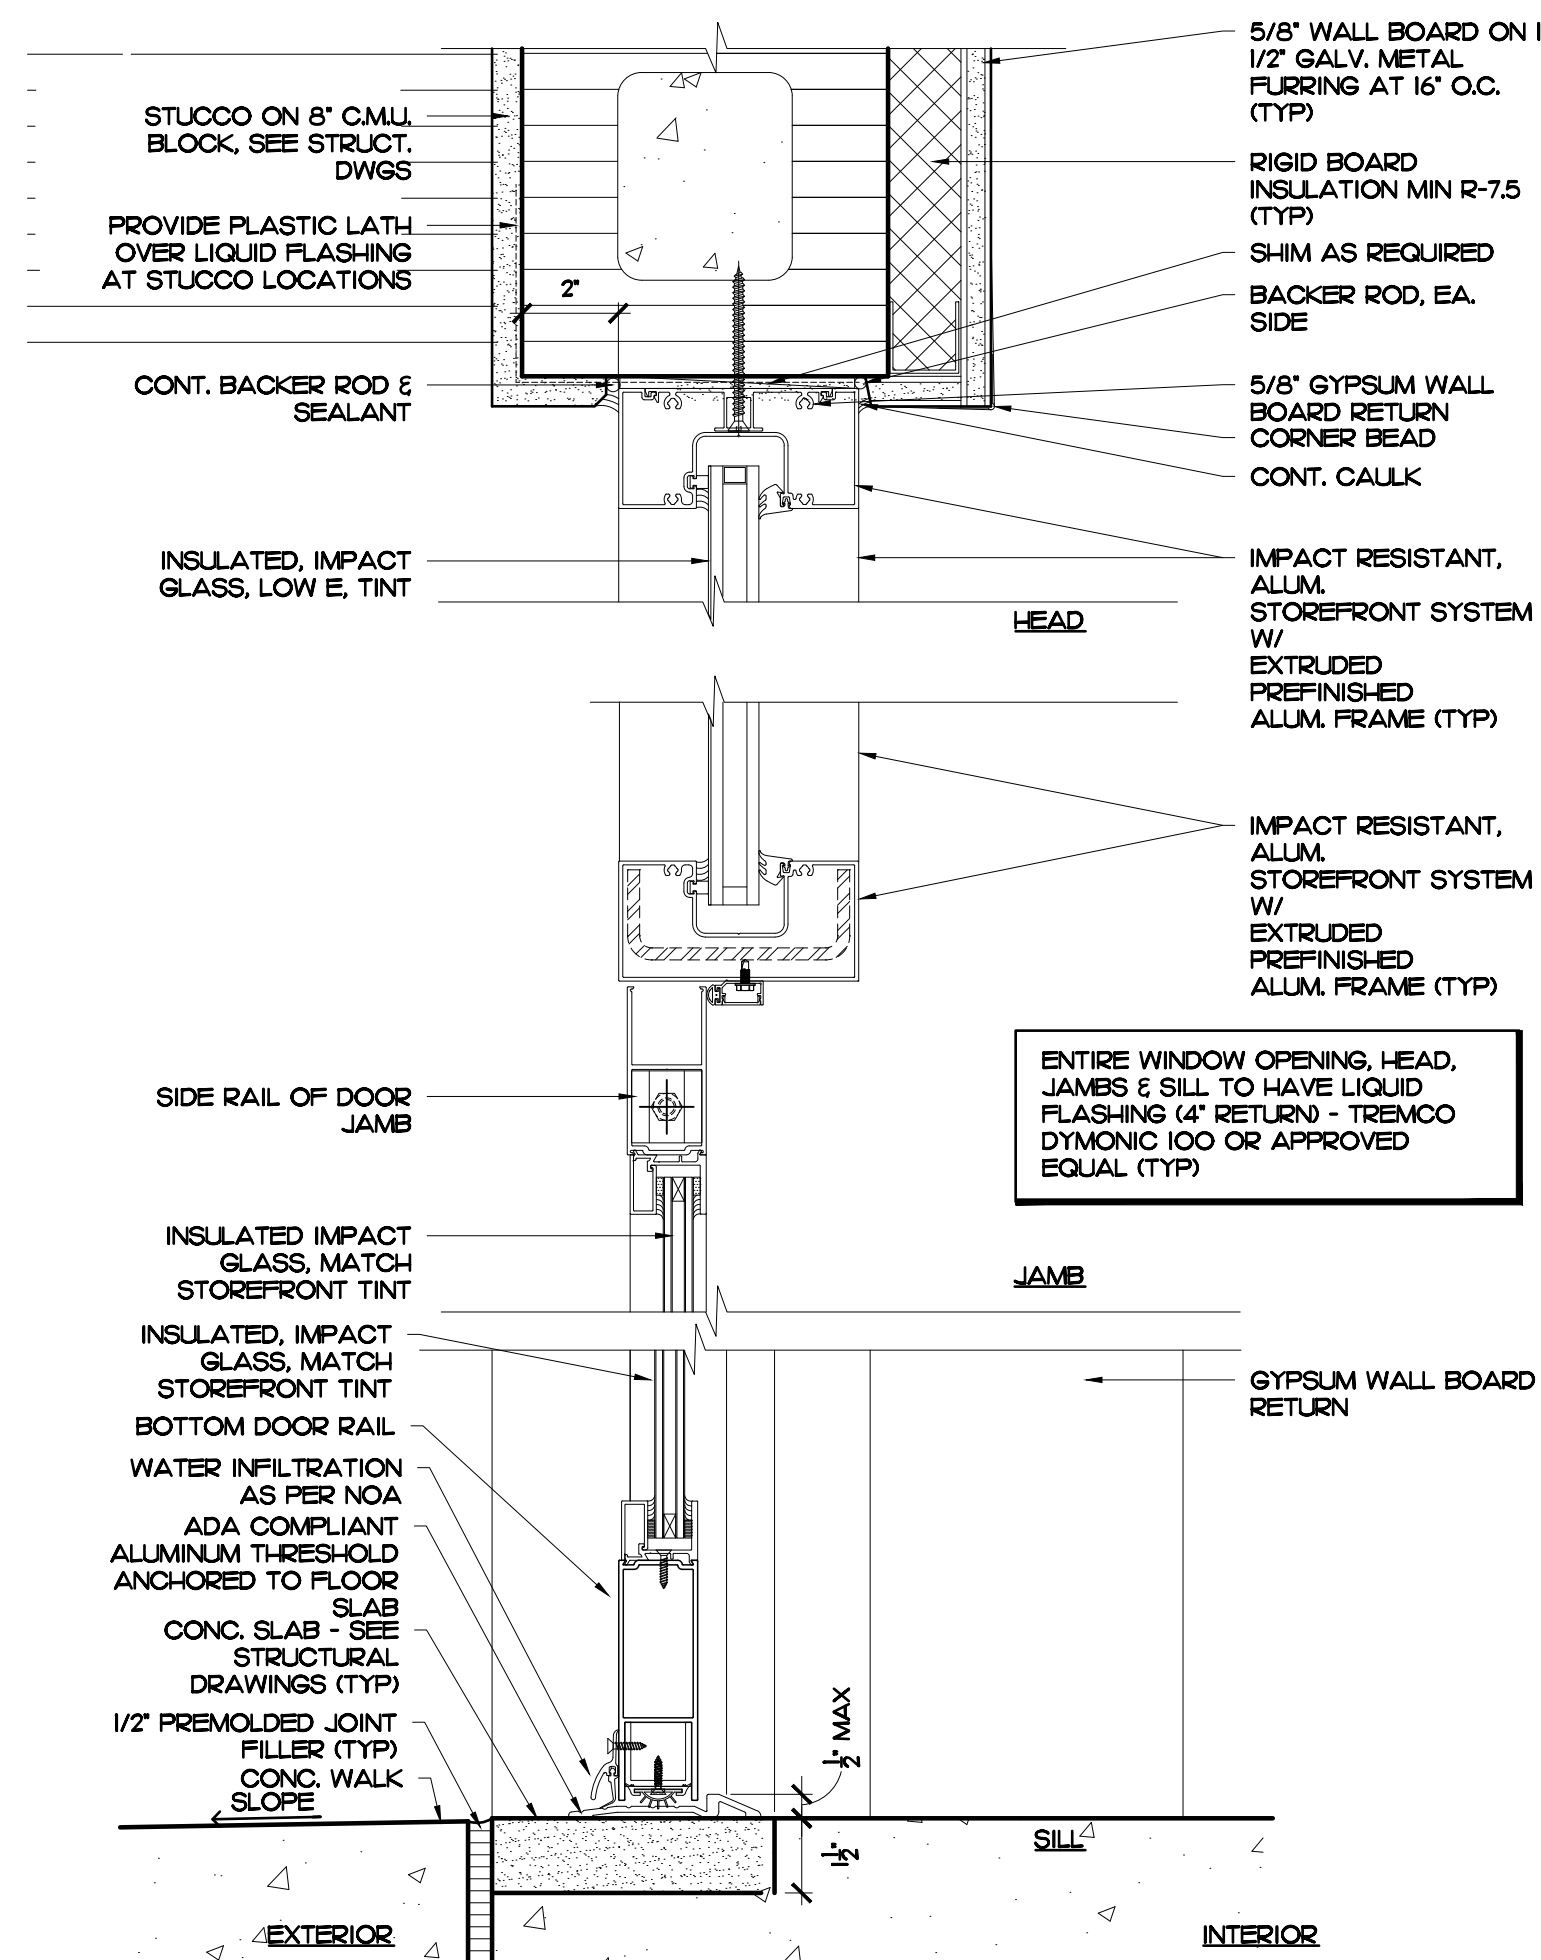

STOREFRONT DETAILS

SCALE: 3" = 1'-0" **2**

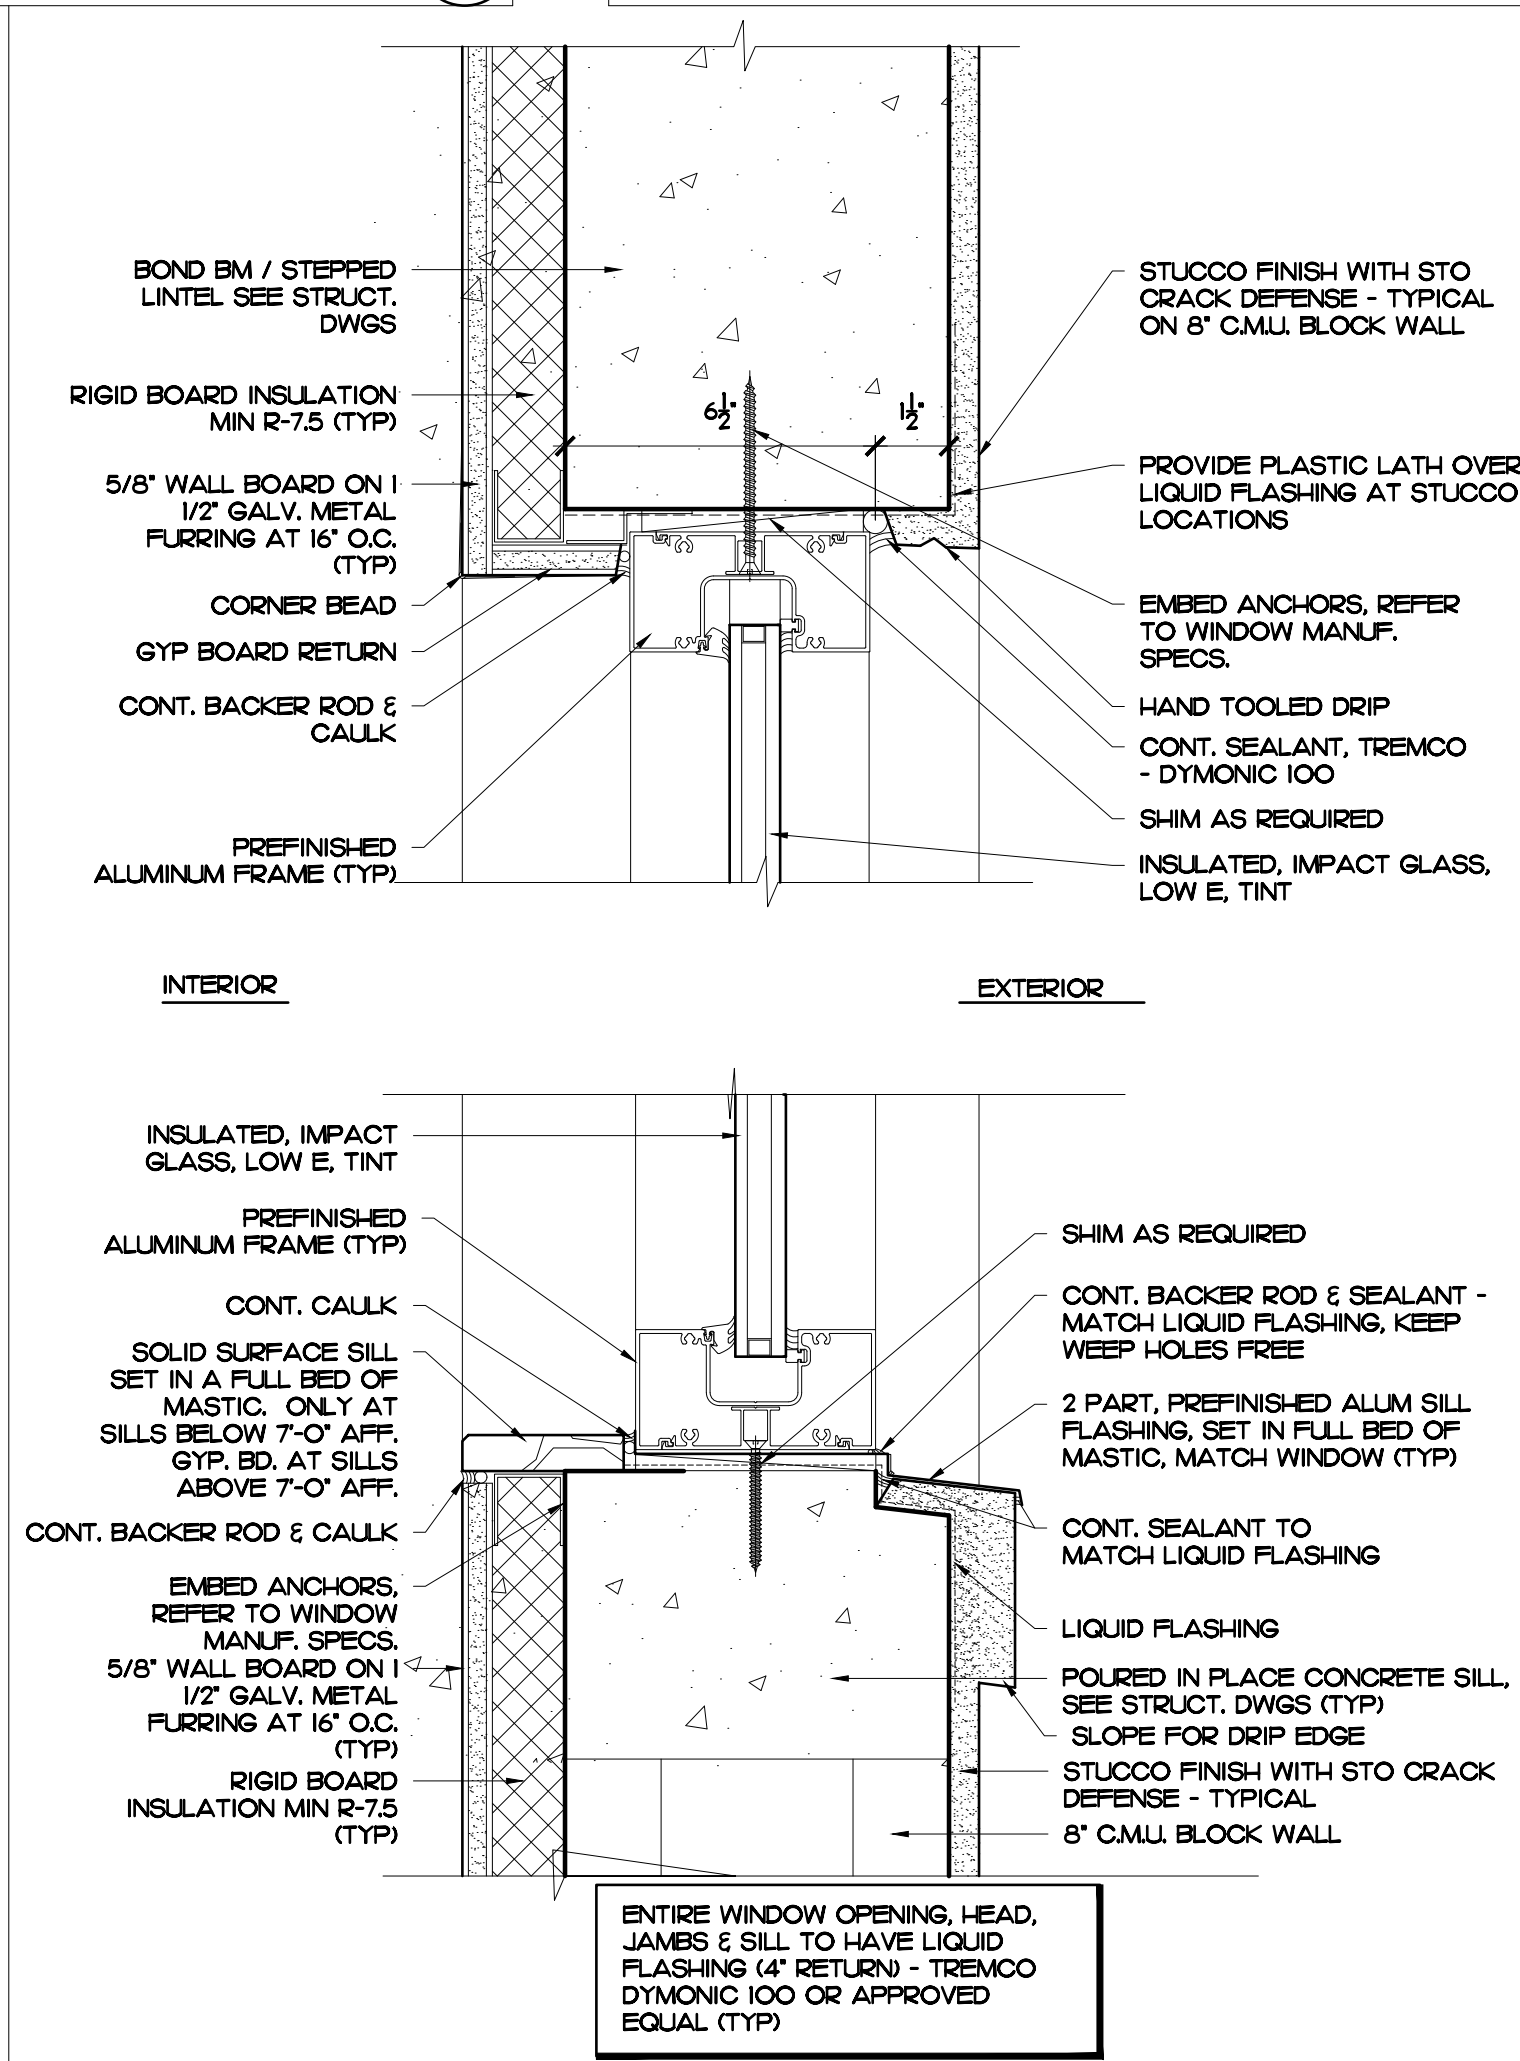

WINDOW DETAILS

SCALE: 3" = 1'-0" **1**