
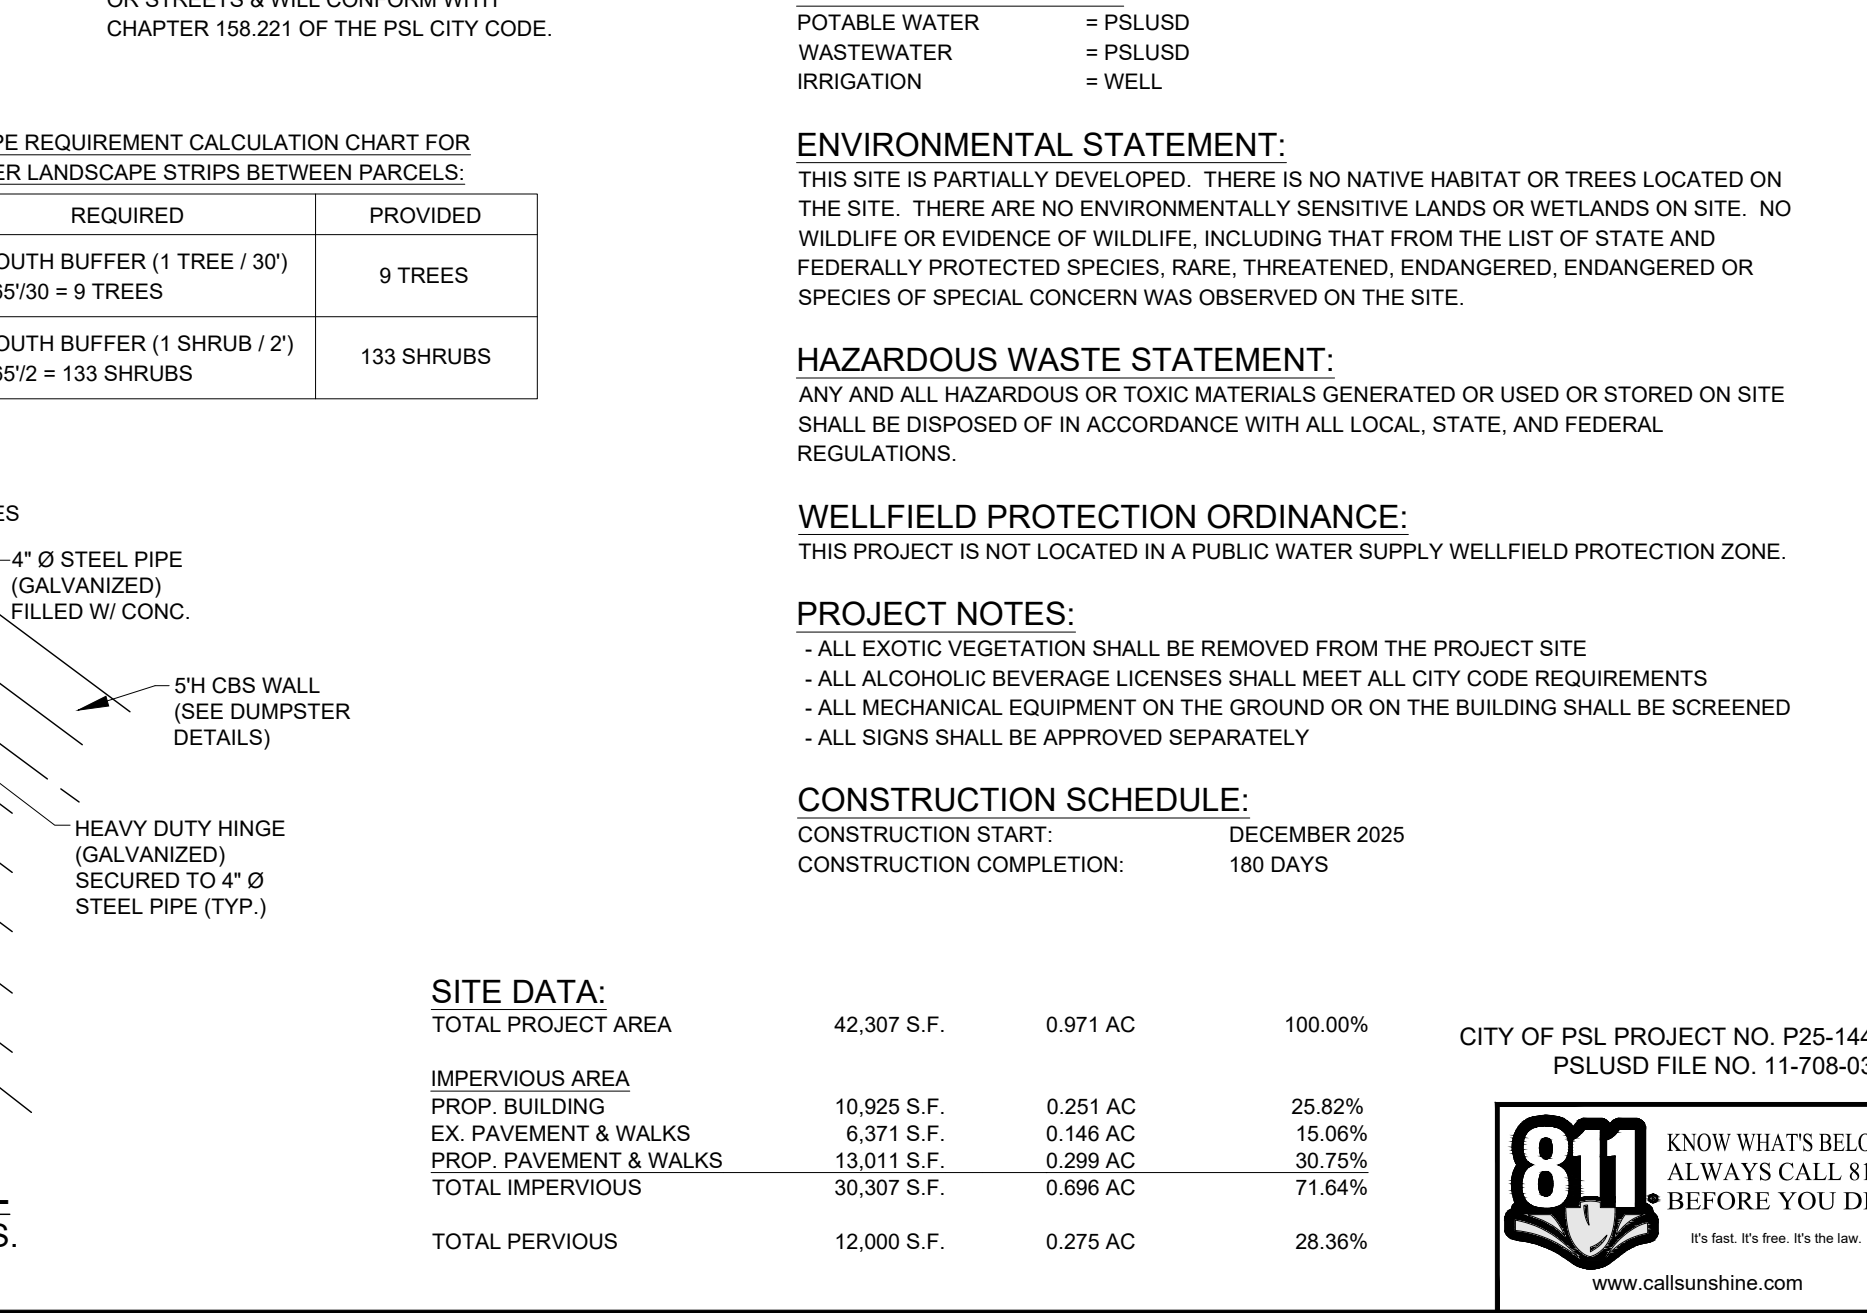
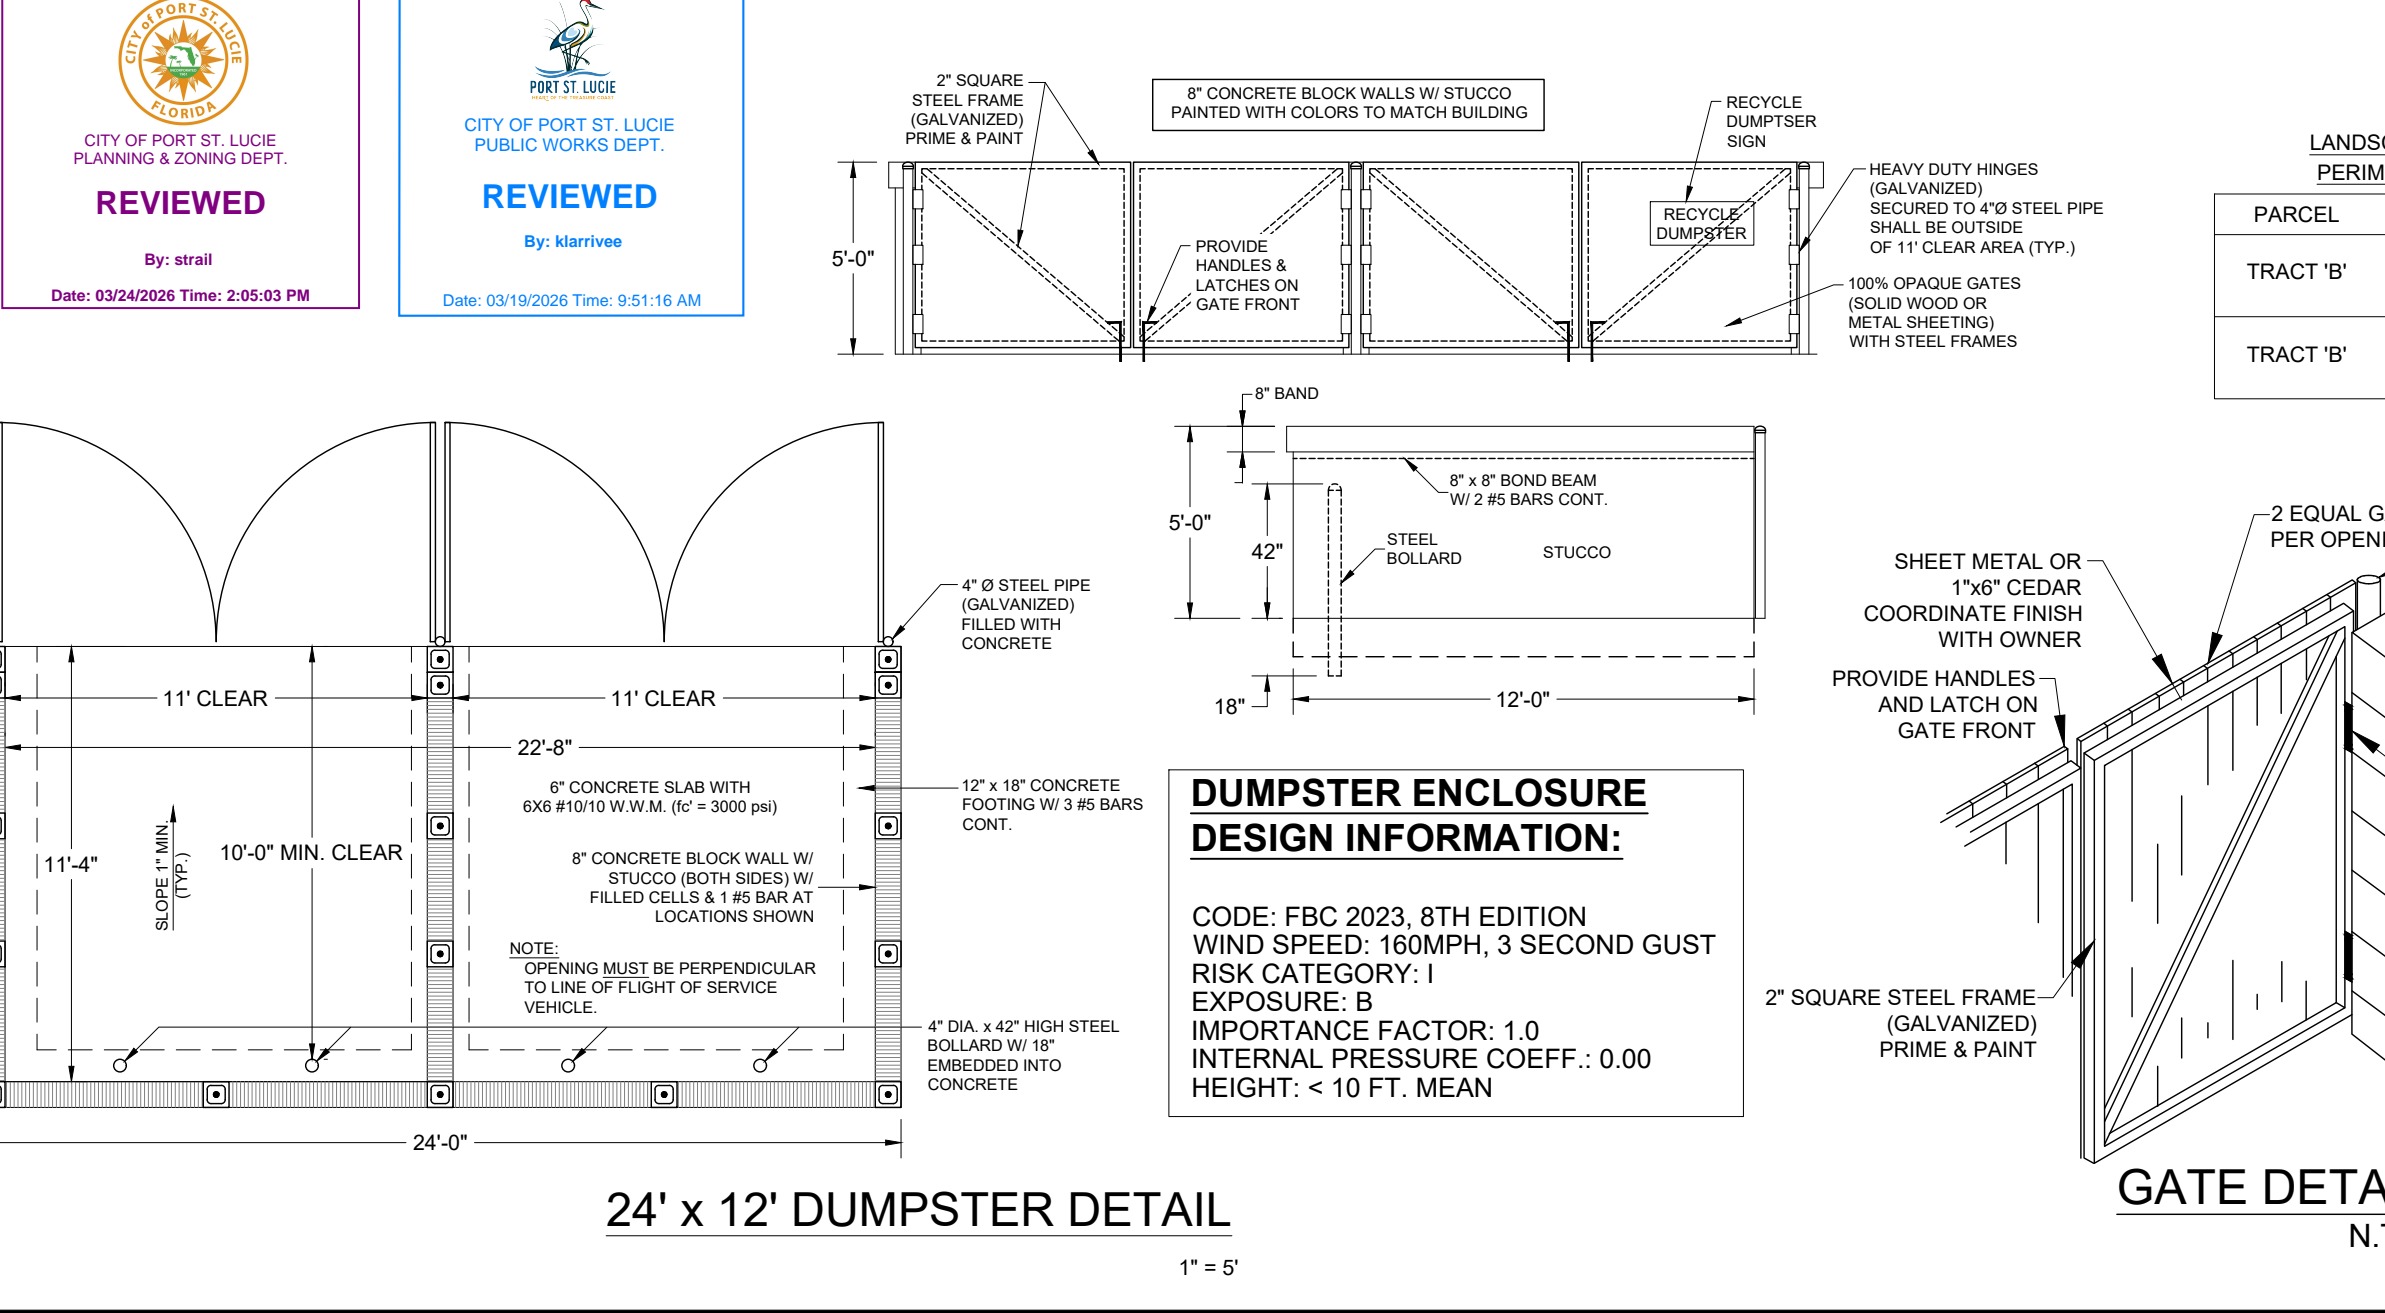
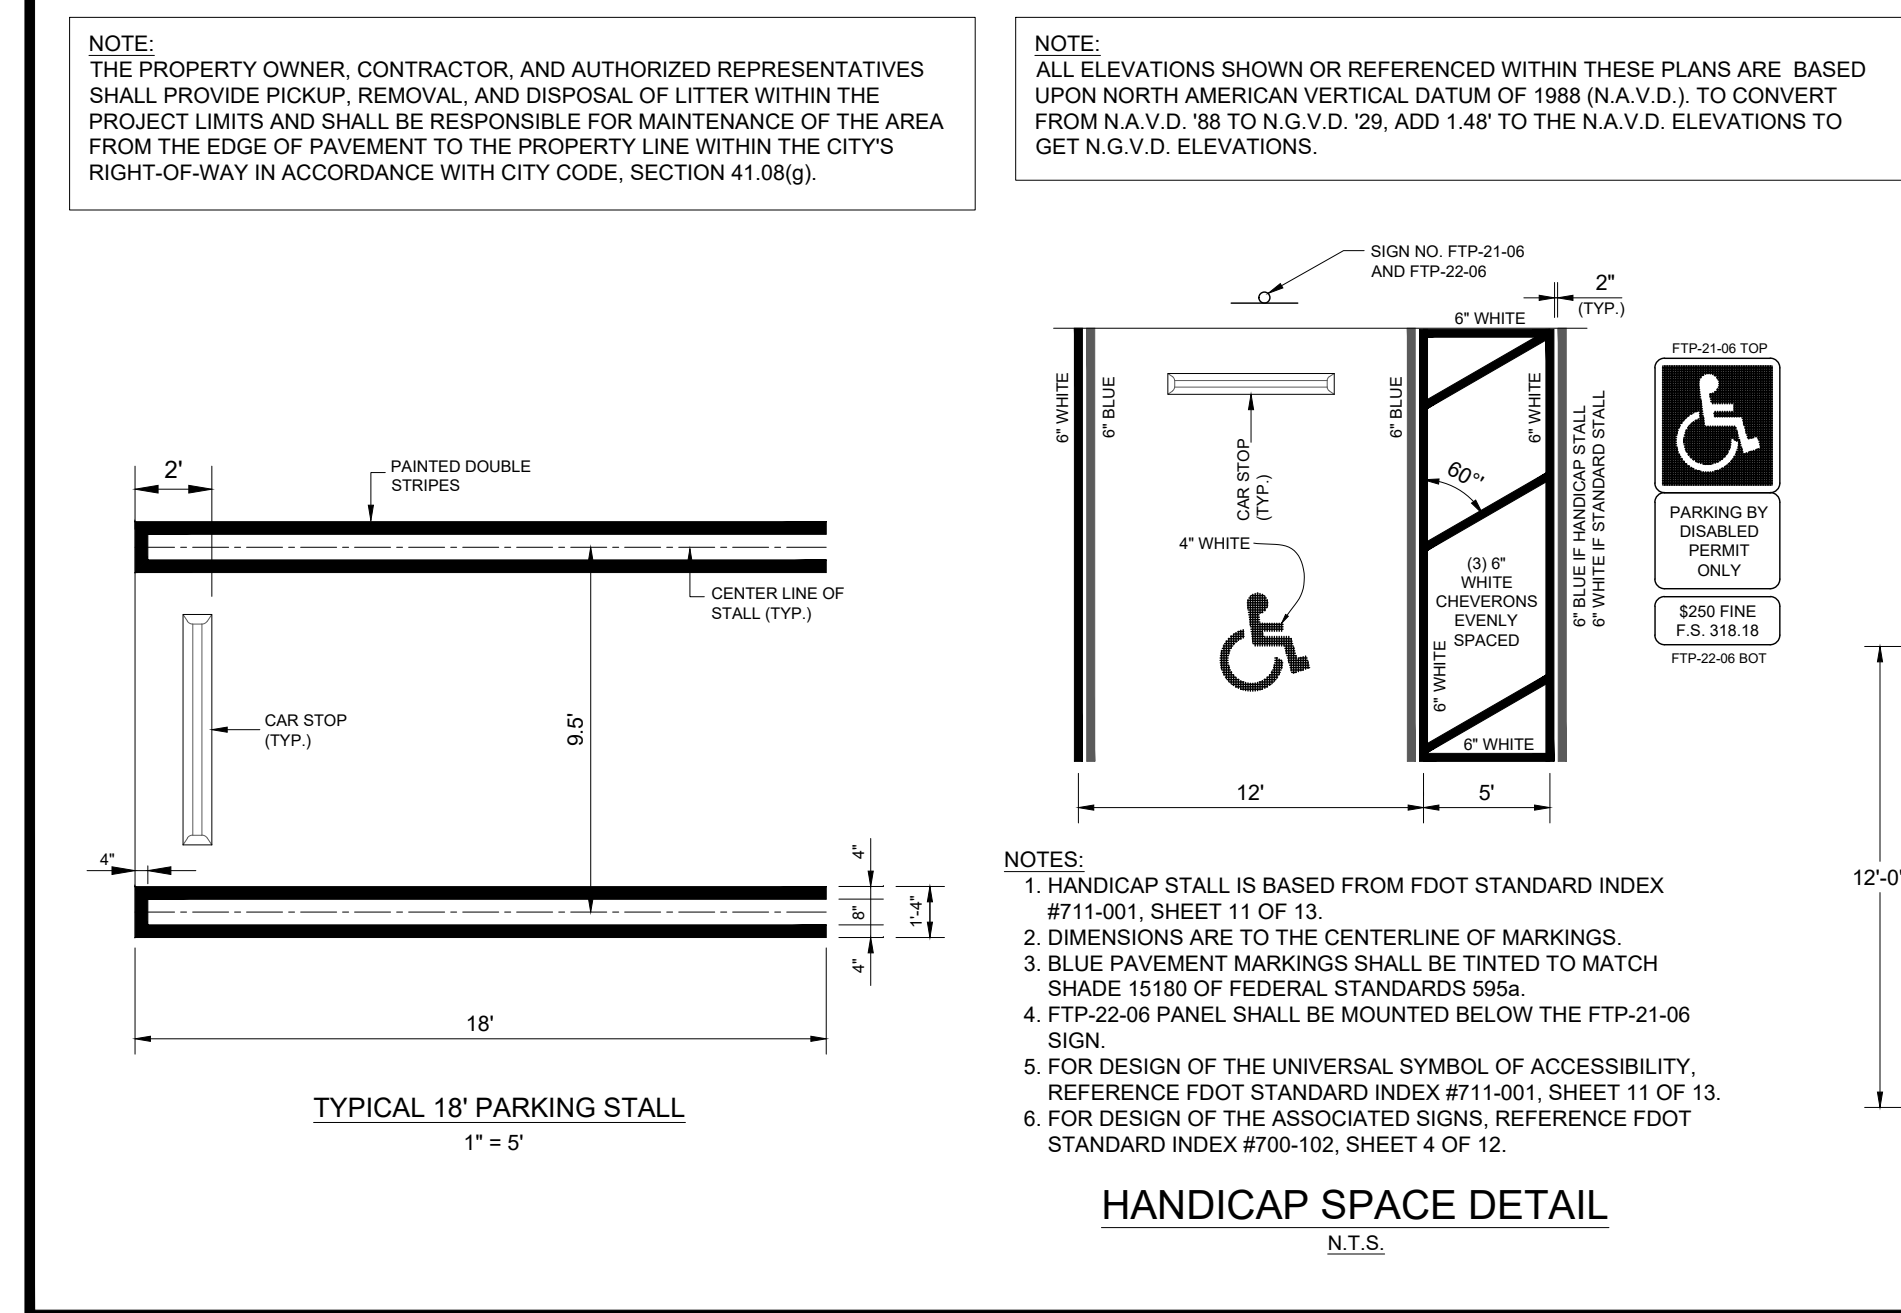
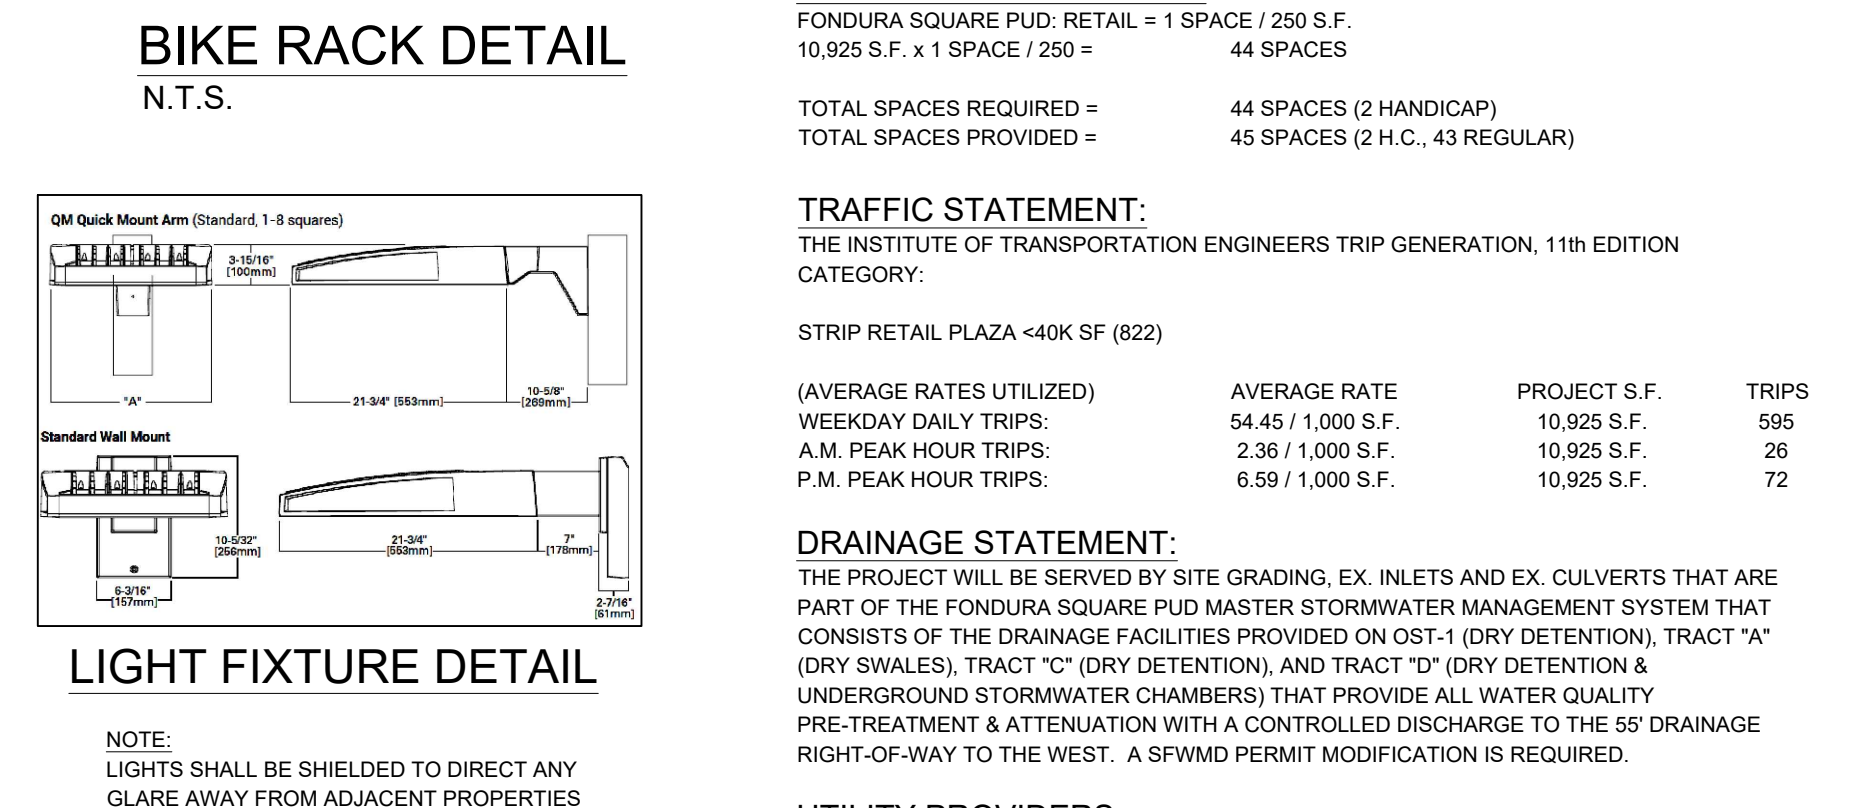


**LEGEND**

—	PROPERTY LINE	—	PROPOSED LIGHT FIXTURE ON POLE (25' MAX HEIGHT)	□	PROPOSED WALL LIGHT (6' MAX HEIGHT)
- - -	ADJACENT PROPERTY LINE	—	EXISTING WATER MAIN	—	PROPOSED SEWER MAIN
♿	HANDICAP STALL	—	EXISTING FORCE MAIN	—	PROPOSED SANITARY LATERAL
⊙	NUMBER OF PROPOSED PARKING SPACES	—	EXISTING LOW PRESSURE MAIN	—	PROPOSED WATER MAIN
→	TRAFFIC FLOW DIRECTION	—	EXISTING SANITARY LATERAL	—	PROPOSED PAVEMENT
⊠	EXISTING CATCH BASIN	—	EXISTING SEWER MAIN	—	PROPOSED CONCRETE
○	PROPOSED CLEAN OUT	—	EXISTING EDGE OF PAVEMENT		

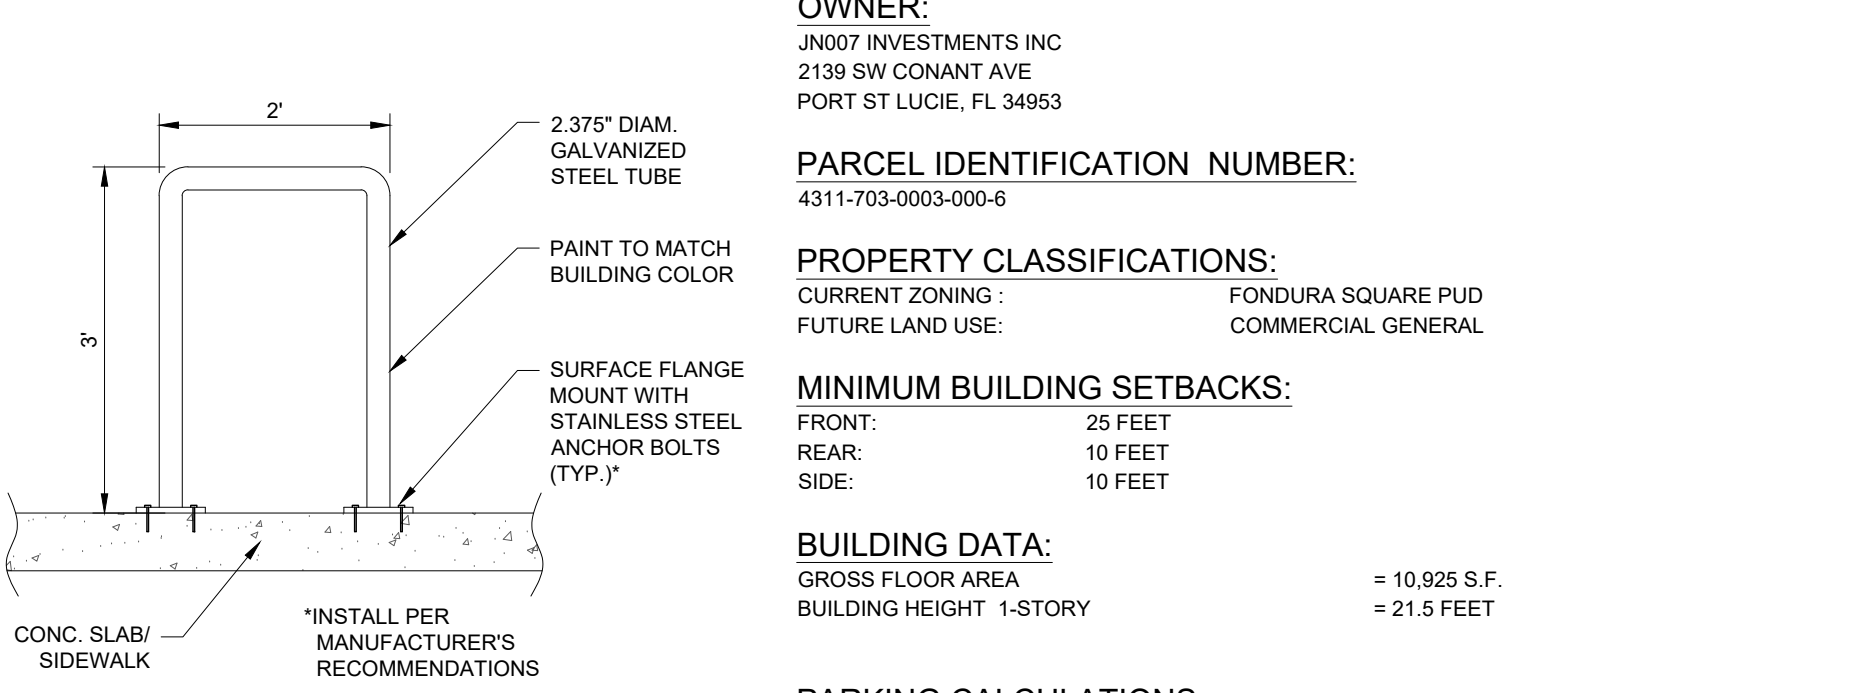

**ENGINEERING**

ONE16 ENGINEERING  
 2861 W MIDWAY RD  
 FORT PIERCE, FL 34981  
 PHONE: (772) 828-3514  
 EMAIL: ADMIN@ONE16ENGINEERING.COM

**REVISIONS:**

BY:	DATE:	COMMENT:
TG	11/18/25	PER PSL COMMENTS
TG	12/15/25	PER PSL COMMENTS
TG	12/17/25	PER PSL COMMENTS
TG	02/23/26	PER PSL COMMENTS

**PROJECT:**  
**FONDURA PLAZA**  
 PORT SAINT LUCIE  
 FLORIDA

**PROFESSIONAL ENGINEER**  
 M. RANDALL RODGERS  
 NO. 68212  
 STATE OF FLORIDA

PROJECT NO.: 25-026  
 DRAWN BY: TC  
 CHECKED BY: RR  
 DATE: 08-20-25

**SITE PLAN**

SHEET NUMBER:  
**C-1**

KNOW WHAT'S BELOW  
 ALWAYS CALL 811  
 BEFORE YOU DIG  
 It's fast. It's free. It's the law.  
 www.call811.com