


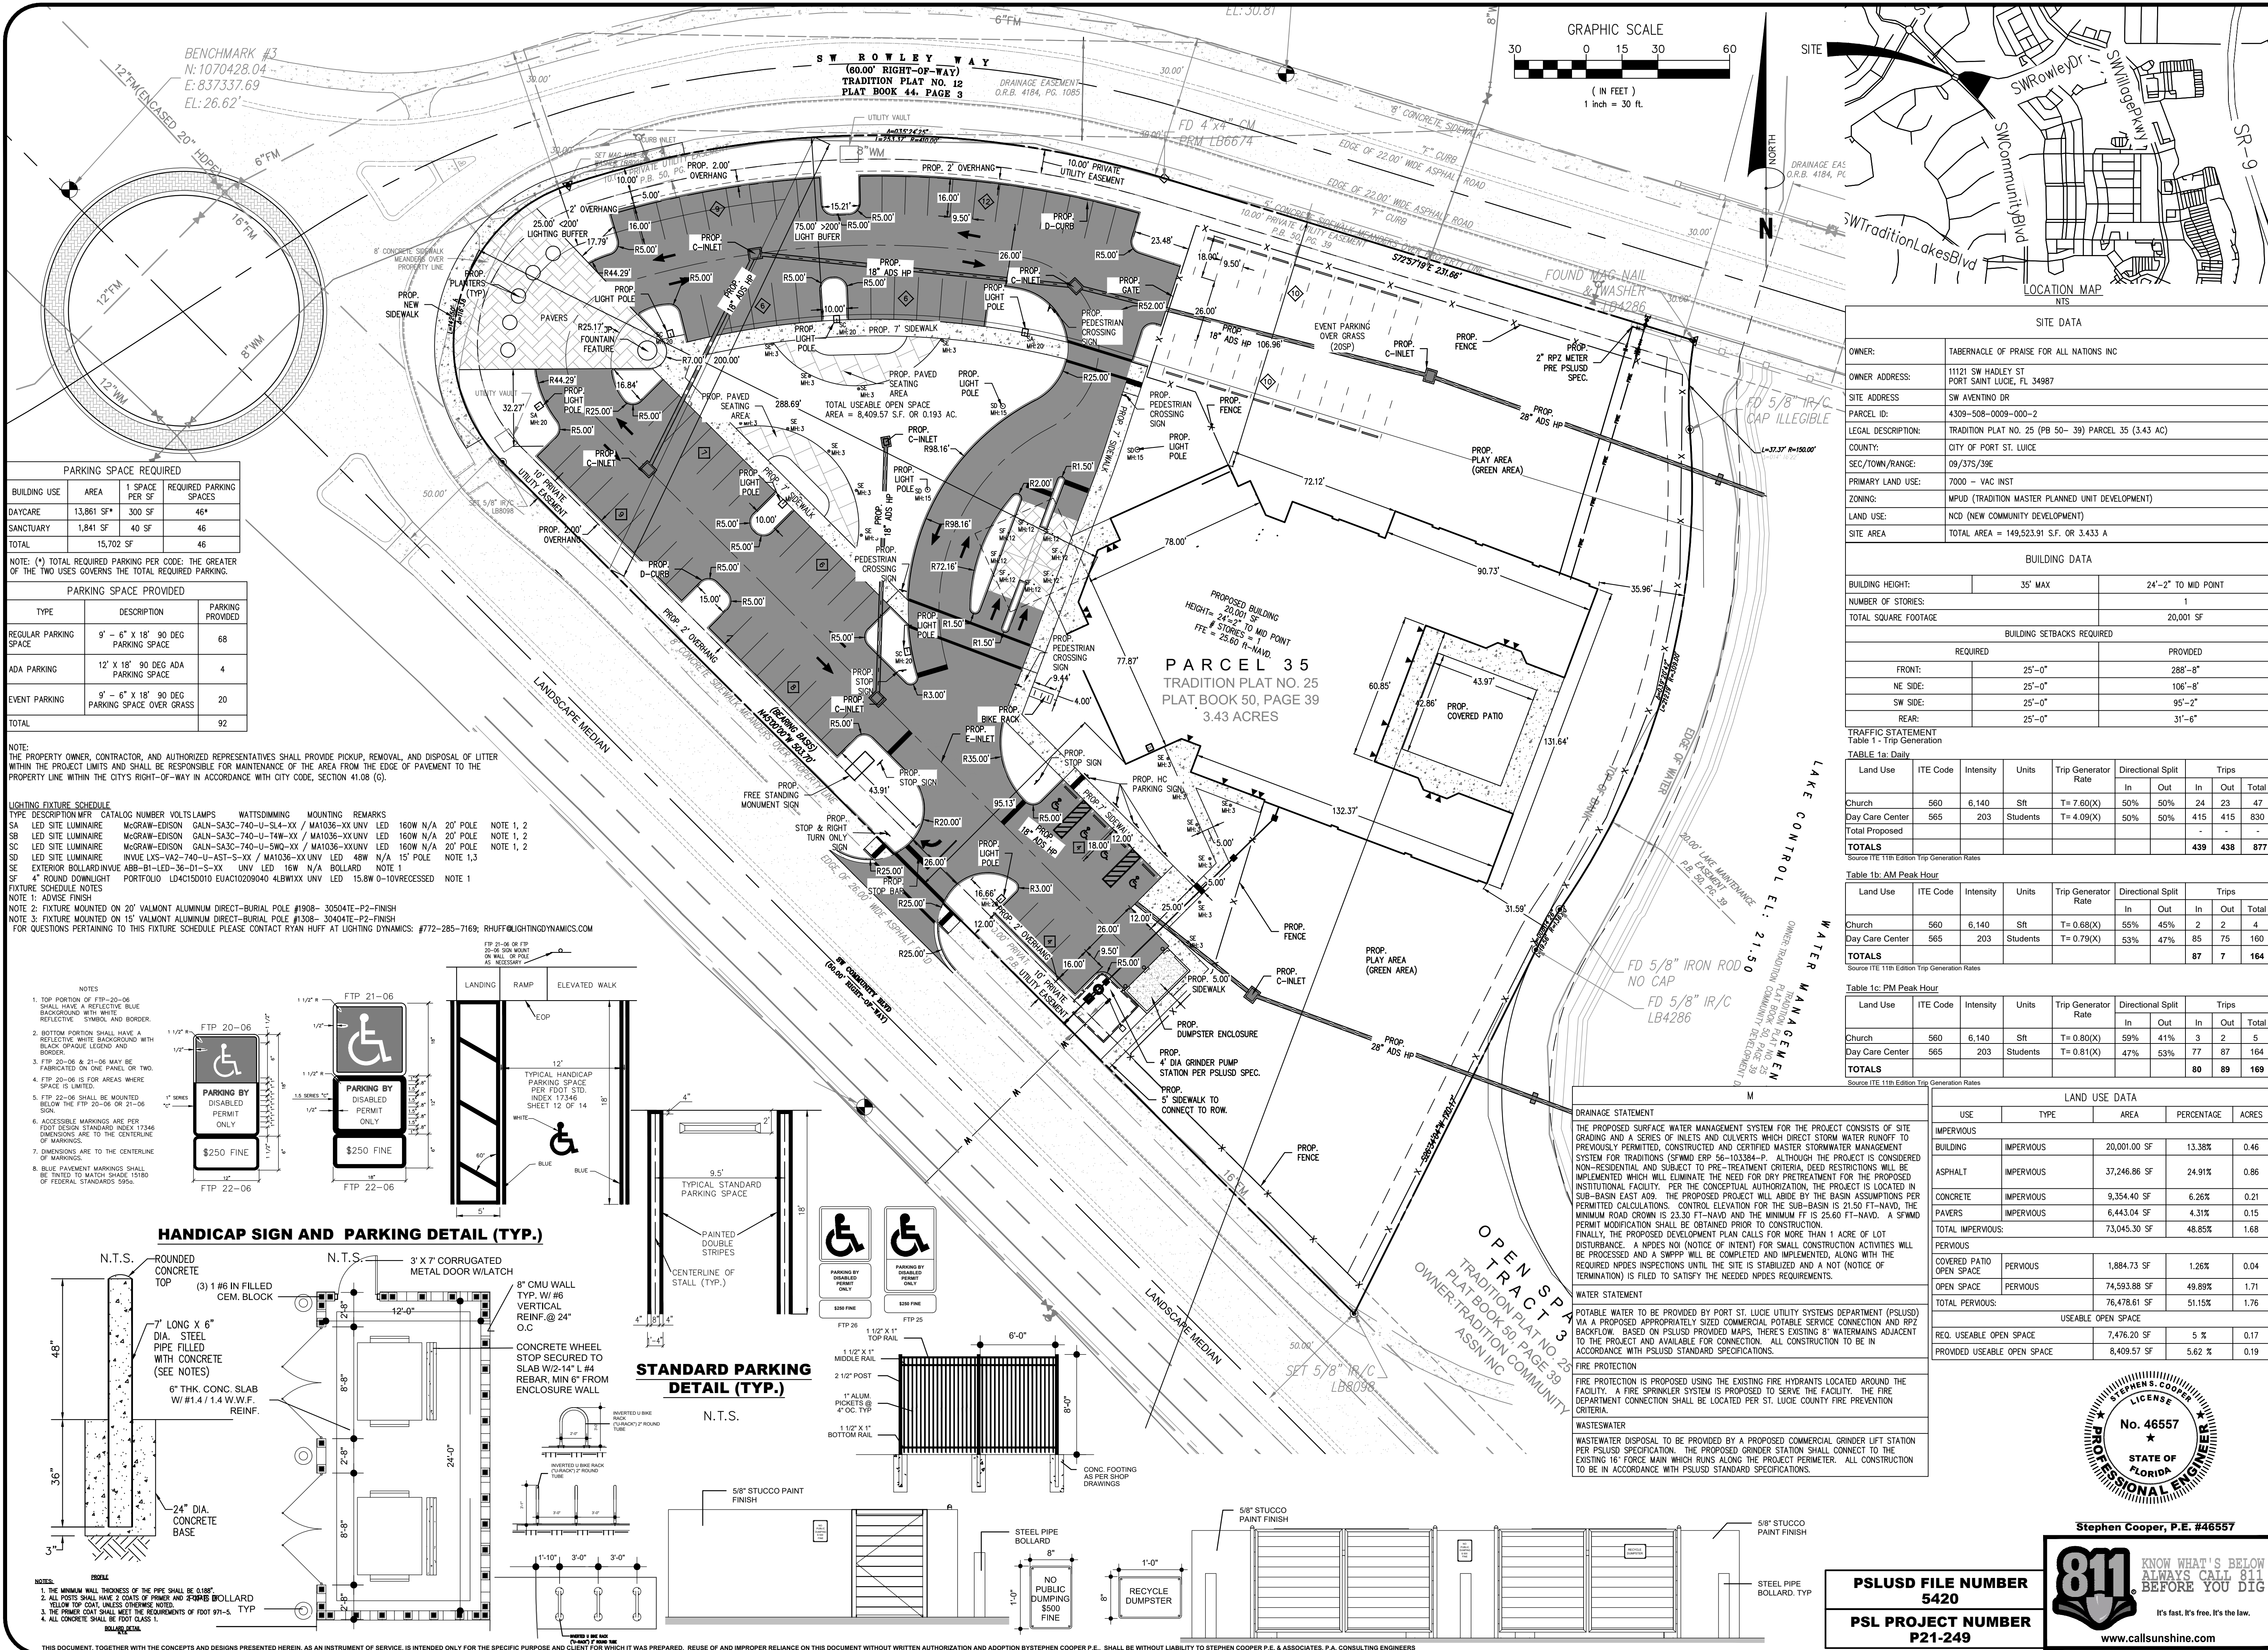

STEPHEN COOPER, P.E. & ASSOCIATES, INC.
CIVIL ENGINEERING • SITE PLANNING • ENVIRONMENTAL PERMITTING
- CONSULTING ENGINEER -

811
KNOW WHAT'S BELOW
ALWAYS CALL 811
BEFORE YOU DIG
It's fast. It's free. It's the law.
www.callsshine.com

FLORIDA CERTIFICATE OF AUTHORIZATION No. 0008666
Stephen Cooper, P.E. #46557

DATE: JAN 2023
DRAWN BY: CCL
DESIGNED BY: SC
CHECKED BY: SC
HORIZ. SCALE: 1"=30'
VERT. SCALE: N/A
DRAWING NO.: C1.0
JOB NO.: 2021-125

REVISION

NO.	REVISION	DATE
1	REV. LIGHTING PLAN	01/25/23
2	REV. LIGHTING PLAN	01/25/23
3	REV. LIGHTING PLAN	01/25/23
4	REV. LIGHTING PLAN	01/25/23
5	REV. LIGHTING PLAN	01/25/23
6	REV. LIGHTING PLAN	01/25/23
7	REV. LIGHTING PLAN	01/25/23
8	REV. LIGHTING PLAN	01/25/23
9	REV. LIGHTING PLAN	01/25/23
10	REV. LIGHTING PLAN	01/25/23

FLORIDA
CITY OF PORT ST. LUCIE